

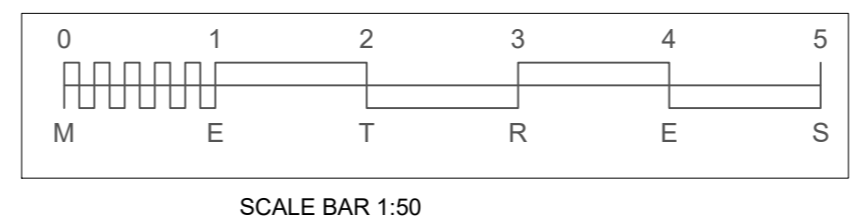
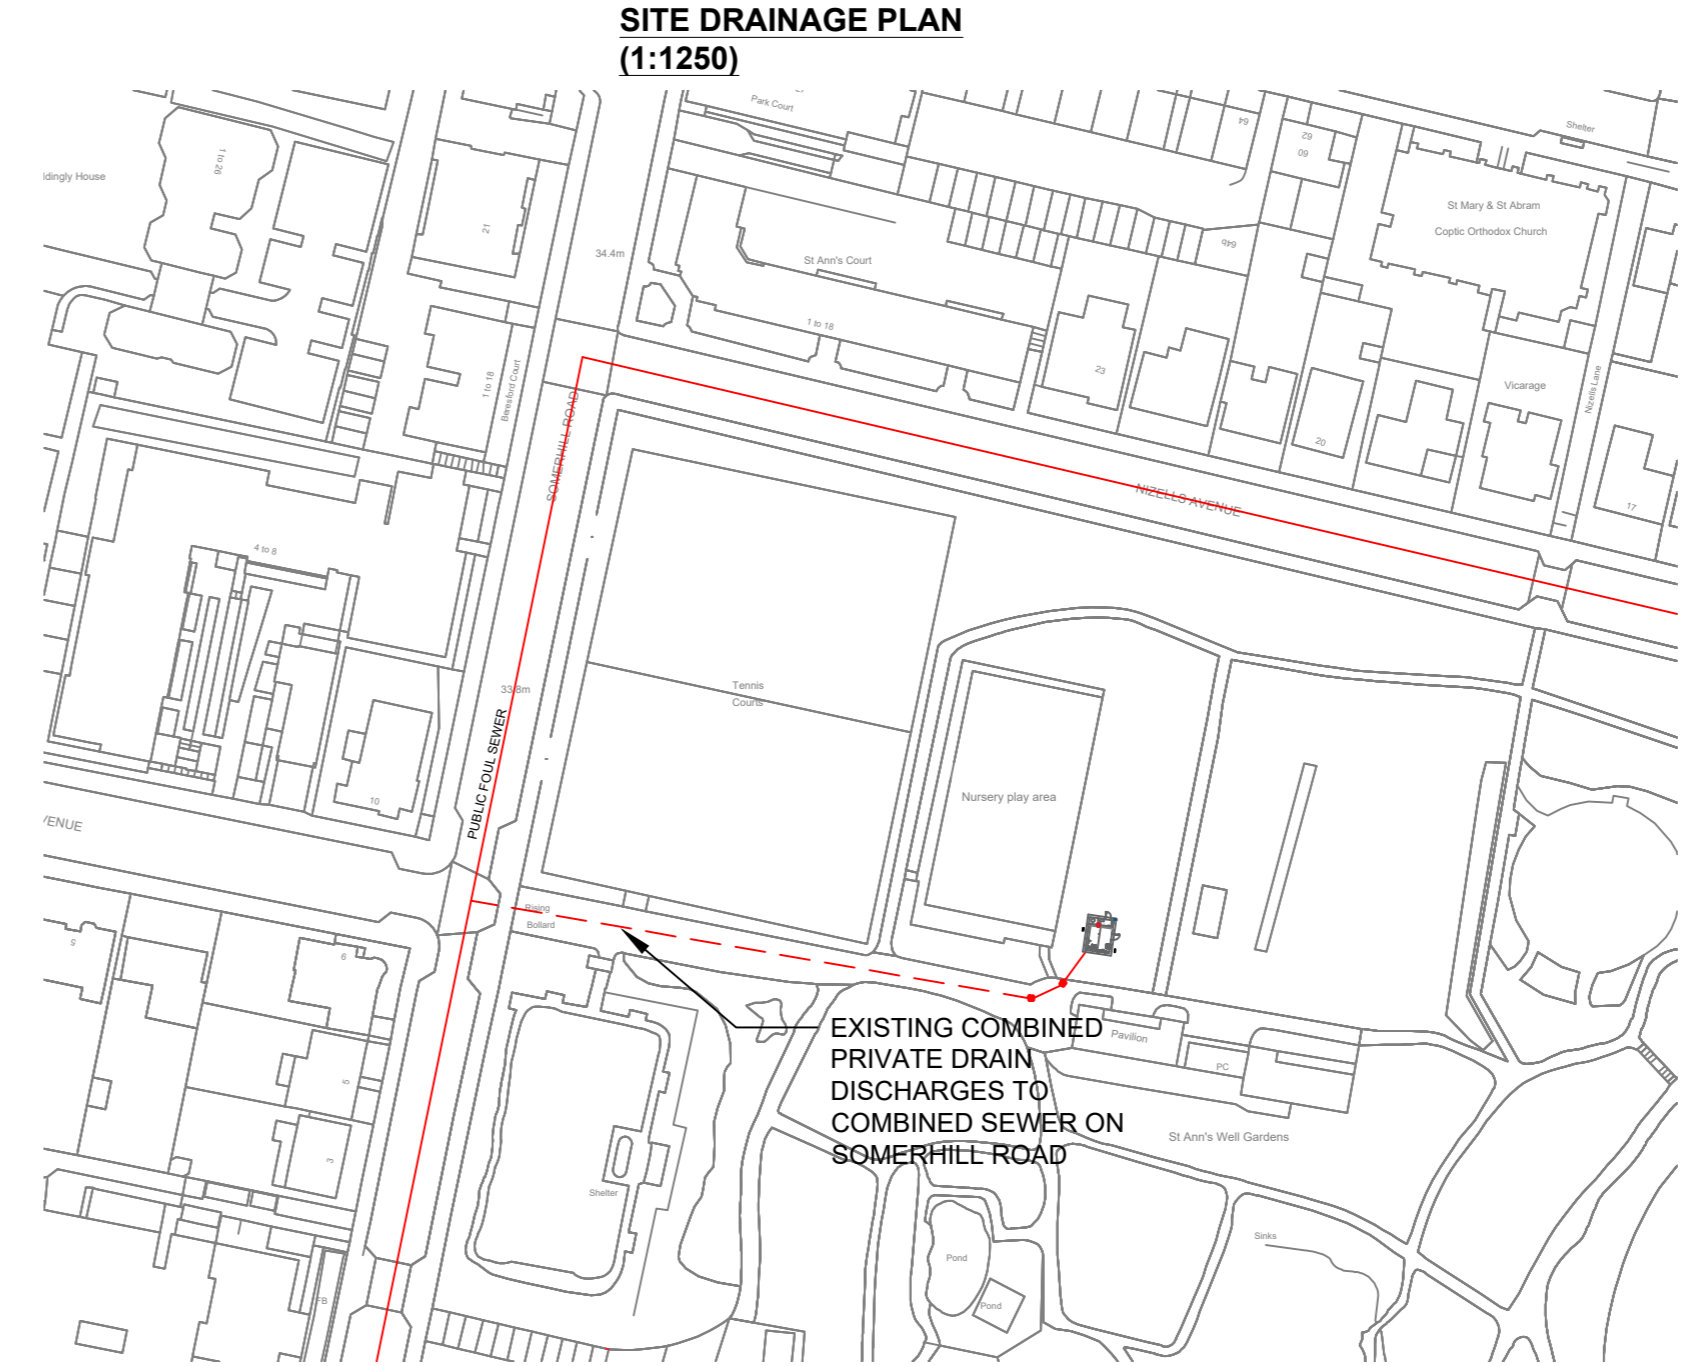


SITE DRAINAGE PLAN (1:50)

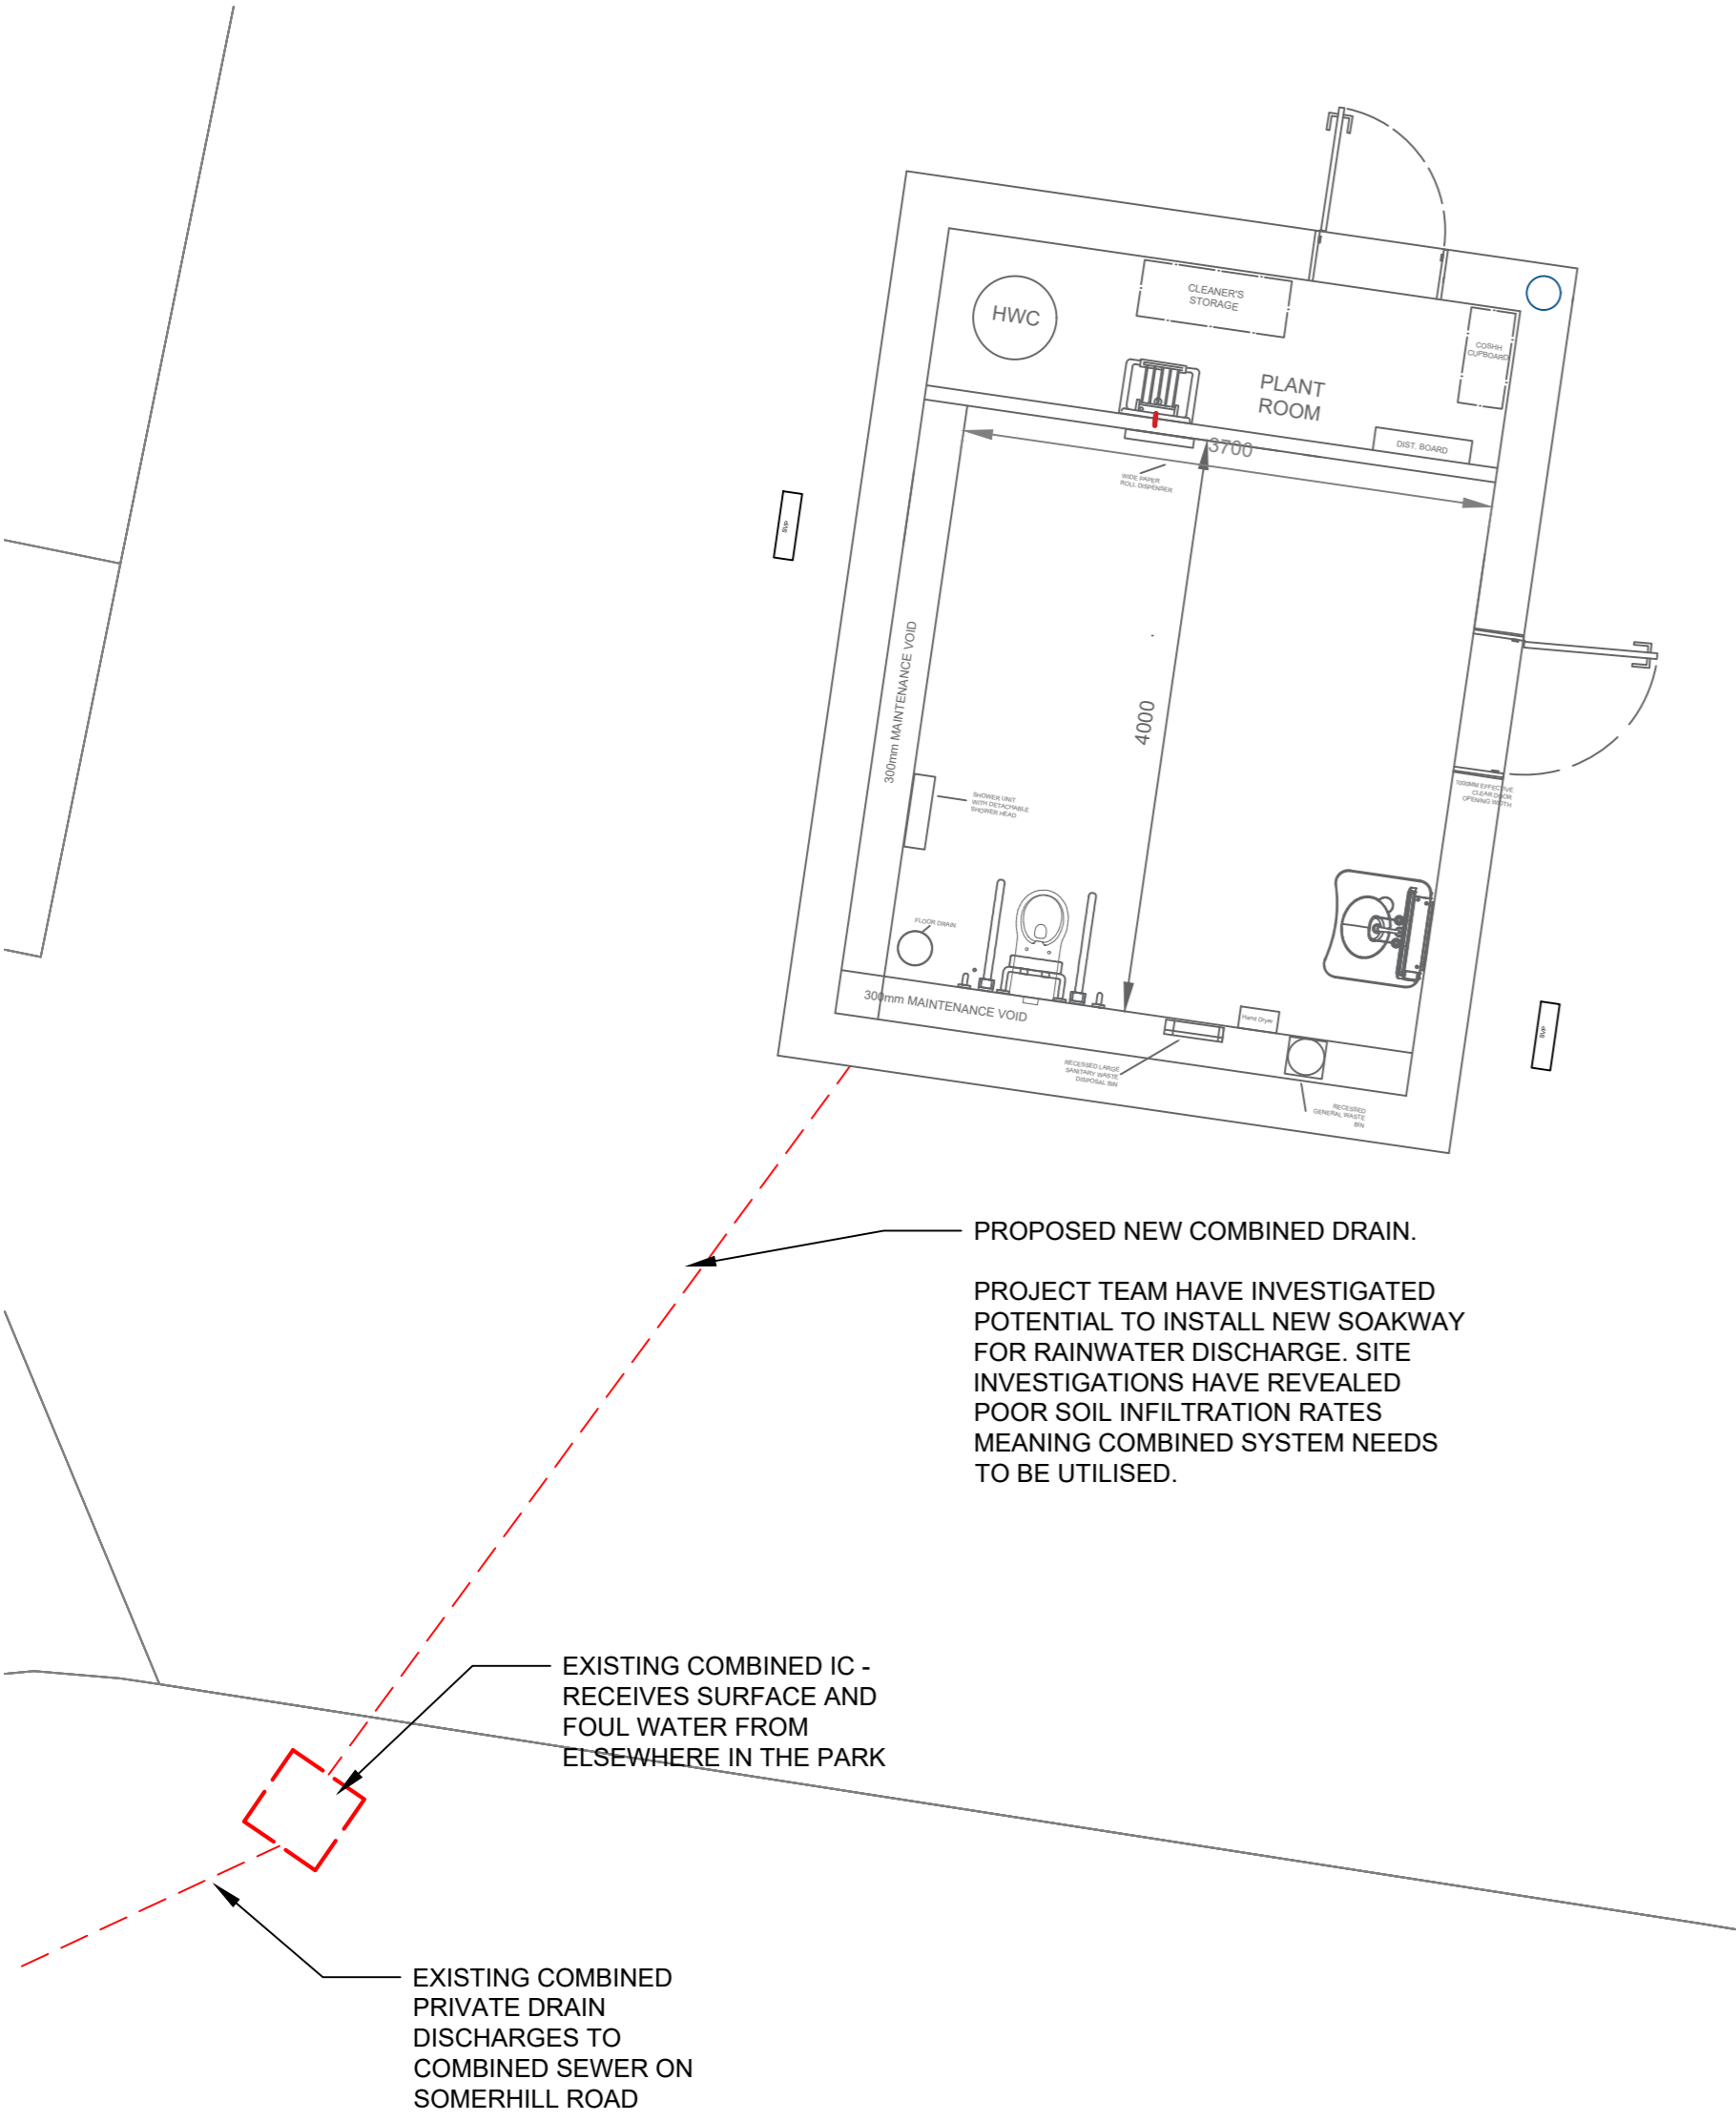

KEY

COMBINED PRIVATE DRAIN/SEWER	---
SOUTHERN WATER SEWER	—

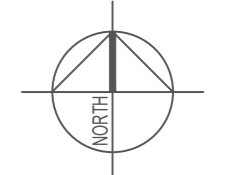

NORTH POINT

REV	DATE	DESCRIPTION
P2	11/12/23	ISSUED FOR PLANNING

Drawing Status
PLANNING



BRIGHTON & HOVE CITY COUNCIL
PROPERTY & DESIGN
HOVE TOWN HALL
HOVE, EAST SUSSEX, BN3 4AH
Telephone: (01273) 290000 Fax No. (01273) 291467

Project
**ST ANN'S WELL GARDEN
CHANGING PLACES WC BLOCK**

Title
PROPOSED DRAINAGE PLAN

Drawn By LC	Checked WD	Date DEC 2023
Project No. T113	Scale AS SHOWN AT A2	
Drawing No. 003	Revision P1	

This drawing should be read in conjunction with all other drawings. Do not scale. All Dimensions must be site checked. Copyright © Brighton & Hove City Council