


DRAINAGE LEGEND

- ADAPTABLE SURFACE WATER DRAINAGE
- ADAPTABLE FOUL WATER DRAINAGE
- PROPOSED WATER BUTT
- ROOFING EYE
- GEO-CELLULAR TANK 1 IN 100 YEAR EVENT WITH ACCESS POINTS WITH RAINGARDEN ABOVE
- PERFORATED PIPE LAD IN HERRINGBONE PATTERN WITHIN DRAINAGE BLANKET
- PROPOSED ROAD GULLY
- SUMP DRAIN WITH INLET PIPE
- PERMEABLE PAVING SYSTEM (INFILTRATION)
- PERMEABLE PAVING 80mm THICK (SERVICE CORRIDOR)
- SAB ADAPTABLE HIGHWAY
- PROPOSED PUBLIC OPEN SPACE

- GENERAL NOTES:**
1. ALL DIMENSIONS ARE IN MILLIMETRES UNLESS NOTED OTHERWISE.
 2. ALL LEVELS ARE SHOWN IN METRES UNLESS NOTED OTHERWISE.
 3. DO NOT SCALE FROM THE DRAWING. USE FIGURED DIMENSIONS ONLY.
 4. ANY DISCREPANCIES TO BE REPORTED IMMEDIATELY TO THE ENGINEER.
 5. THIS DRAWING TO BE READ IN CONJUNCTION WITH ALL RELEVANT ARCHITECTS, ENGINEERS, SUBCONTRACTORS AND SPECIALISTS DRAWINGS AND SPECIFICATIONS.
 6. EXISTING SERVICES HAVE NOT BEEN SHOWN BUT ARE PRESENT - THE CONTRACTOR IS TO LIAISE WITH ALL STATUTORY AUTHORITIES PRIOR TO THE COMMENCEMENT OF ANY WORKS.
 7. TEMPORARY WORKS DESIGN BY OTHERS.
 8. DESIGN RISK ASSESSMENTS AND METHOD STATEMENTS ARE TO BE PROVIDED TO THE PRINCIPLE CONTRACTOR PRIOR TO THE COMMENCEMENT OF ANY WORKS.

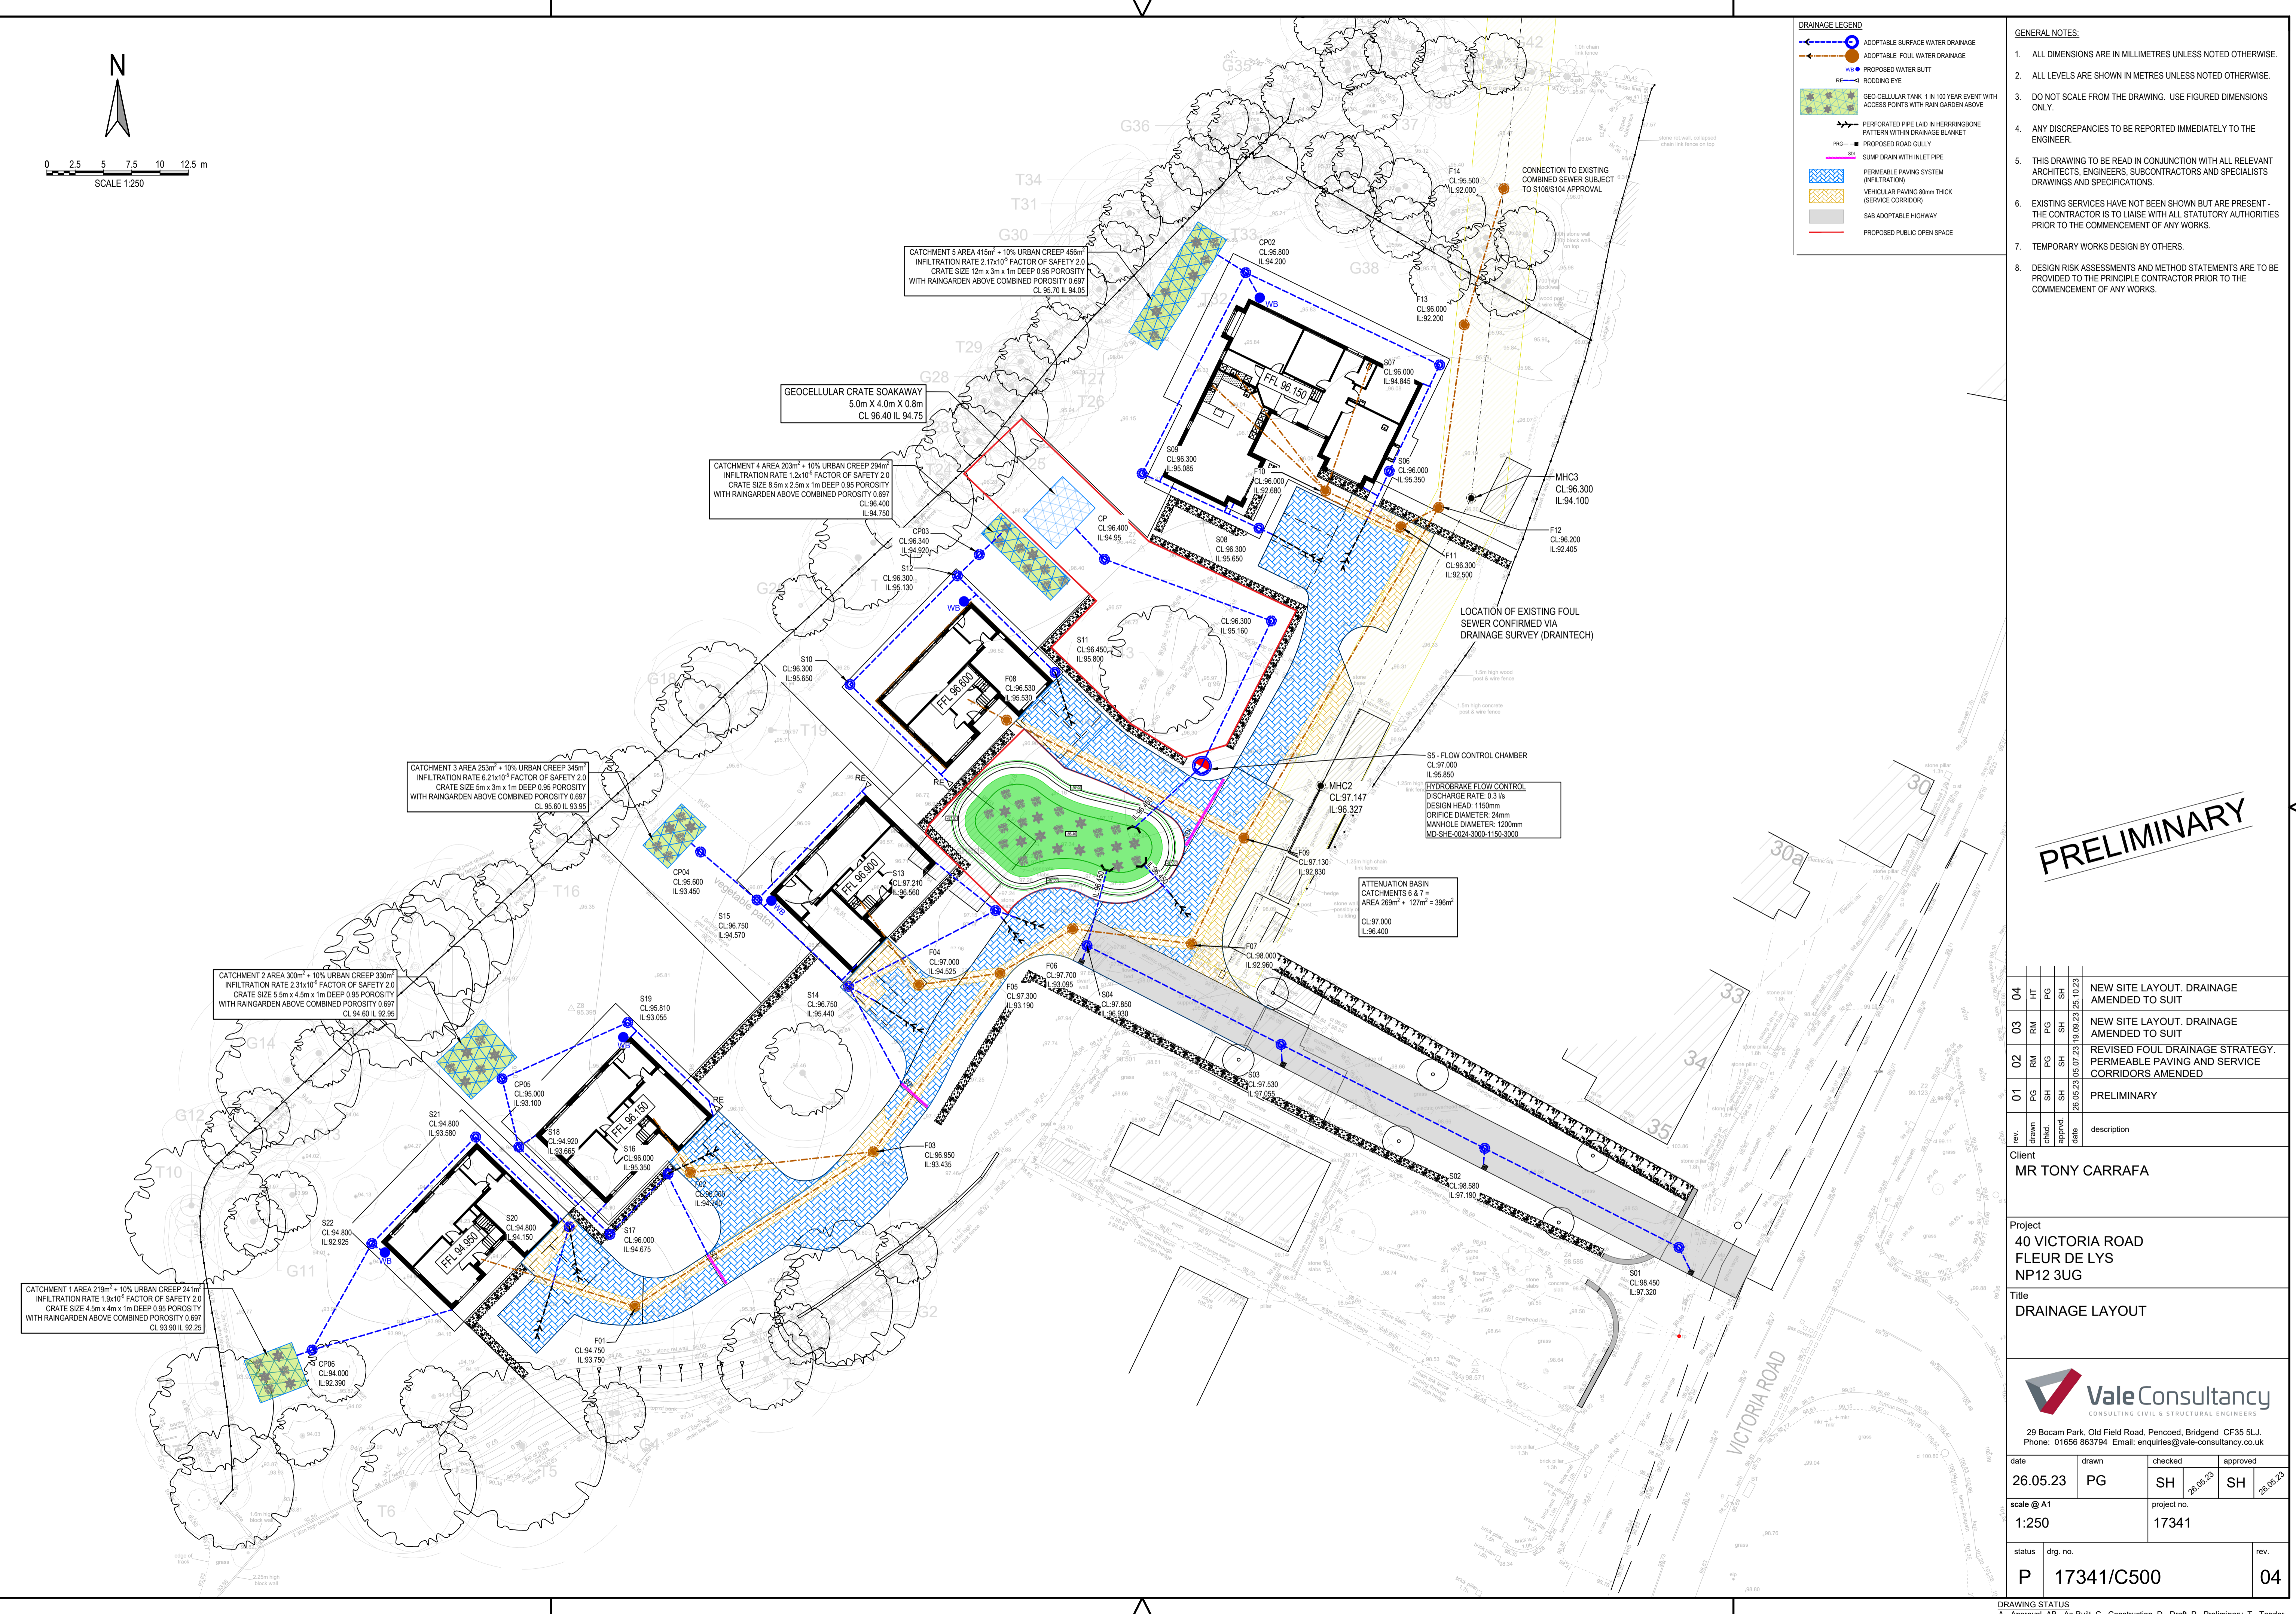

PRELIMINARY

rev.	drawn	chd.	appd.	date	description
04	HT	RM	PG	26.05.23	NEW SITE LAYOUT, DRAINAGE AMENDED TO SUIT
03	PG	RM	PG	25.10.23	NEW SITE LAYOUT, DRAINAGE AMENDED TO SUIT
02	SH	SH	SH	10.09.23	REVISED FOUL DRAINAGE STRATEGY, PERMEABLE PAVING AND SERVICE CORRIDORS AMENDED
01	SH	SH	SH	26.05.23	PRELIMINARY

Client
MR TONY CARRAFA

Project
**40 VICTORIA ROAD
FLEUR DE LYS
NP12 3UG**

Title
DRAINAGE LAYOUT



date	drawn	checked	approved
26.05.23	PG	SH	SH
scale @ A1 1:250		project no. 17341	
status	drw. no.	rev.	
P	17341/C500	04	

DRAWING STATUS
A - Approval, AB - As-Built, C - Construction, D - Draft, P - Preliminary, T - Tender

