 



# Site Plan for Heat Pump 46 Francis Avenue DA7 5BZ

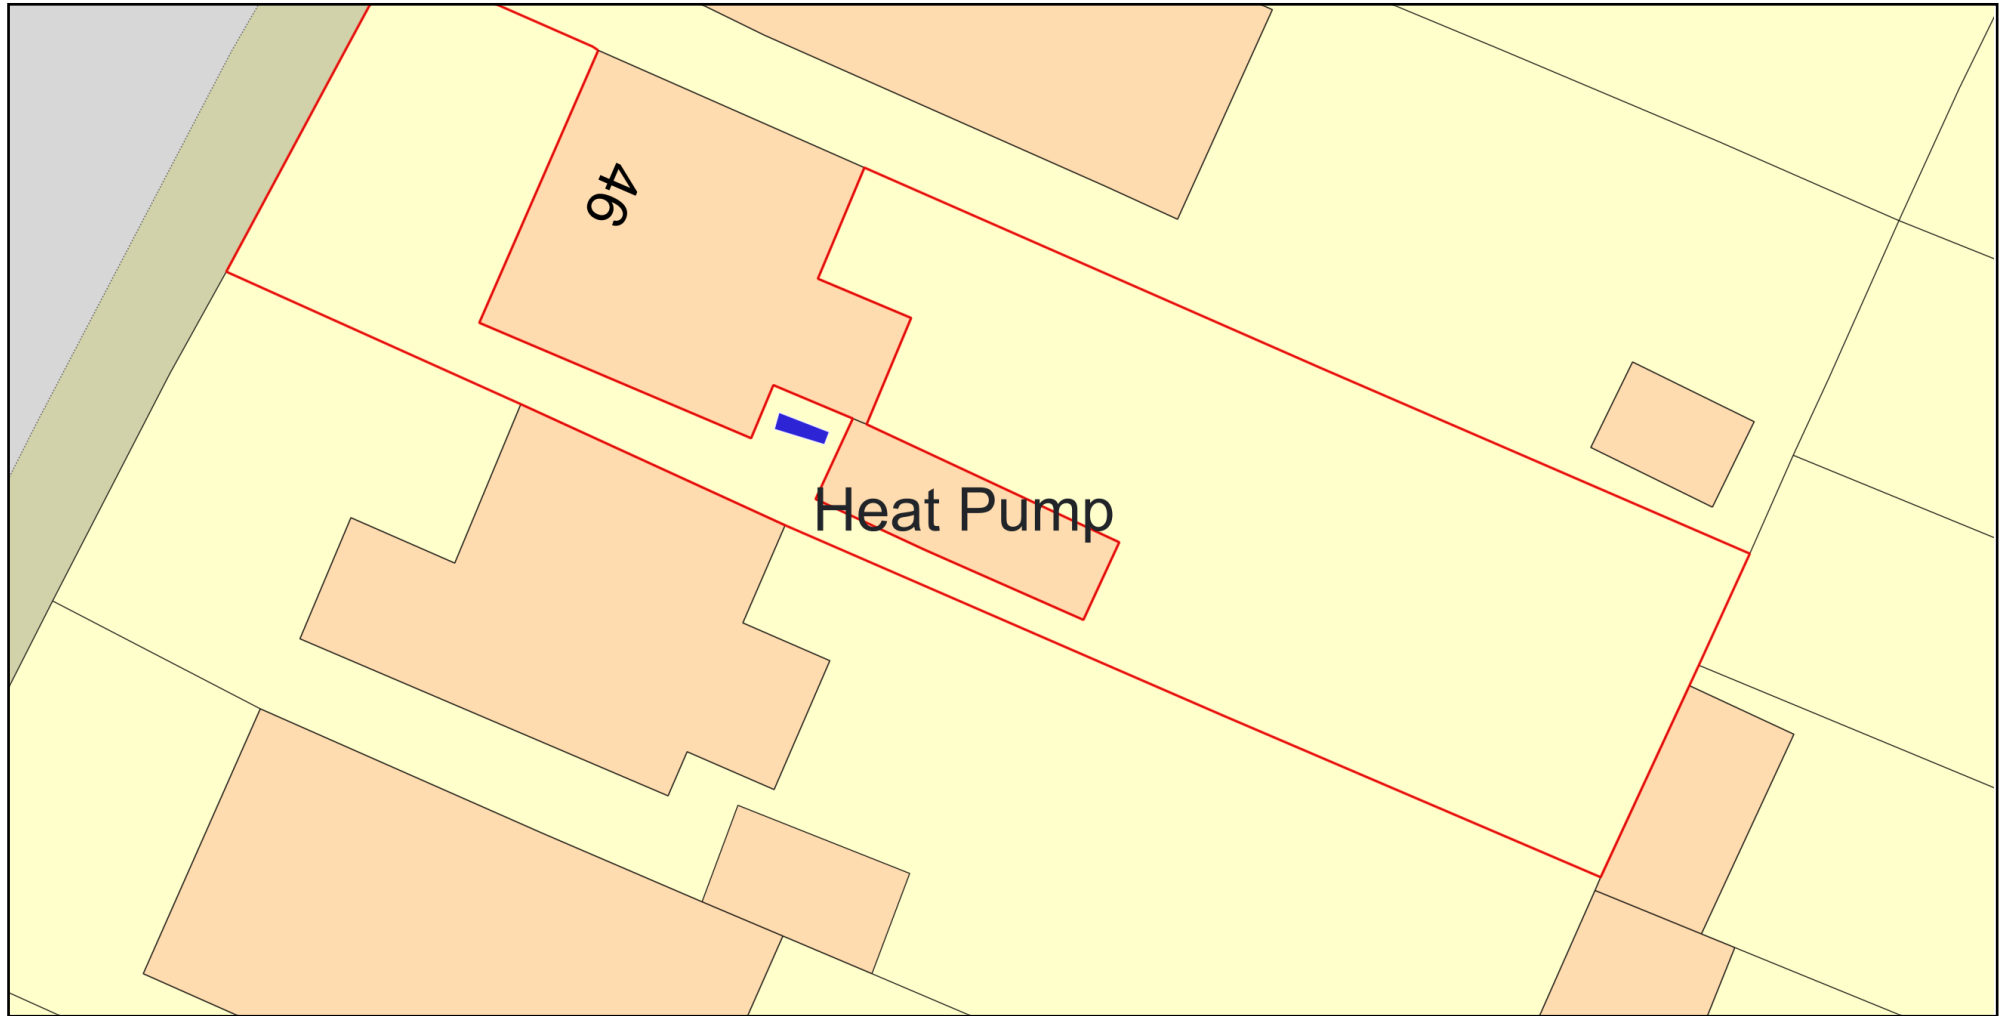

Plan Produced for: C Fell-Smith

Date Produced: 21 Dec 2023

Plan Reference Number: TQRQM23355121807953

Scale: 1:200 @ A4