


LEGEND

- △ SWITCHED SINGLE SOCKET
- △ SWITCHED DOUBLE SOCKET
- ⊠ SWITCHED DOUBLE SOCKET WITHIN FLOOR BOX
- FUSED SPUR
- 16a
32a SOCKET AMPS - 13a IF NOT SHOWN.
- 3- 3 PHASE - SINGLE PHASE IF NOT SHOWN
- HL HIGH LEVEL
- LL LOW LEVEL
- ML MID LEVEL
- BL BLENDED FACE PLATES TO MAIN ROOMS
- ⊠ SHAVER SOCKET
- ⊠ ISOLATOR
- △ DATA POINT
- ⊠ TV POINT
- ⊠ TELEPHONE POINT/CAT 6 - BT OR ETHERNET
- ⊠ SATELLITE
- ⊠ COMMANDO SOCKET
- ⊠ ACCESSIBLE WC OVER DOOR BEACON/SOUNDER
- ⊠ THERMOSTAT
- ⊠ CAT 6 CONNECTION POINT
- ⊠ DISTRIBUTION BOARD
- ⊠ ISOLATOR SWITCH TO EXTRACT FAN (HIGH LEVEL)
- ⊠ RADIATOR (E = Electric Radiator)
- ⊠ Towel Rad TOWEL RADIATOR

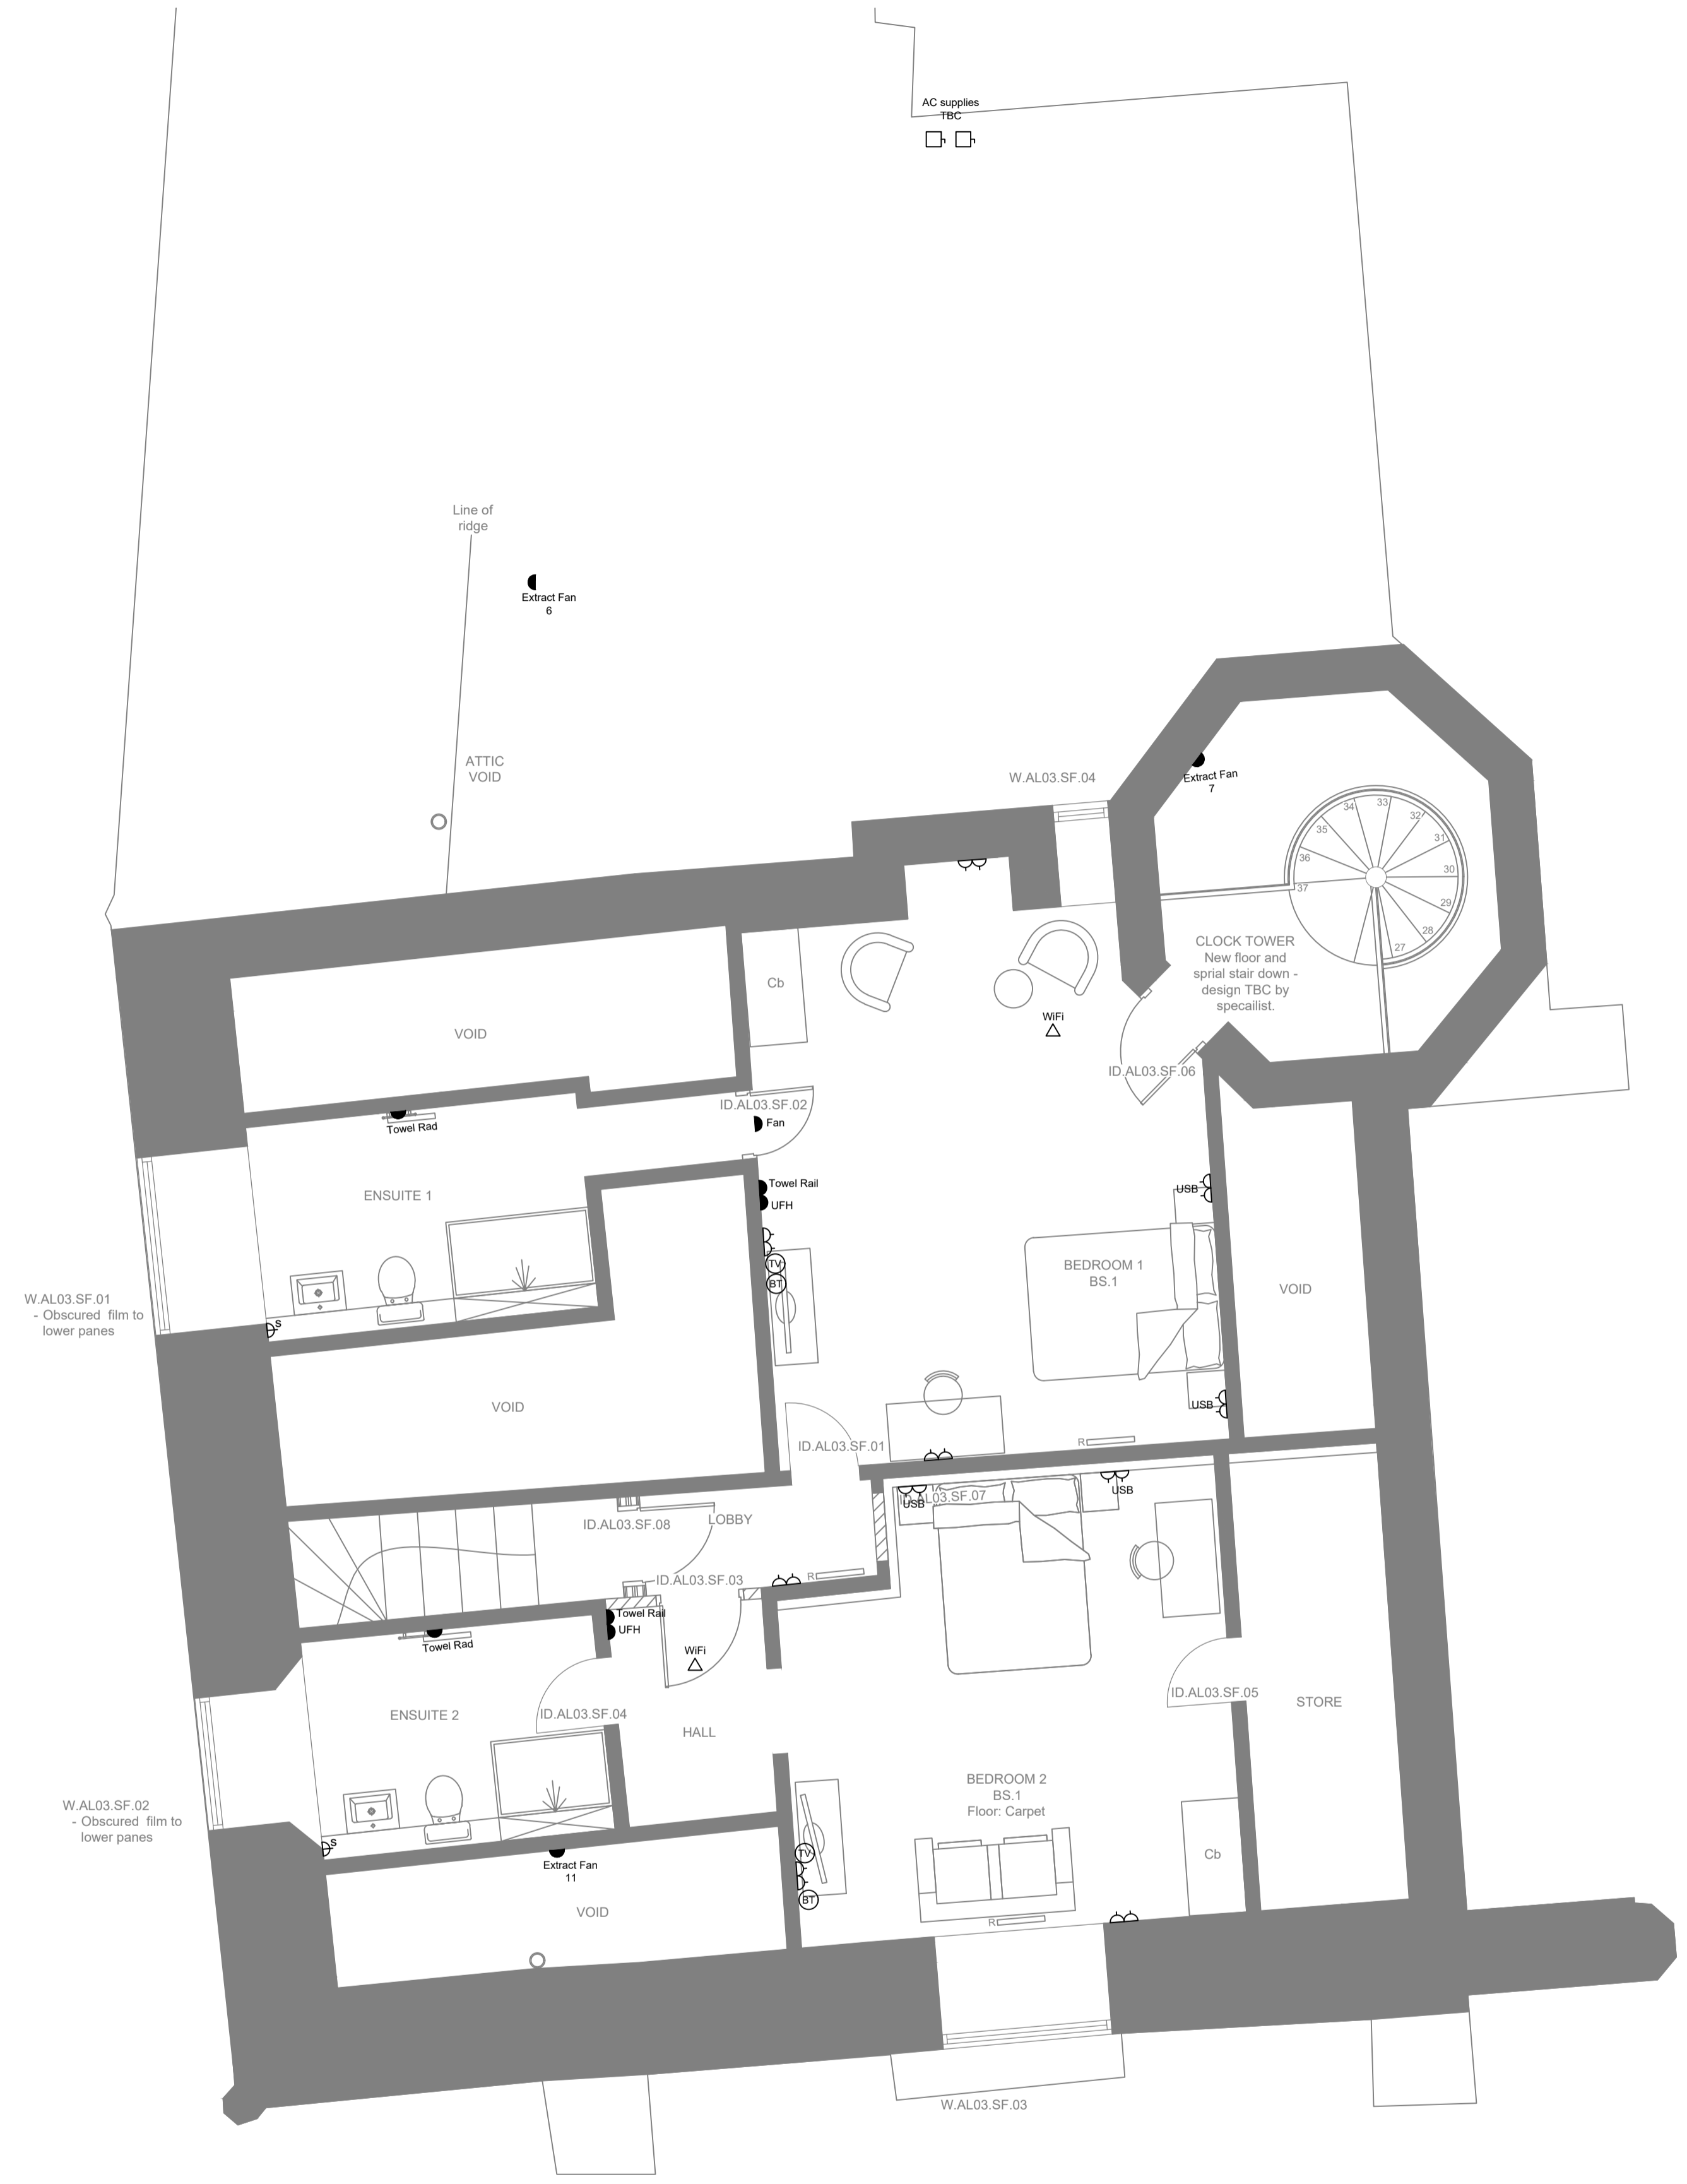

- Notes:**
1. Do not scale from this drawing, use figured dimensions only.
 2. All dimensions to be verified on site.
 3. This drawing is to be read in conjunction with all related architects and engineers drawings and any other related information.
 4. Security supplies to be confirmed.
 5. Mechanical supplies to be confirmed.

--	--

A Initial drawing issue	J.H. 22/06/23
Rev	Description

Drawing Status: **FOR APPROVAL**



Laser Electrical Services Limited
 11 Springfield Lyons Approach
 Chelmsford
 Essex CM2 5LB

T: 01245 398380
 F: 01245 809496
 E: info@laserelectrical.com
 W: www.laserelectrical.com

Client:
City & Country
Bentfield Place, Bentfield Road
Stansted, Essex CM24 8HL

Project:
Darcy House
St. Osyth's Priory, The Bury
St. Osyth, Essex CO16 8HS

Drawing Title:
Electrical Services
Phase 3 Second Floor
Small Power Layout

Scale:	Date:	Drawn:	Checked:
1:50@A1	06/2023	J.H.	R.F.

Drawing Number:	Revision:
L4384R/E/205	A