



**LEGEND**

- ⚡ 1 WAY SWITCH
- ⚡ 2 WAY SWITCH
- ⚡ 3 WAY SWITCH
- ⚡ 2 WAY 2 GANG SWITCH
- ◻ DIMMER SWITCH
- ⊕ CEILING MOUNTED PENDANT LIGHT (CLIENT SUPPLIED)
- ⊕ CEILING MOUNTED BULKHEAD LIGHT
- ⊕ WALL MOUNTED LIGHT (CLIENT SUPPLIED)
- ⊙ SPOT LIGHT
- NON-CORROSIVE LIGHT
- EMC WALL MOUNTED EMERGENCY BULKHEAD
- EXIT EMERGENCY EXIT LIGHT
- ⊙ EMERGENCY PIN SPOT
- ⊙ PIR DETECTOR
- LAMP (CLIENT SUPPLIED)

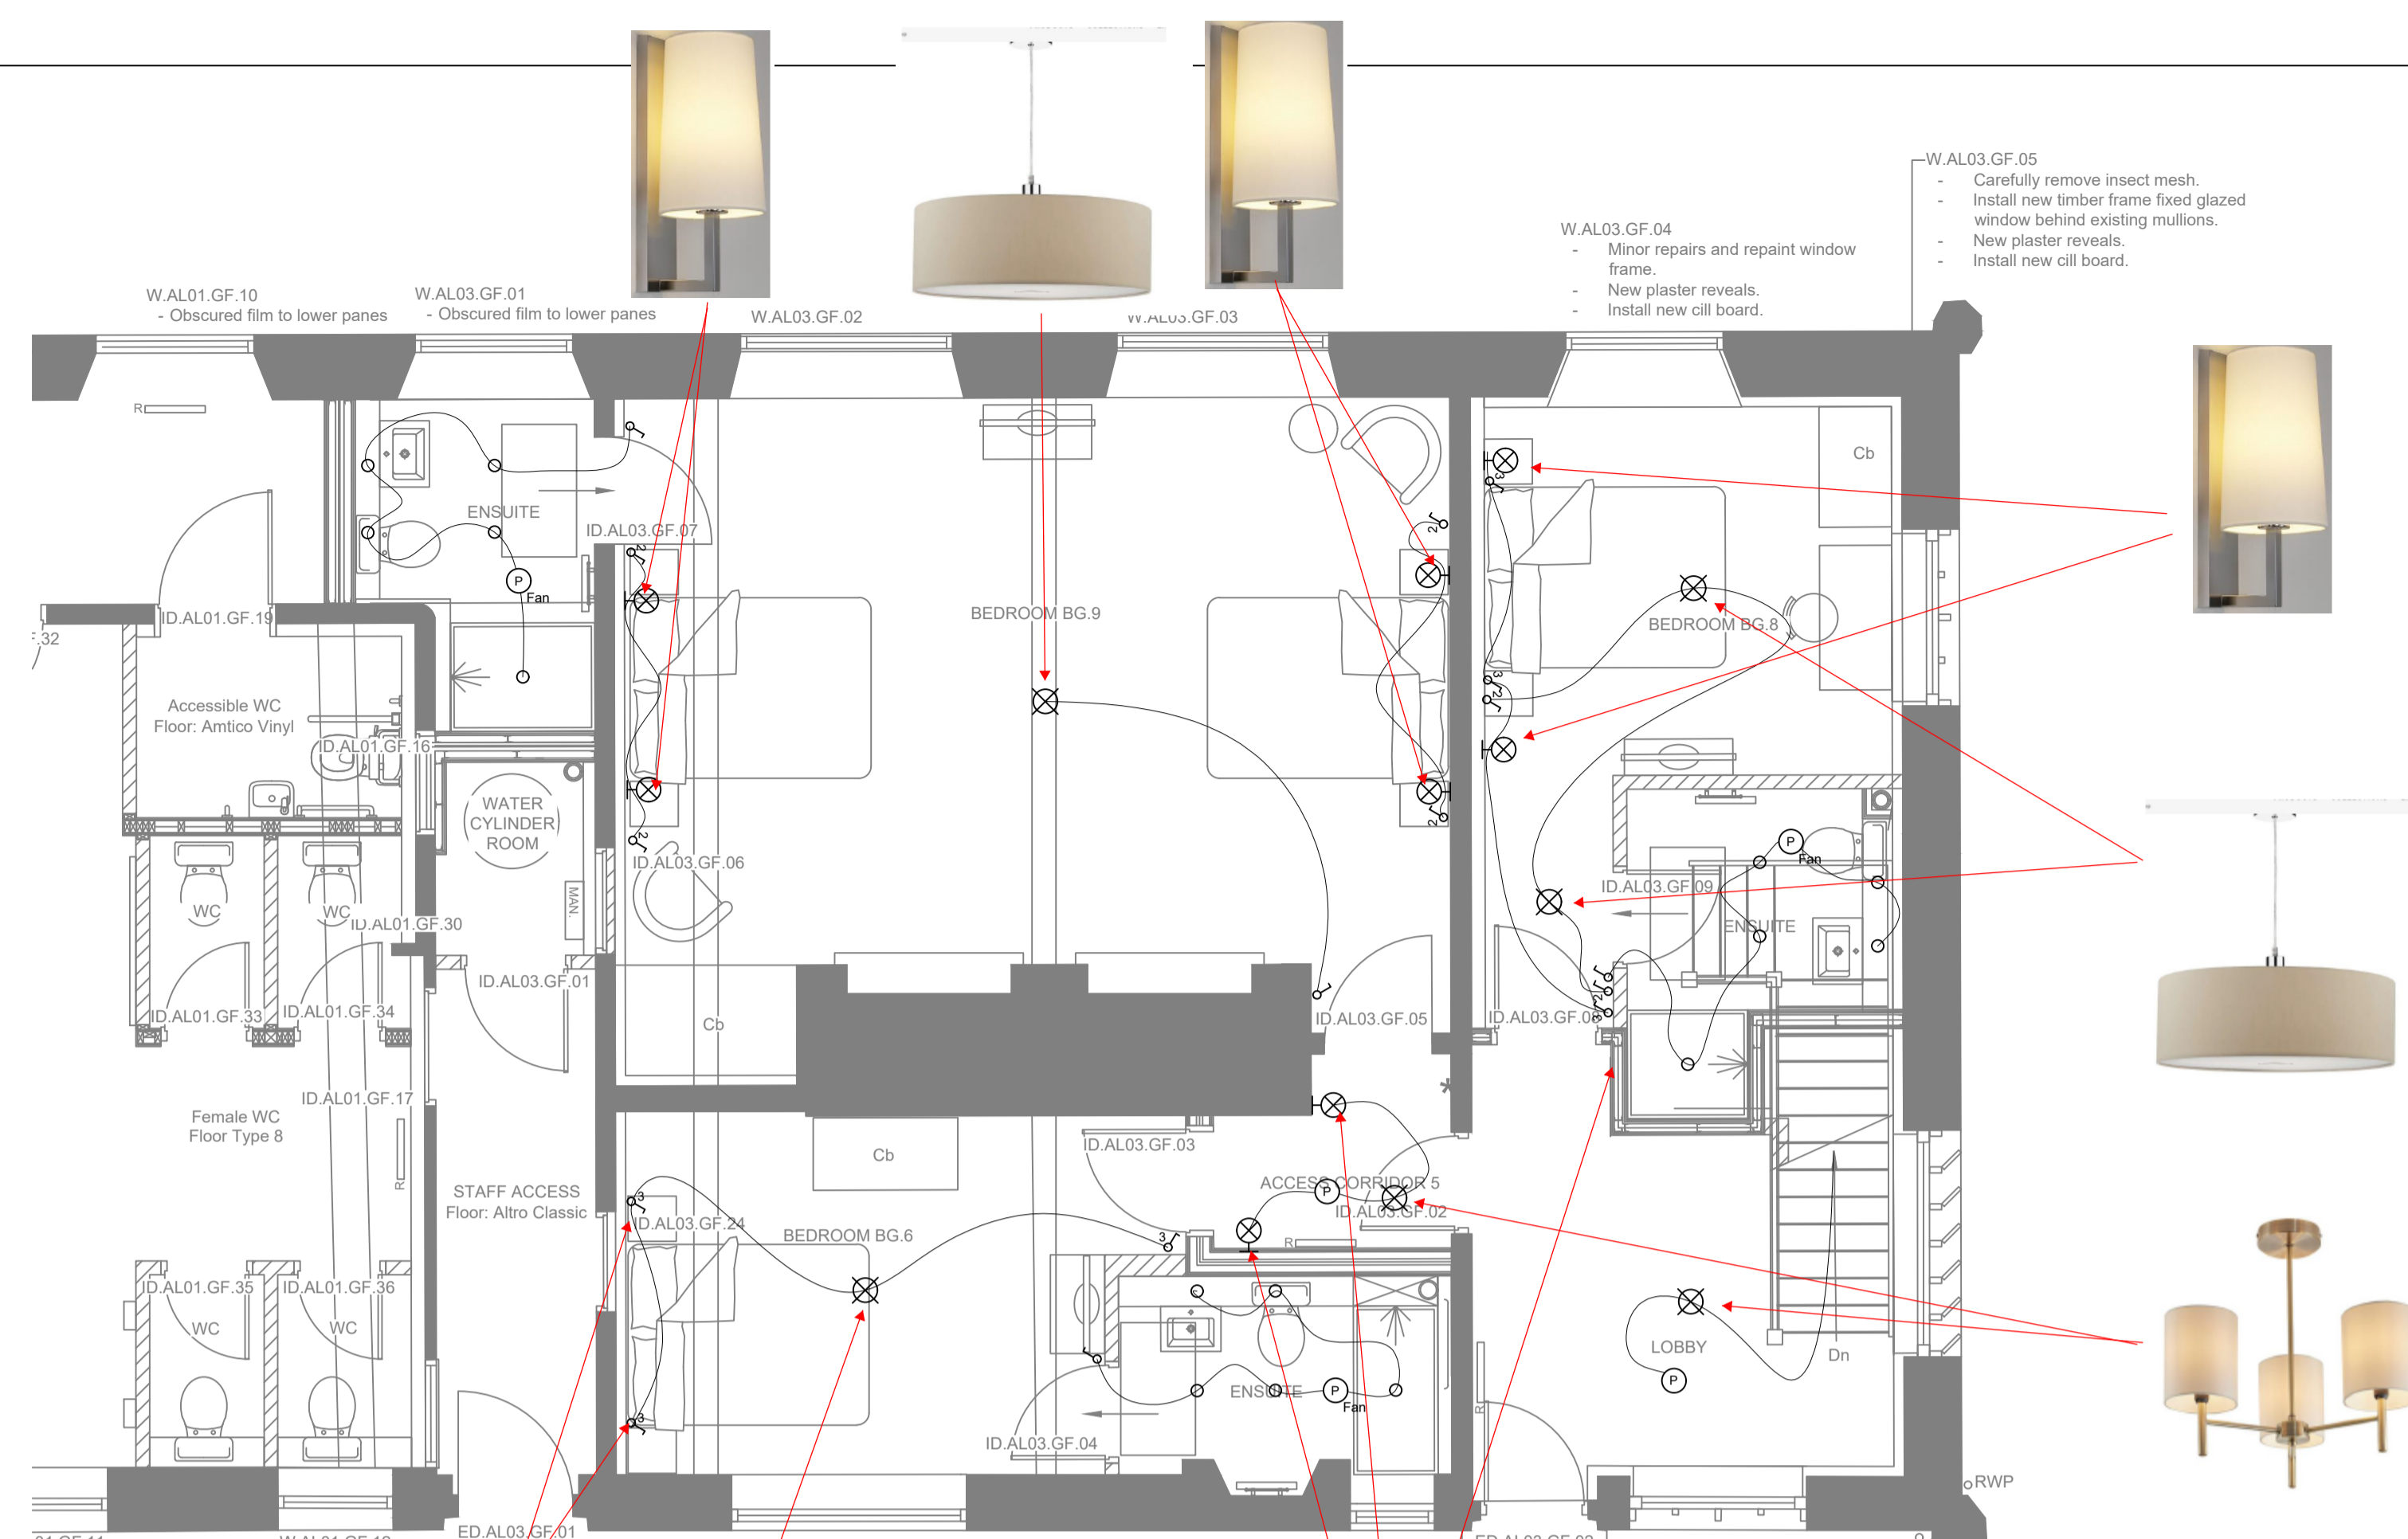

**GROUND FLOOR**  
(1:50@A1)

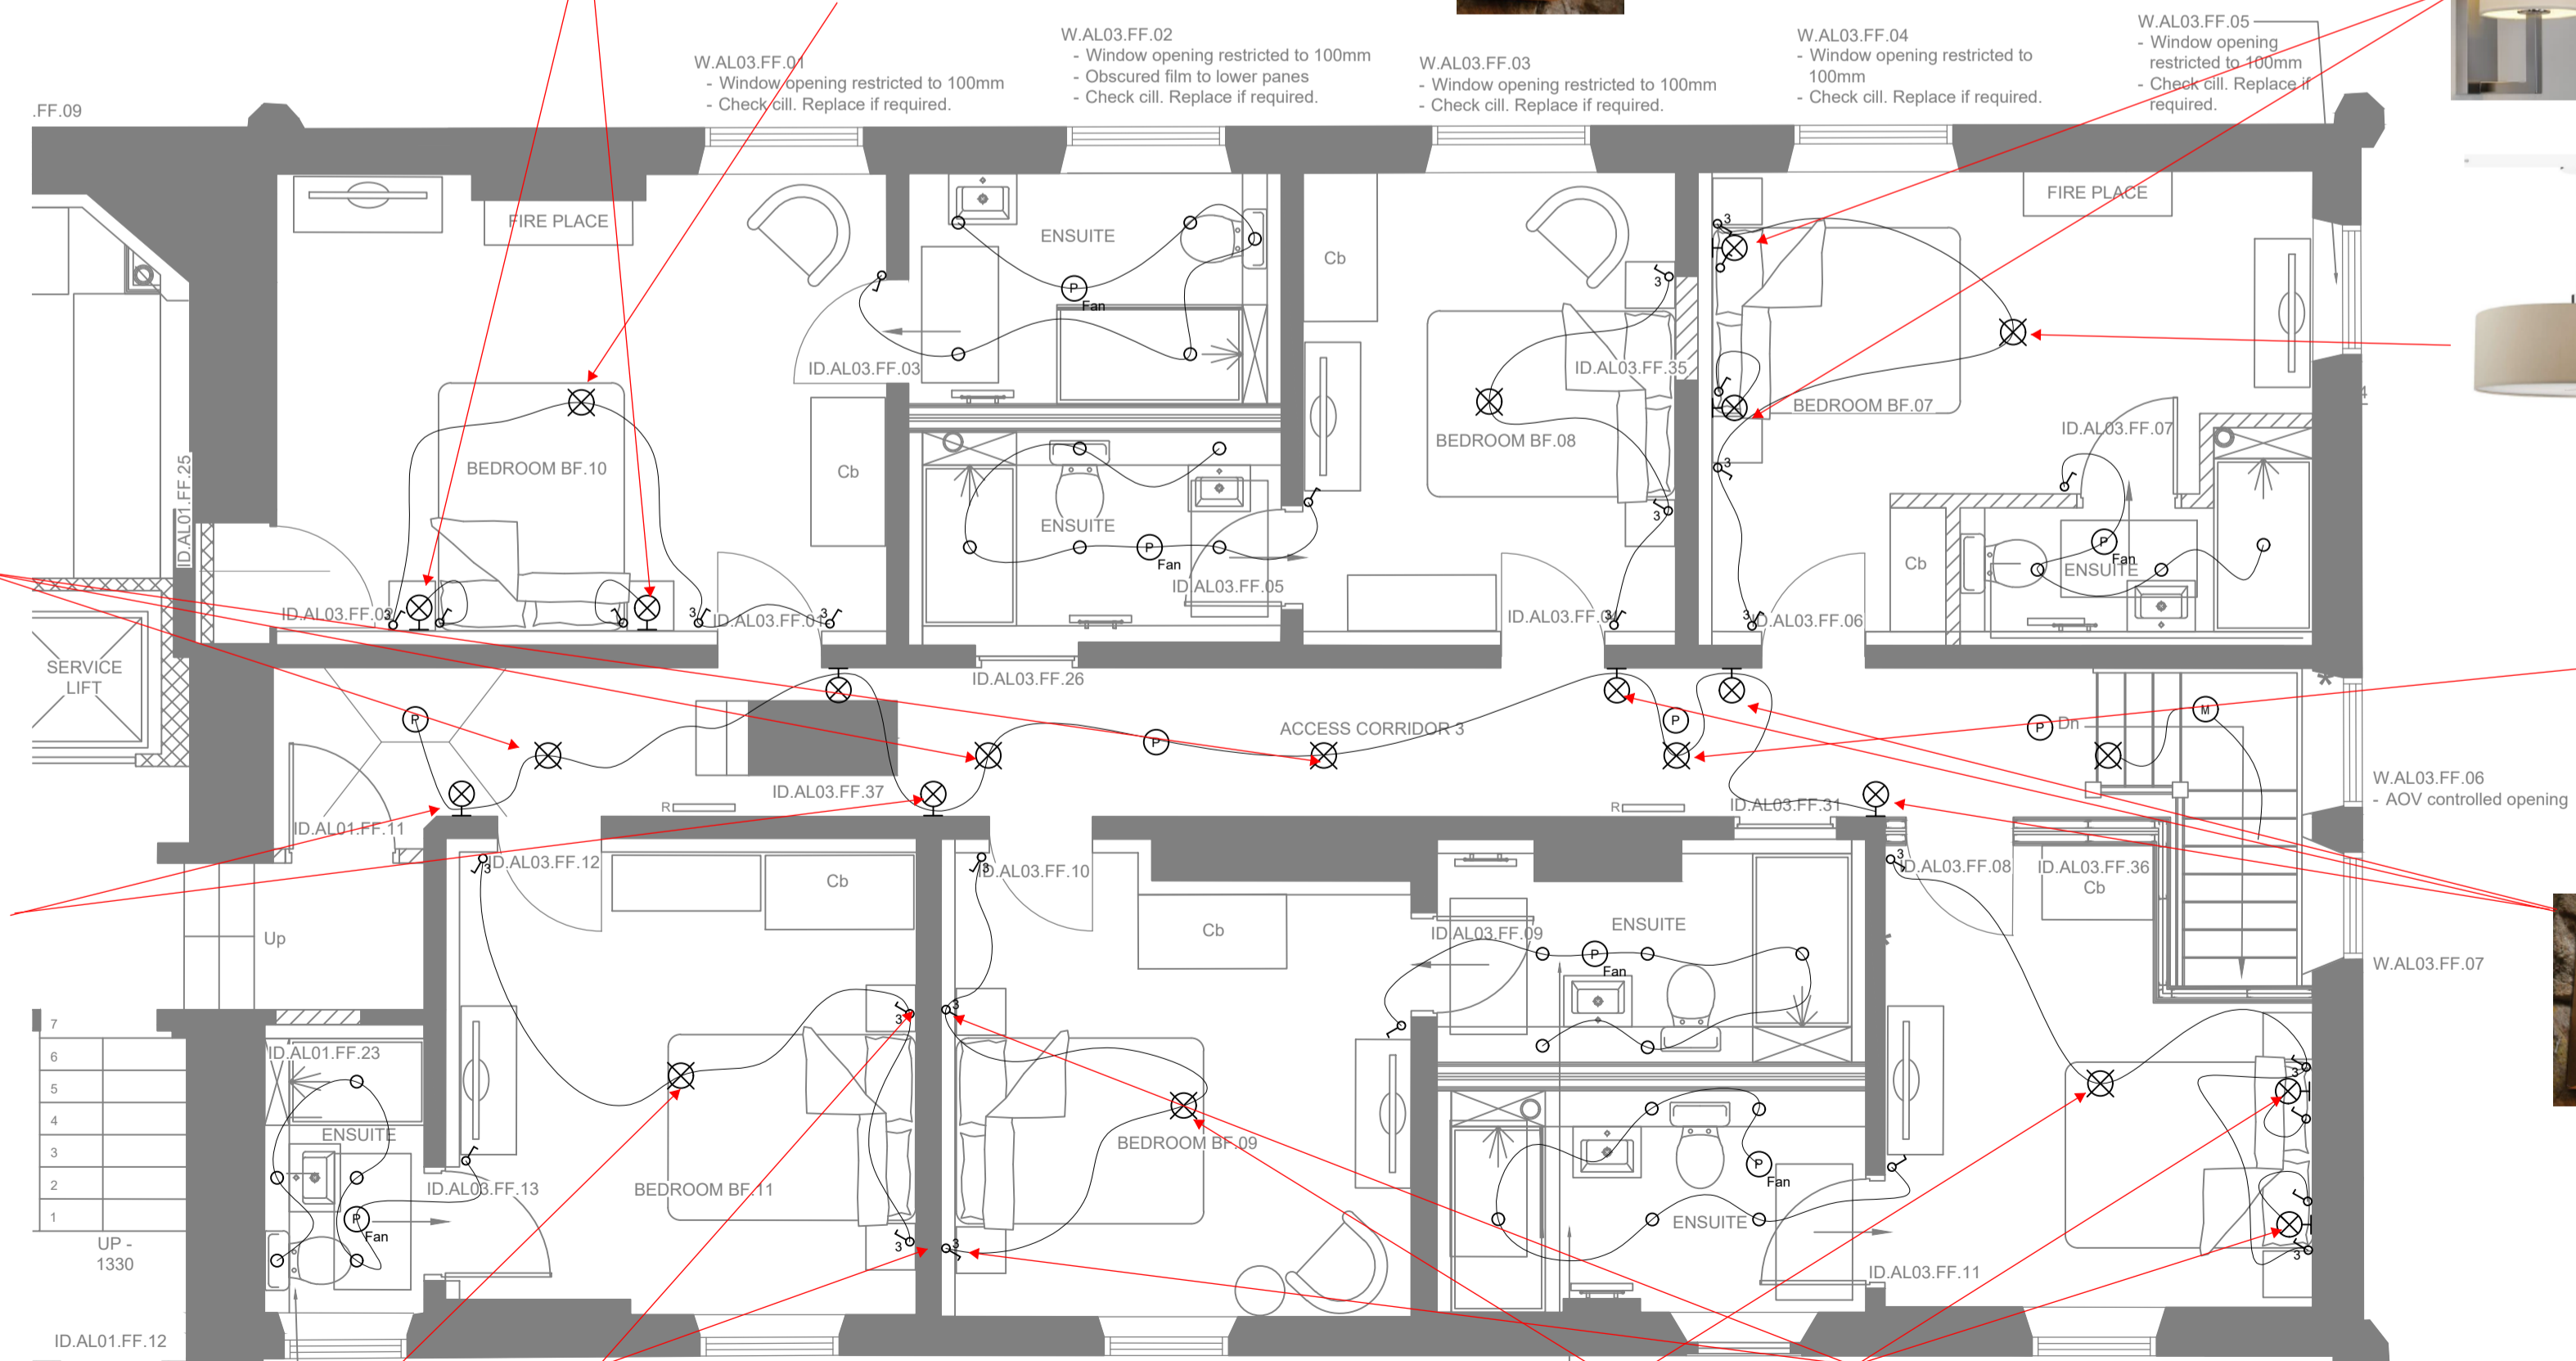

**FIRST FLOOR**  
(1:50@A1)

- Notes:**
1. Do not scale from this drawing, use figured dimensions only.
  2. All dimensions to be verified on site.
  3. This drawing is to be read in conjunction with all related architects and engineers drawings and any other related information.

Rev	Description	Drawn	Date
A	Initial drawing issue	J.H.	22/06/23

Drawing Status:  
**FOR APPROVAL**



Laser Electrical Services Limited  
11 Springfield Lyons Approach  
Chelmsford  
Essex CM2 5LB  
T: 01245 398380  
F: 01245 809496  
E: info@laserelectrical.com  
W: www.laserelectrical.com

Client:  
**City & Country**  
Bentfield Place, Bentfield Road  
Stansted, Essex CM24 8HL

Project:  
**Darcy House**  
St. Osyth's Priory, The Bury  
St. Osyth, Essex CO16 8HS

Drawing Title:  
**Electrical Services**  
Phase 3 East Wing  
Lighting Layout

Scale:	Date:	Drawn:	Checked:
1:50@A1	06/2023	J.H.	R.F.

Drawing Number:	Revision:
<b>L3484R/E/103</b>	<b>A</b>