


 

 

 


 





LEGEND

-  FIRE ALARM PANEL
-  SMOKE ALARM
-  SMOKE ALARM WITH SOUNDER
-  SMOKE ALARM WITH SOUNDER AND BEACON
-  HEAT ALARM
-  MANUAL CALL POINT
-  ALARM KEY PAD
-  DOOR ENTRY KEYPAD PANEL
ST = Staff entry PU = Public (guest) entry
-  FOB READER
-  REQUEST TO EXIT BUTTON
-  EMERGENCY BREAK GLASS
-  PIR MOTION SENSOR
-  CCTV CAMERA



Notes:

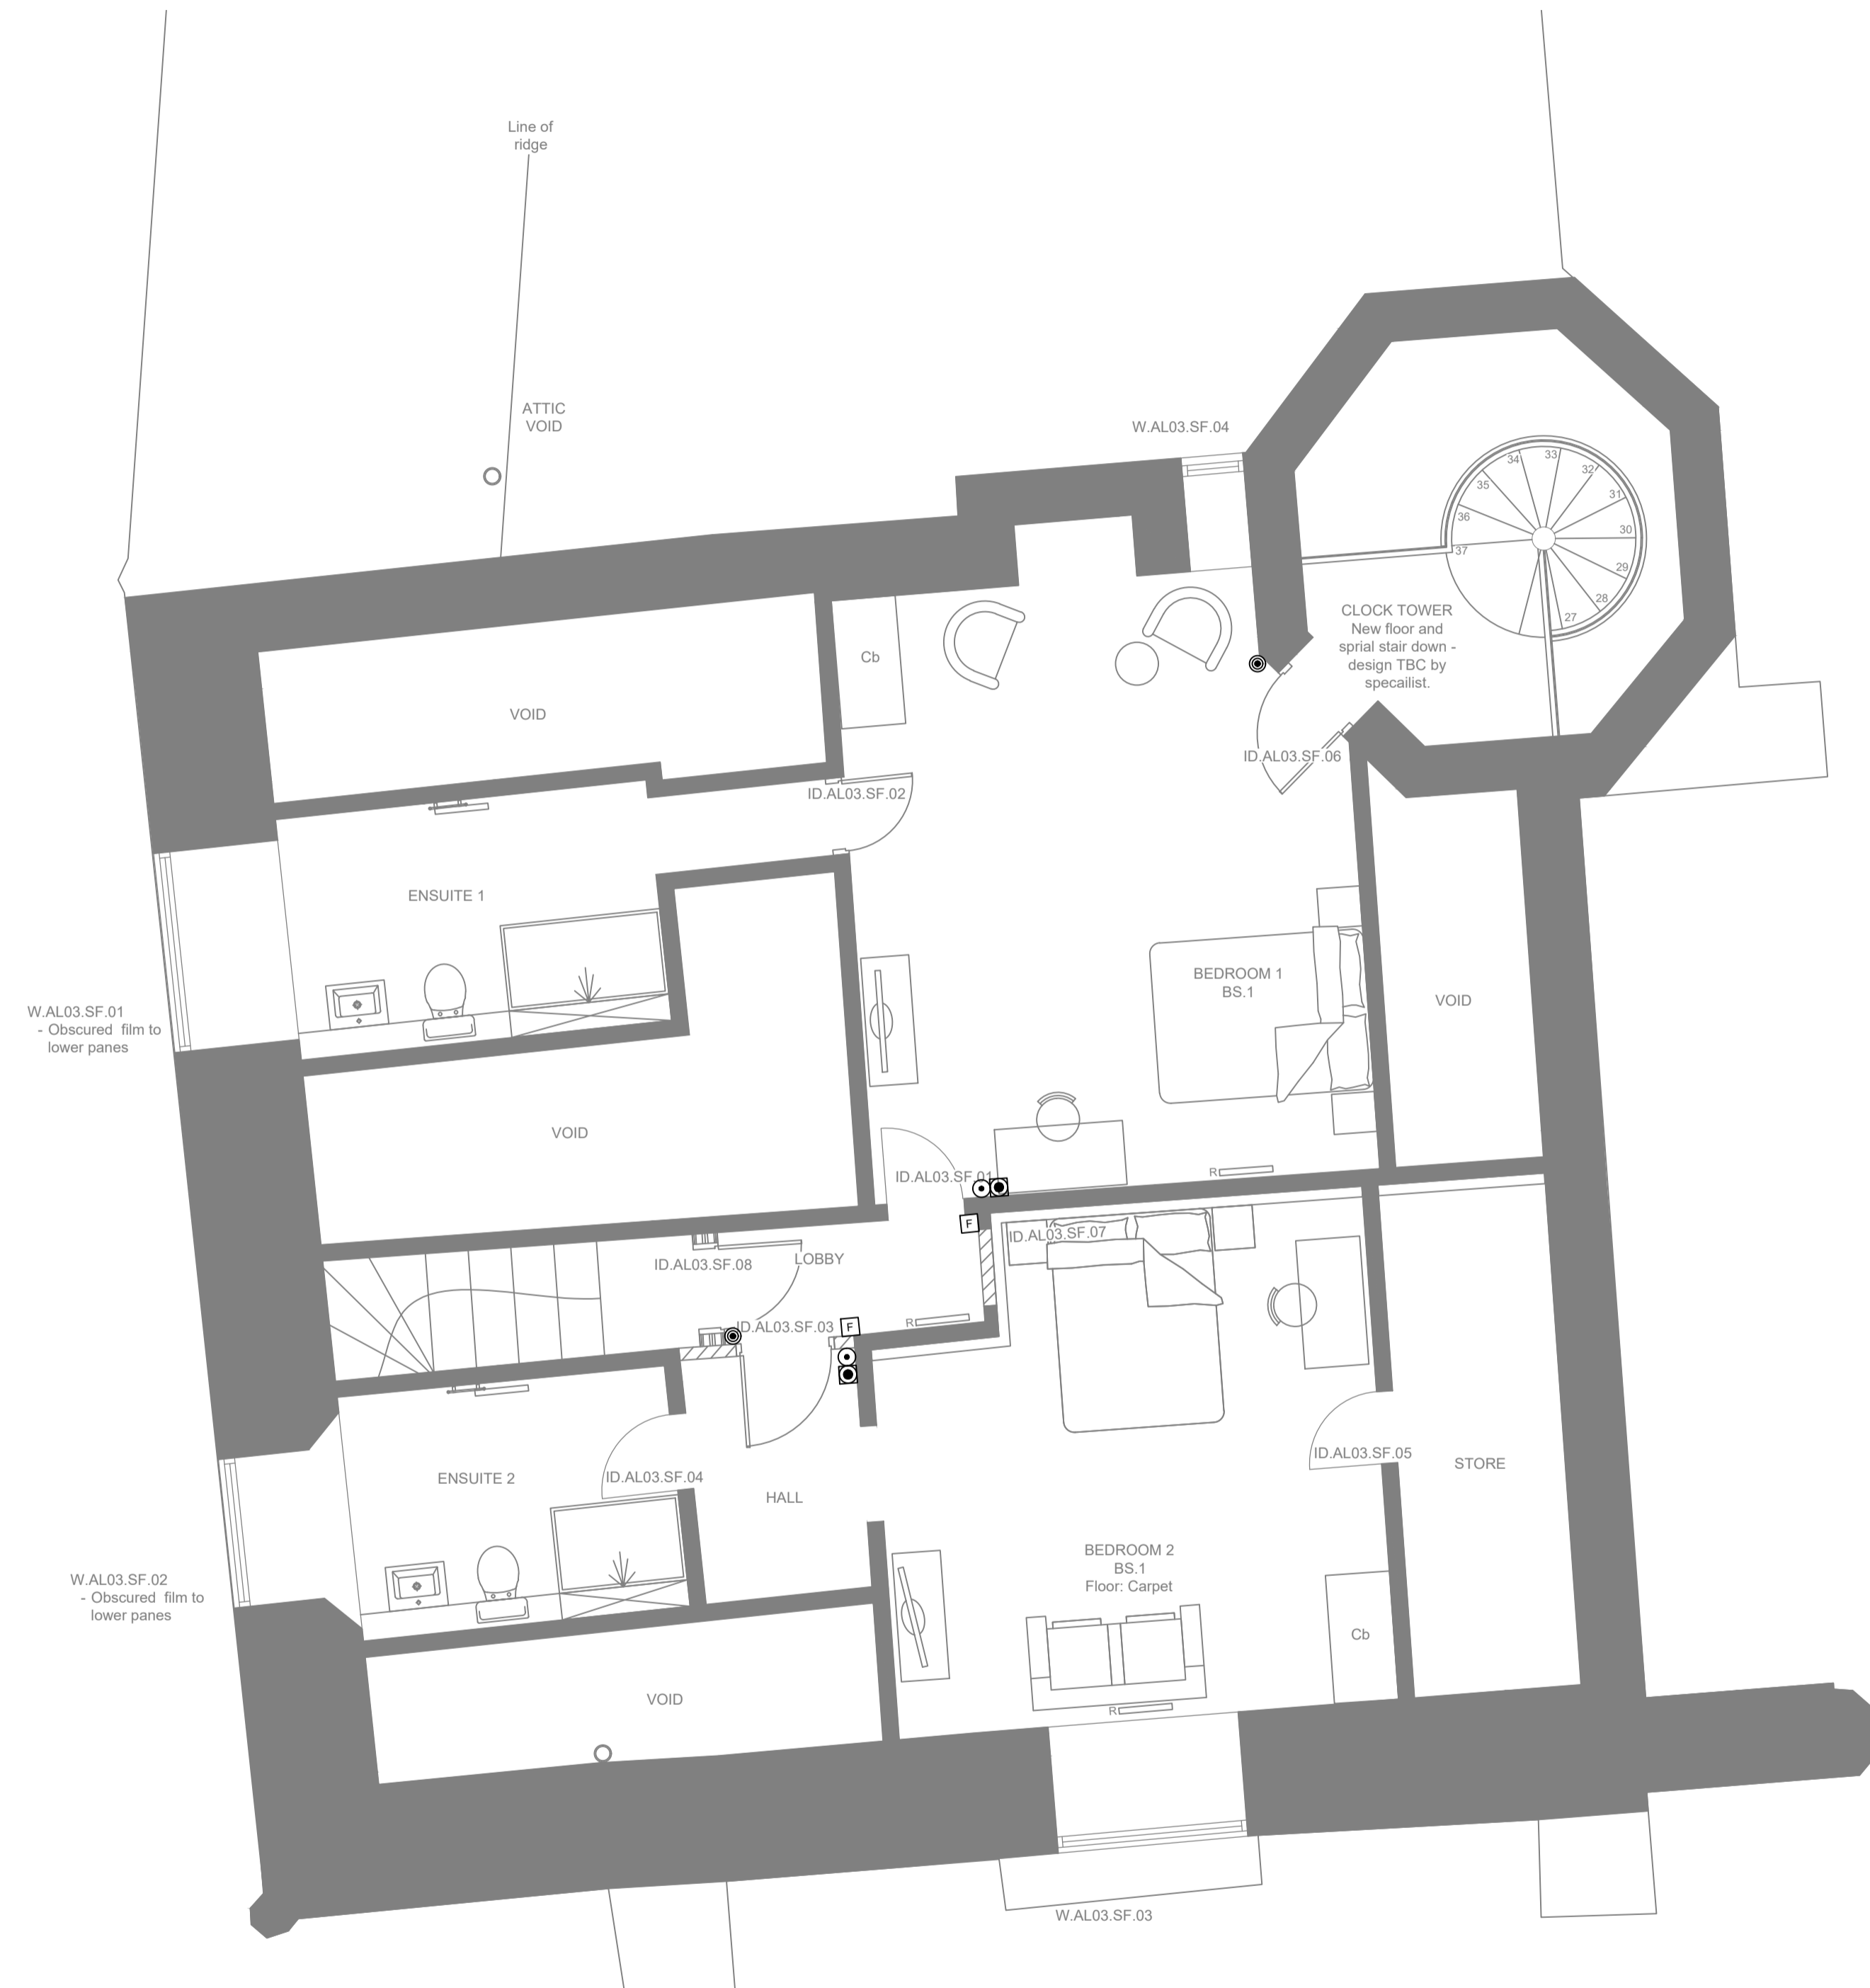1. Do not scale from this drawing, use figured dimensions only.
2. All dimensions to be verified on site.
3. This drawing is to be read in conjunction with all related architects and engineers drawings and any other related information.

A	Initial drawing issue	J.H.	22/06/23
---	-----------------------	------	----------

Rev	Description	Drawn	Date
-----	-------------	-------	------

Drawing Status:
FOR APPROVAL



Laser Electrical Services Limited
 11 Springfield Lyons Approach
 Chelmsford
 Essex CM2 5LB
 T: 01245 398380
 F: 01245 809496
 E: info@laserelectrical.com
 W: www.laserelectrical.com

Client:
**City & Country
Bentfield Place, Bentfield Road
Stansted, Essex CM24 8HL**

Project:
**Darcy House
St. Osyth's Priory, The Bury
St. Osyth, Essex CO16 8HS**

Drawing Title:
**Electrical Services
Phase 3 Second Floor
Fire Alarm and Security Layout**

Scale:	Date:	Drawn:	Checked:
1:50@A1	06/2023	J.H.	R.F.

Drawing Number:	Revision:
L4384R/E/305	B