


Total Internal Flat Floor Area : 58m²

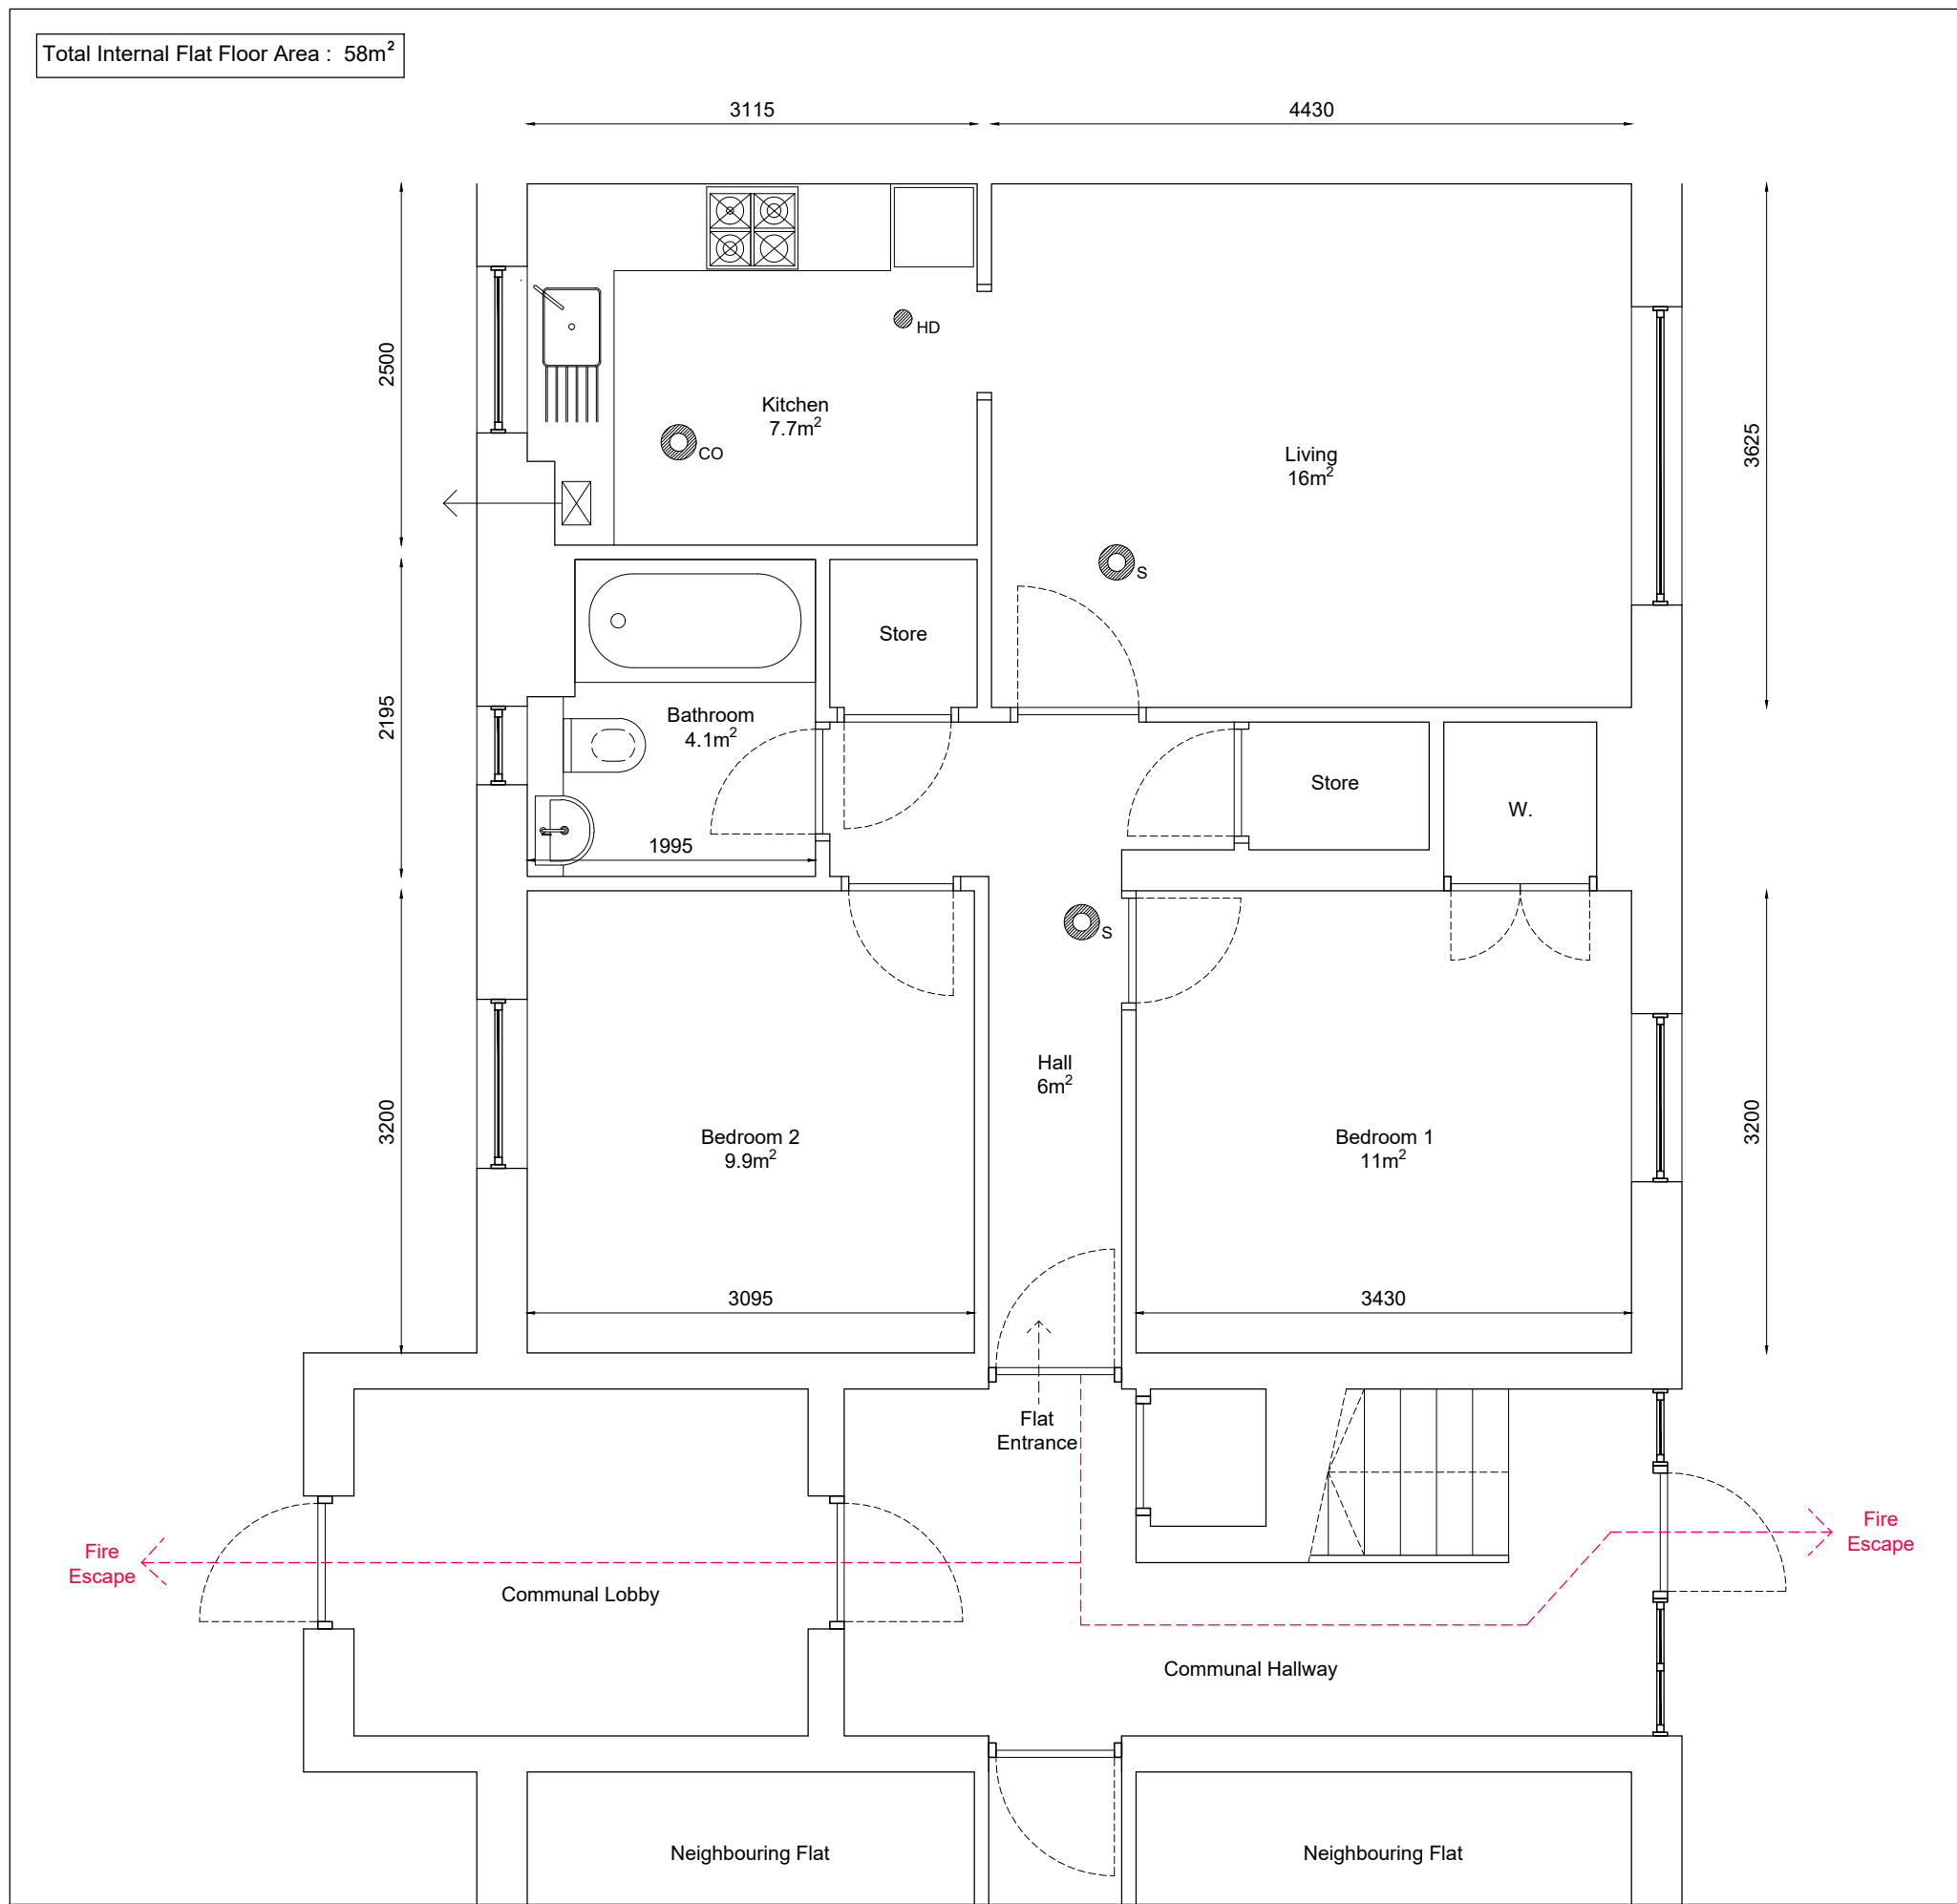

Electrical Legend:

- Interlinked Smoke Detector Alarm
- Carbon Monoxide Detector Alarm
- Heat Detector Alarm

Notes:
Do not scale from this drawing.
This drawing is solely for graphical purposes.
All sizes measured in millimetres.

REV.	REVISION NOTES:	DATE	ISSUED

Client
Mrs. Stevenson
Flat 2, 702 Edgefauld Road,
Springburn,
G21 4NB.

Drawing Existing Ground Floor Plan | **Scale** 1:50 @ A3

Drawing Date	Drawing No.	Revision No.
Dec. 23	23 - 042 - Ext 01	

Existing Ground Floor Plan @ 1:50