


NOTE: ORIGINAL DRAWING SIZE A3

NOTES

1. This drawing to be read in conjunction with SUF021 Series drawings and standard Airwave drawings.
2. All dimensions are in mm unless otherwise stated.

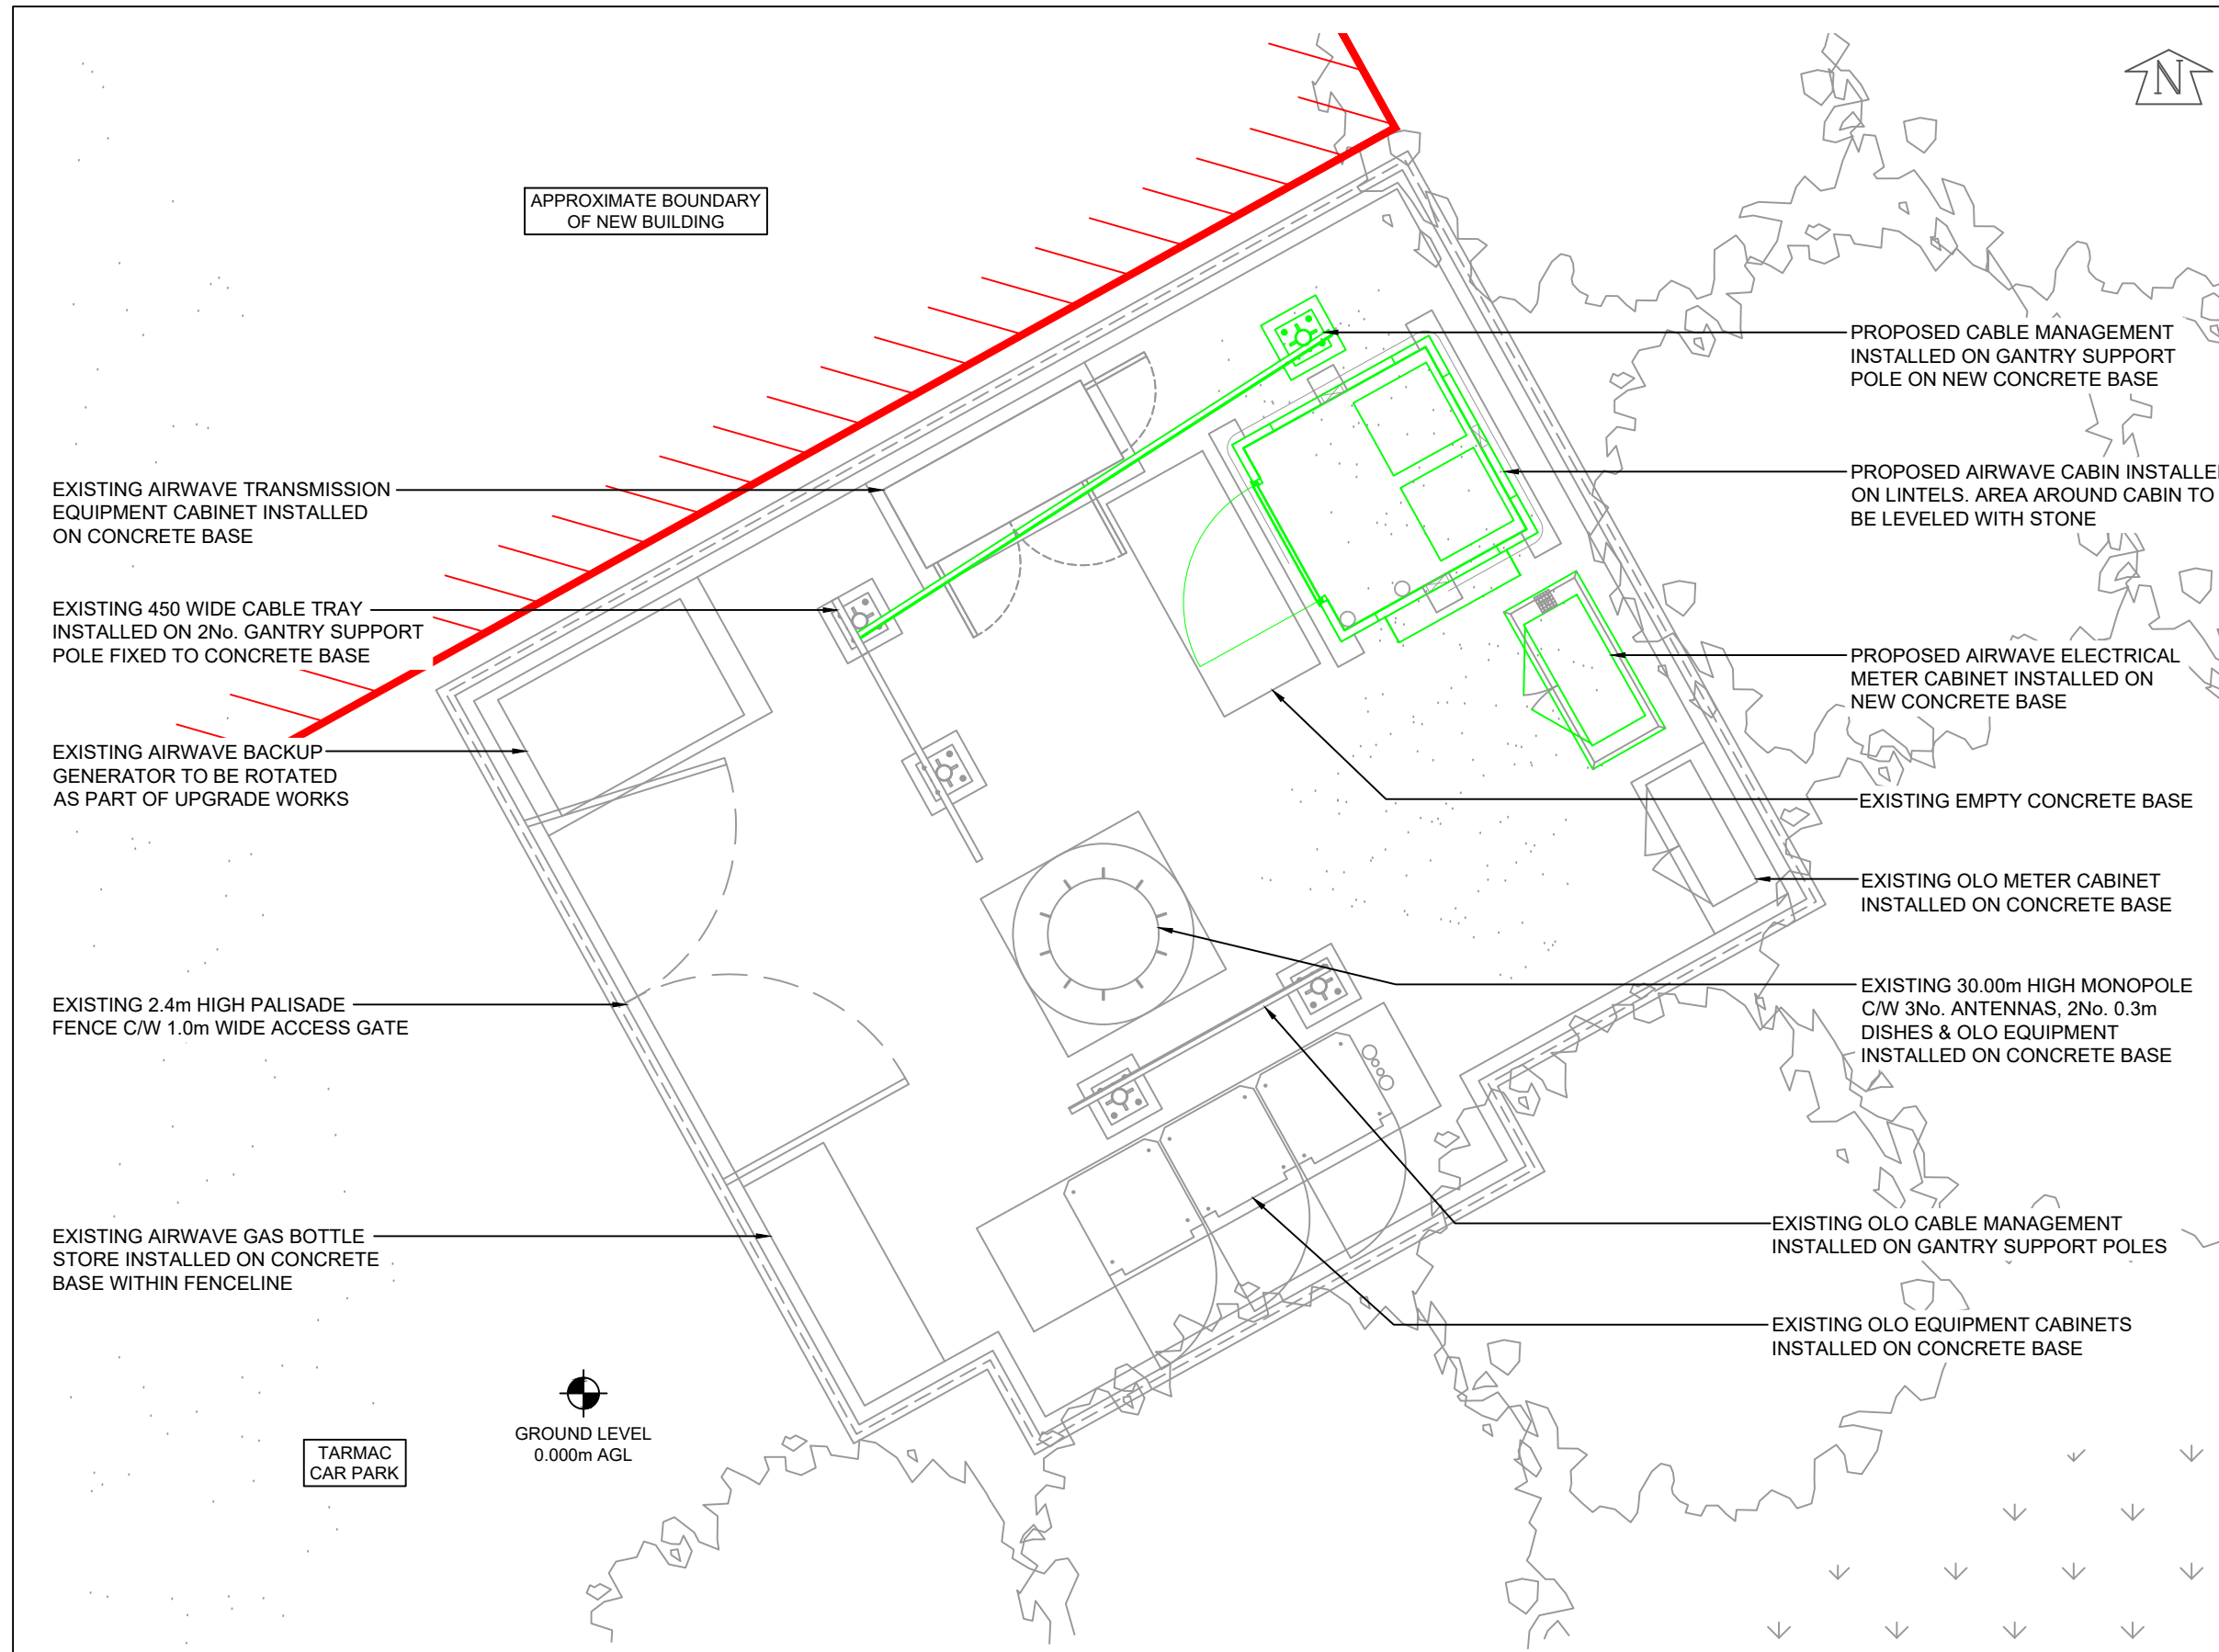

PROPOSED SITE PLAN
(SCALE 1:50)



The design of this site is in accordance with the following design documentation:
Radio Base Station Design Guide & Specification - Issue Date 03.02.06
Technical Guidance Notes - TGN 0092 to TGN 0124 inclusive.

A	17.01.23	GENERAL ARRANGEMENT FOR COMMENT	DB	AM
Rev	Date	Amendments	Drawn By	Approved By

HEYROD COMMUNICATIONS LTD

Thornley House,
Overens Street,
Oldham, OL4 1LA

Tel: 0161 6224160
Fax: 0161 6224161

AIRWAVE
a Motorola Solutions Company

Job Title
STOWMARKET POLICE STATION
VIOLET HILL ROAD, STOWMARKET,
IP14 1NJ

Drawing Title
GENERAL ARRANGEMENT
PROPOSED SITE PLAN
SHEET 04

Scale 1:100	Version V.0	Checked by AM	Approved by TH
Drawn by DB	Date Drawn 17.01.23	Date Checked 17.01.23	Date Approved 17.01.23

Drawing No. **SUF021-GA-04**