
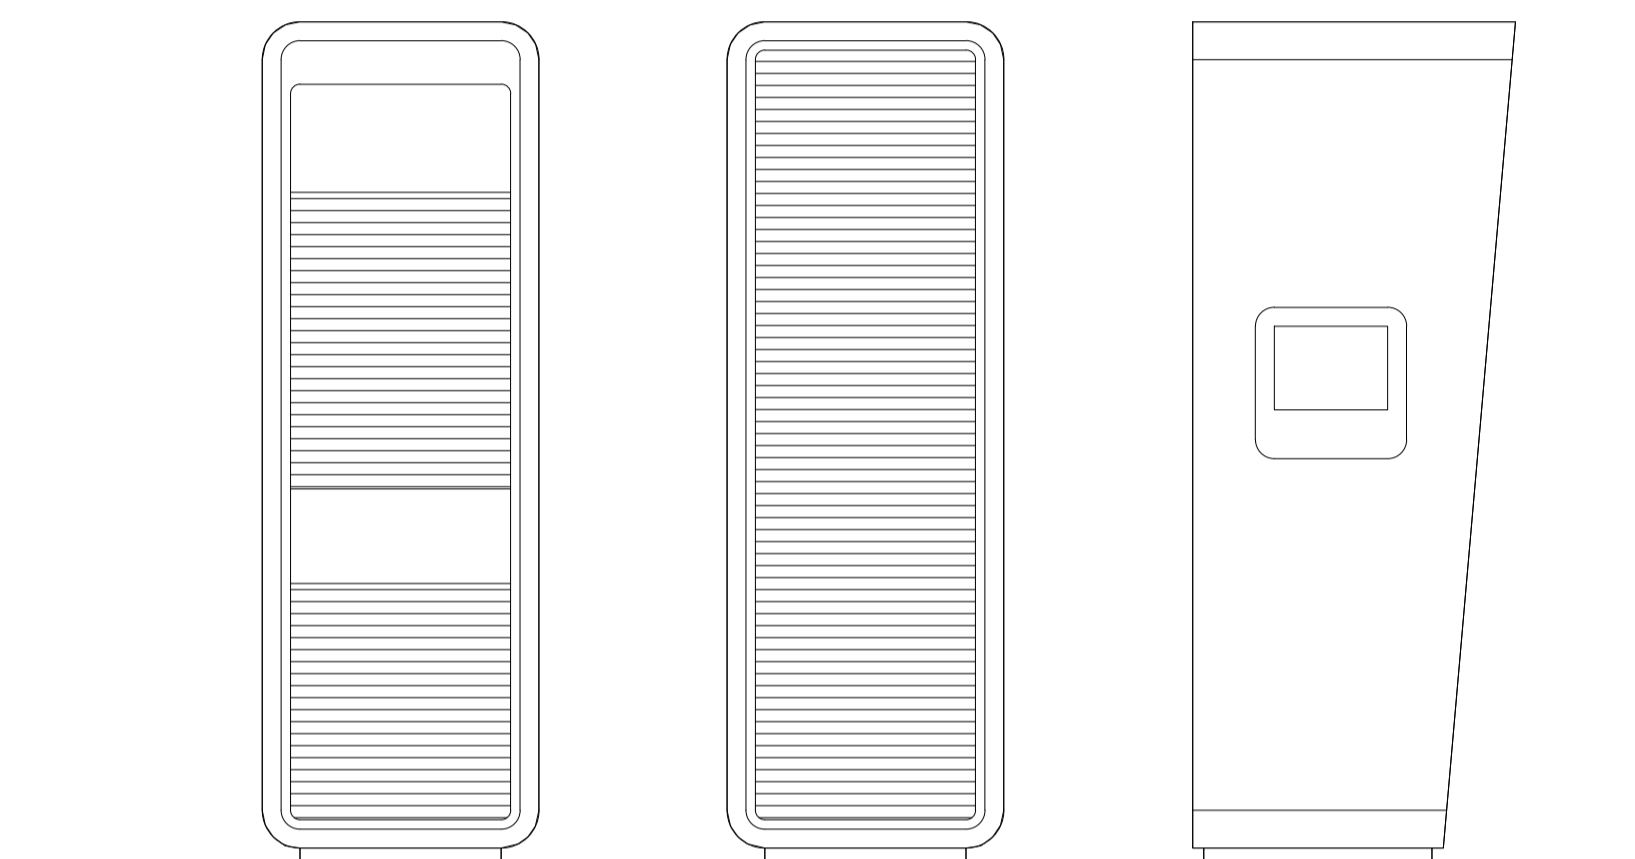
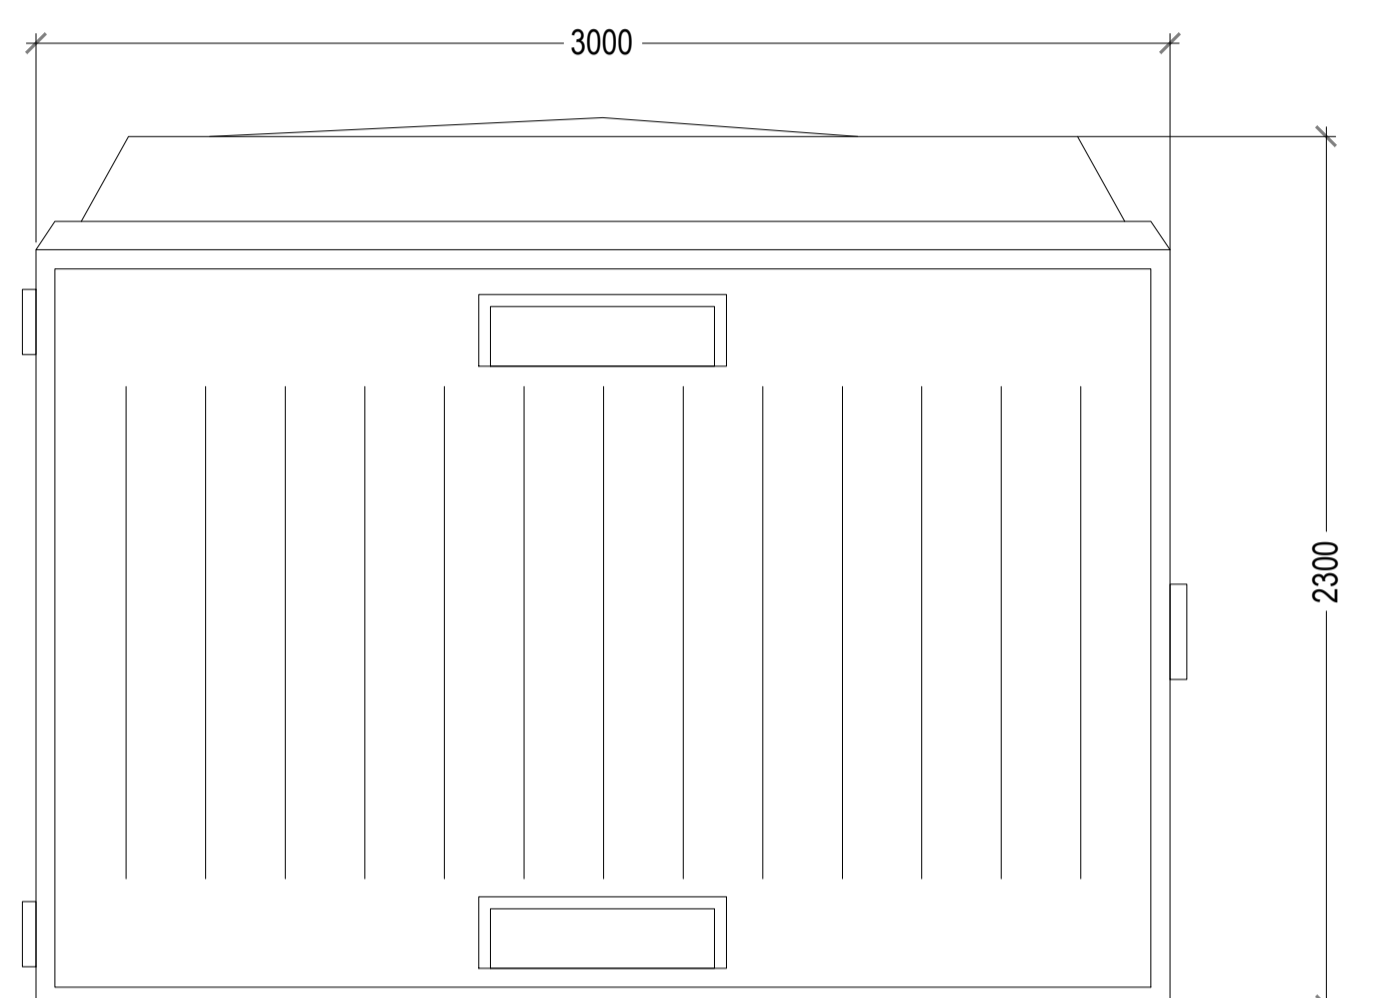


**GENERAL NOTES**

THIS DRAWING HAS BEEN PREPARED FOR PLANNING PURPOSES ONLY.





THIS DRAWING IS TO BE READ IN CONJUNCTION WITH THE FOLLOWING:

- PIED PIPER 10019036- PLG-00- 23 SITE LOCATION PLAN
- PIED PIPER 10019036- PLG-01- 23 BLOCK PLAN
- PIED PIPER 10019036- PLG-02- 23 EXISTING SITE LAYOUT
- PIED PIPER 10019036- PLG-03- 23 PROPOSED SITE LAYOUT
- PIED PIPER 10019036- PLG-04- 23 TRACKING PLAN
- PIED PIPER 10019036- PLG-05- 23 EV EQUIPMENT
- PIED PIPER 10019036- PLG-06- 23 EV CANOPY DETAIL
- PIED PIPER 10019036- PLG-07- 23 EXISTING SITE ELEVATIONS
- PIED PIPER 10019036- PLG-08- 23 PROPOSED SITE ELEVATIONS

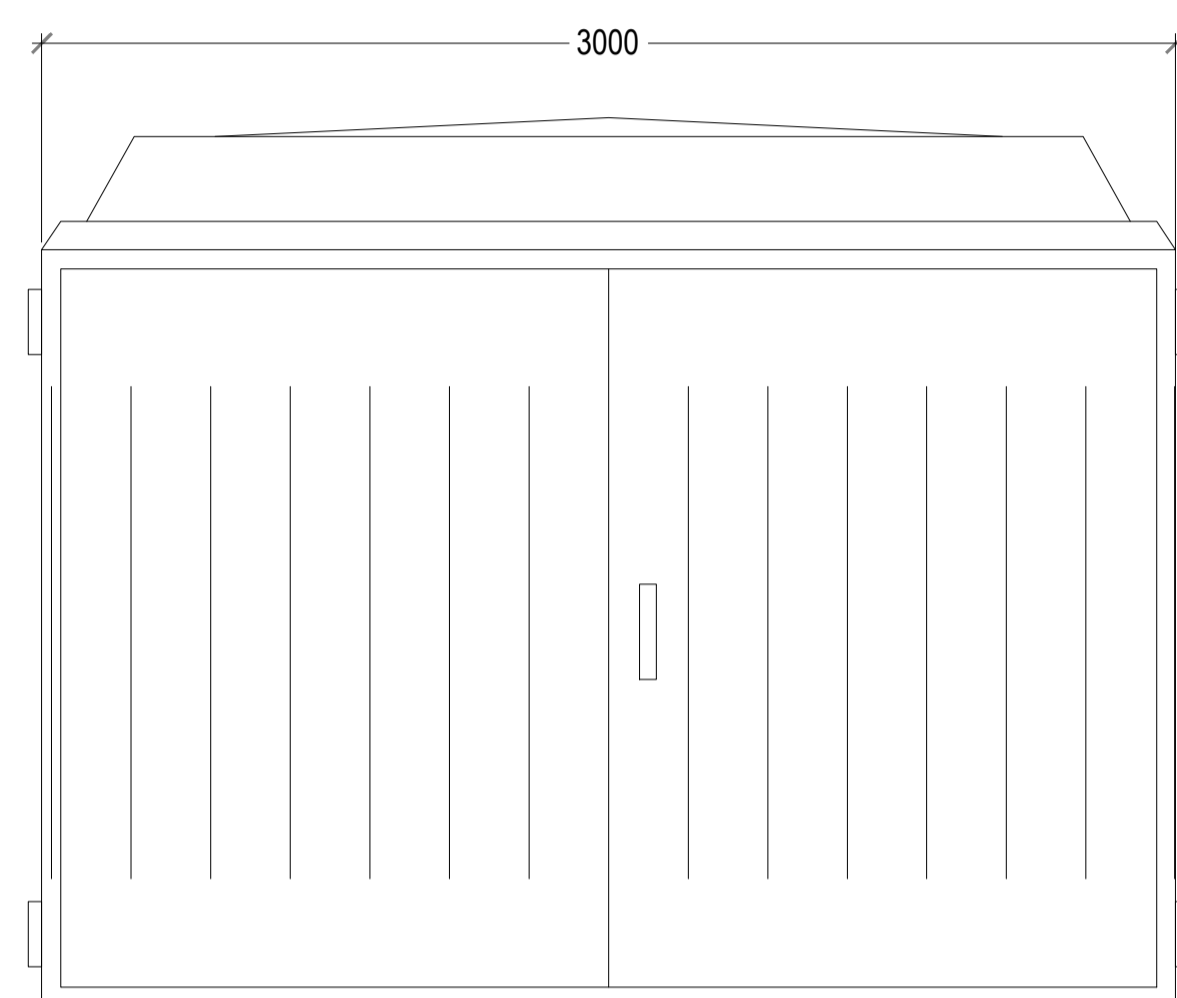

**SUB-STATION ELEVATIONS (SIZE TO BE CONFIRMED)**  
 (External finish Green)  
 Scale 1:20

FRONT ELEVATION    BACK ELEVATION    SIDE ELEVATION  
**CHARGING UNIT**  
 Scale 1:20

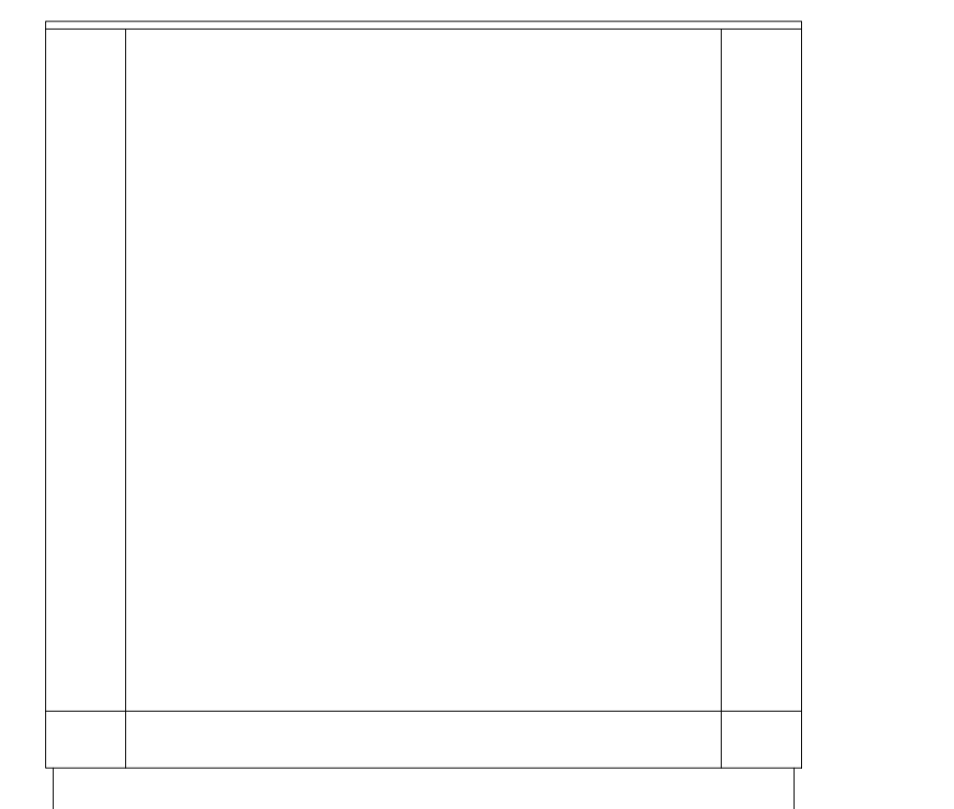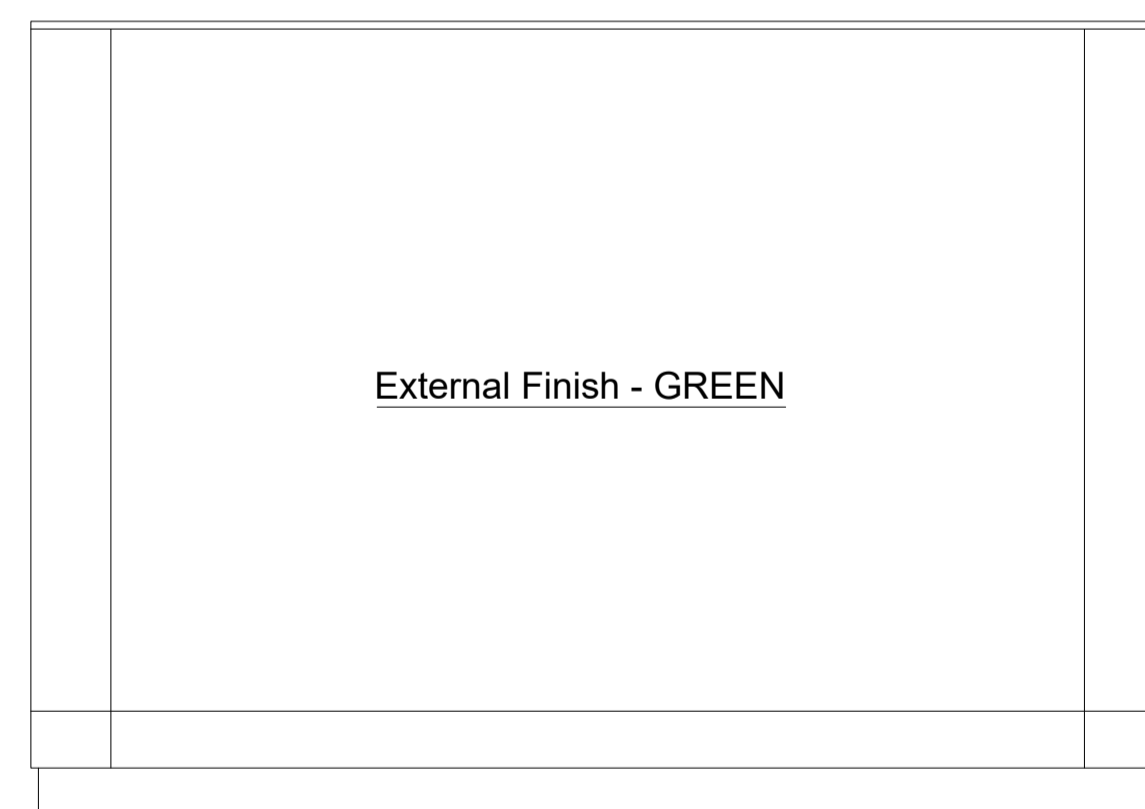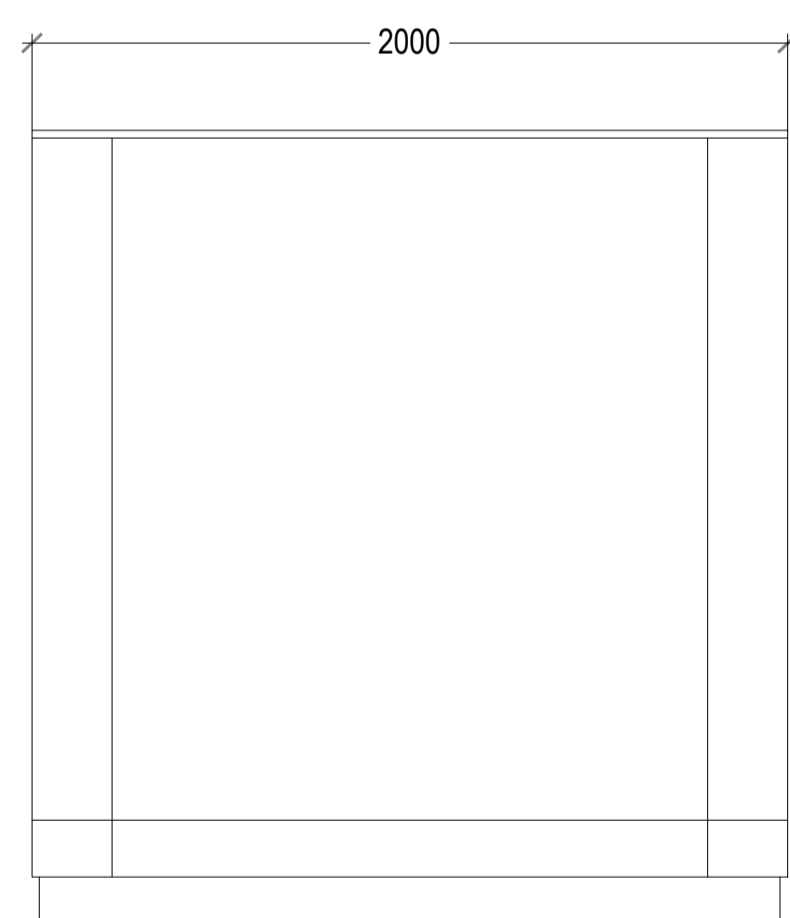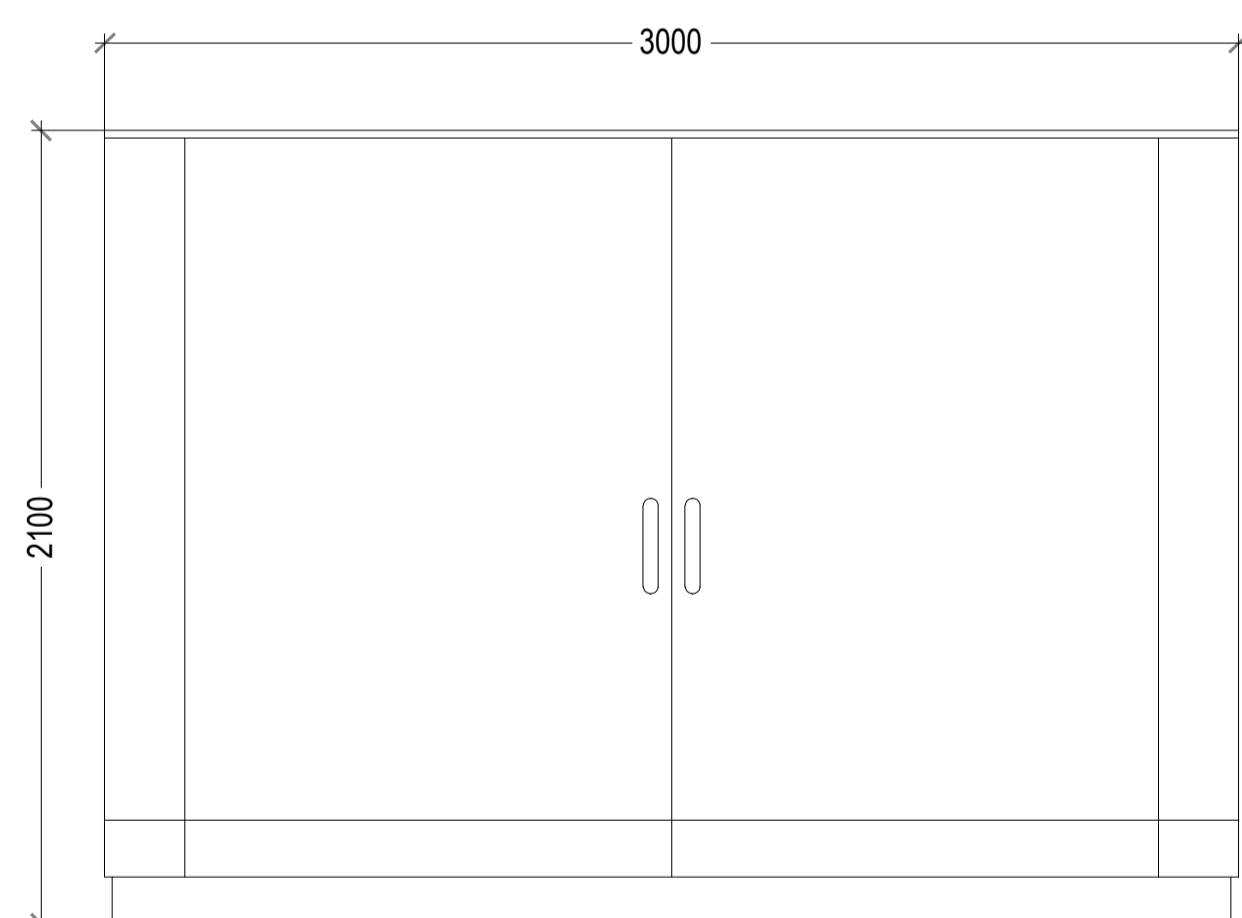


Front Elevation

Side Elevation

Rear Elevation

Side Elevation

**TYPICAL MAINS GRP CABINET ELEVATIONS**  
 Scale 1:20

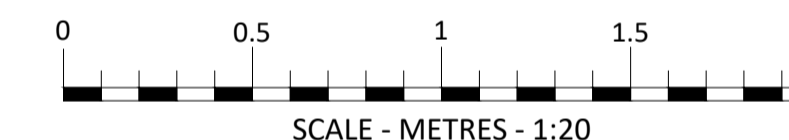

**ALPITRONIC HYC 300 CHARGERS**

PROJECT MANAGERS :



DESIGNERS :




PHASE : **PLANNING**

REV	DATE	BY

PROJECT: SHELL PIED PIPER SERVICE STATION,  
 WINCESTER ROAD, BASINGSTOKE,  
 HAMPSHIRE, RG22 6HT

TITLE: EV EQUIPMENT



SHELL UK OIL PRODUCTS LTD.  
 SHELL CENTRE, YORK ROAD,  
 LONDON, SE1 7NA  
 UNITED KINGDOM

DRAWN BY:	JF/WJS	SCALE:	1:20@A1
DATE:	02.11.2023	PLOT DATE:	02.01.2023
CAD FILE:	M:\ARTELIA\EX-COTEBA\14271\PIED PIPER 10019036-PLG-23		

DWG No :	10019036	PLG-05	23
----------	----------	--------	----