

New lighting within Classroom 1 to comprise 3Nr Skylite UGR 28w 4000k 600 x 600mm recessed luminaires by JCC (1Nr. emergency) controlled from existing switching locations including all new cabling and lighting control module (LCM) / marshalling box. LCM to be fixed above the level of the new suspended ceiling.

Install new suspended ceiling grid throughout at a height of approx 2800mm (TBC) comprising of Ecophon Ltd. Focus E system Class A 600x600x20mm Ecophon White 010 tiles on Ecophon Connect T24 main running (White 010) CI fully demountable suspension system.

Area 26.5m²

New lighting within Classroom 1 to comprise 3Nr Skylite UGR 28w 4000k 600 x 600mm recessed luminaires by JCC (1Nr. emergency) controlled from existing switching locations including all new cabling and lighting control module (LCM) / marshalling box. LCM to be fixed above the level of the suspended ceiling.

Area 26.5m²

New lighting within Corridor to comprise 6Nr Skylite UGR 28w 4000k 600 x 600mm recessed luminaires by JCC (3Nr. emergency) controlled from existing switching locations including all new cabling and lighting control module (LCM) / marshalling box. LCM to be fixed above the level of the new suspended ceiling.

Install new suspended ceiling grid throughout at a height of approx 2800mm (TBC) comprising of Ecophon Ltd. Focus E system Class A 600x600x20mm Ecophon White 010 tiles on Ecophon Connect T24 main running (White 010) CI fully demountable suspension system.

Area 26.5m²

New lighting within HT Office to comprise 2Nr Skylite UGR 28w 4000k 600 x 600mm recessed luminaires by JCC (1Nr. emergency) controlled from existing switching locations including all new cabling and lighting control module (LCM) / marshalling box. LCM to be fixed above the level of the new suspended ceiling.

Install new suspended ceiling grid throughout at a height of approx 2800mm (TBC) comprising of Ecophon Ltd. Focus E system Class A 600x600x20mm Ecophon White 010 tiles on Ecophon Connect T24 main running (White 010) CI fully demountable suspension system.


Area 9.2m²

New lighting within Classroom 2 to comprise 6Nr Skylite UGR 28w 4000k 600 x 600mm recessed luminaires by JCC (2Nr. emergency) controlled from existing switching locations including all new cabling and lighting control module (LCM) / marshalling box. LCM to be fixed above the level of the new suspended ceiling.

Construct new unit for Belfast Sink with 50x50mm framing, plinth, shadow gap, boxed end and 'Ke-Ku' clips for new 12.5mm SGL underpanels and 13mm thick Solid Grade Laminate vanity top. Approximate size 600 x 1200 x 800mm high. Supply and fit new underslung Belfast sink 600x 460x260mm heavy duty (S8769) including 1 1/2 inch slotted waste and 1 1/2 inch plastic resealing bottle with 75mm seal multi purpose outlet.

Supply and fit Allora Quadrant 1/4 inch quarter turn high neck sink pillar taps and adapt existing supply pipework to suit new tap locations. Allow for new TMV pre-set to 41 deg C.

Line wall behind new sink with 2.5mm thick Altro Whiterock Splashback wall cladding. Including all adhesive, prime and colour matched jointed strips with silicon sealing pointing at junction between worktop and Whiterock and all internal corners.

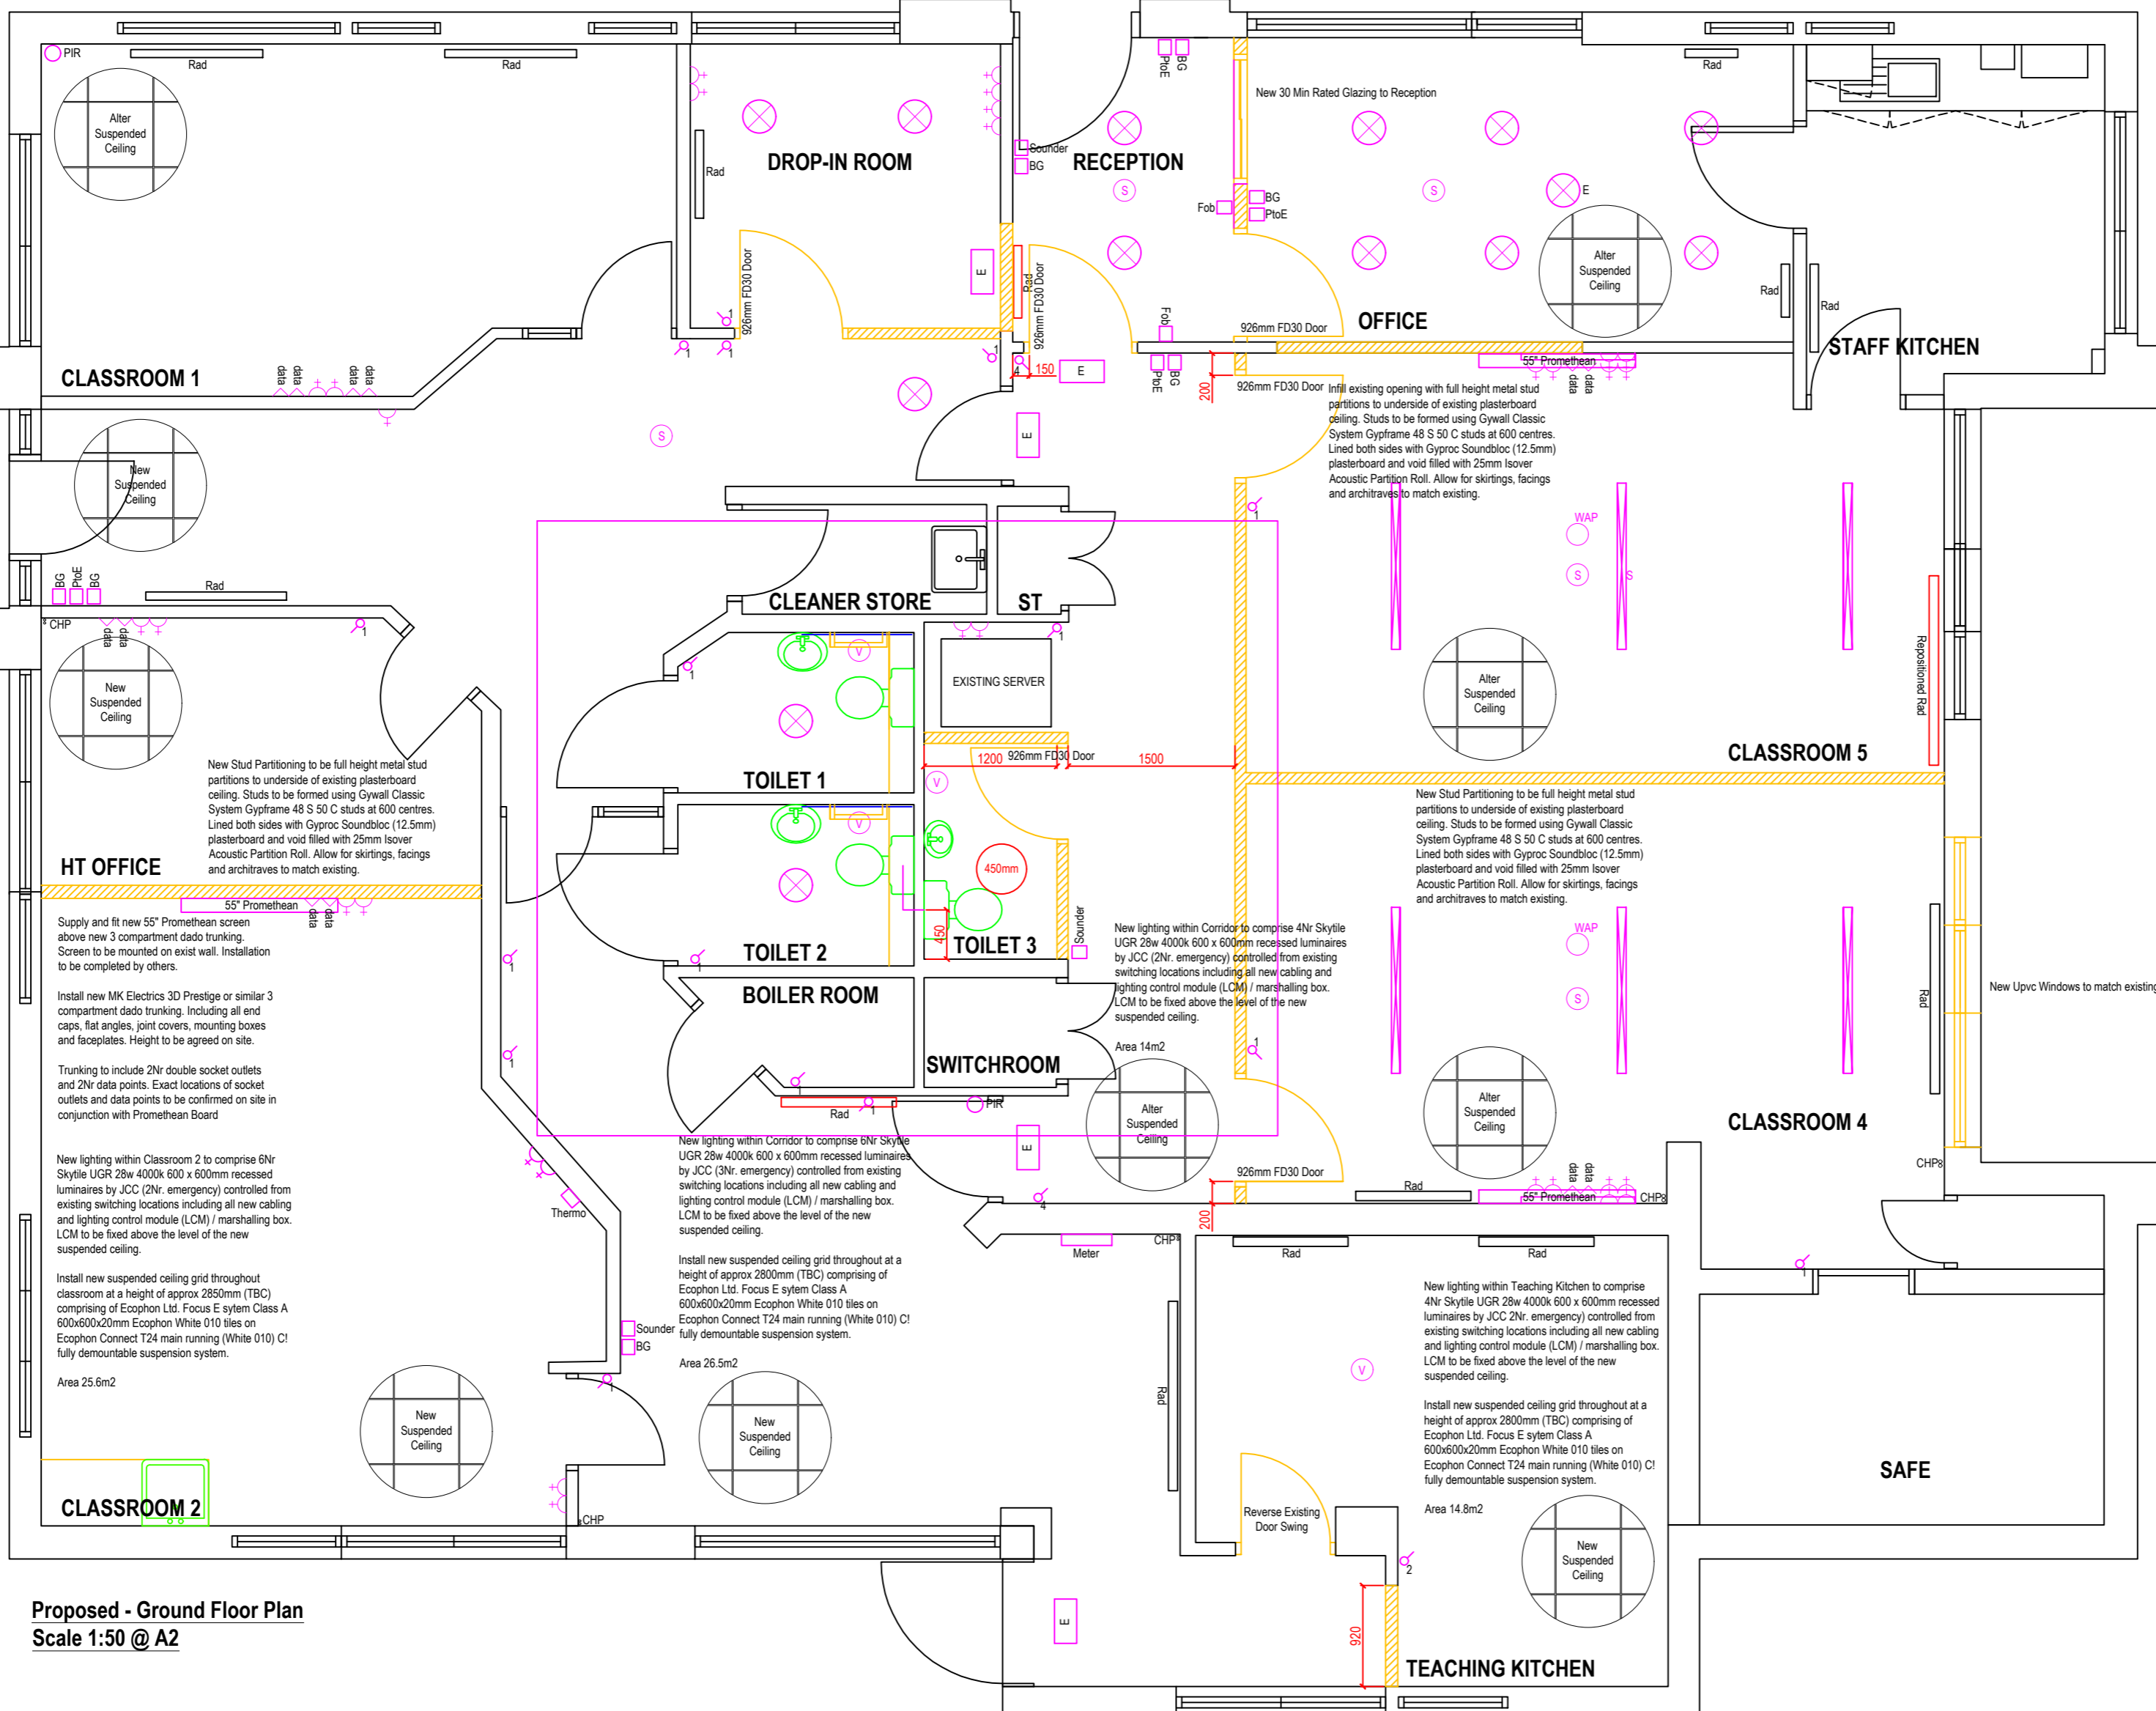

Proposed - Ground Floor Plan
Scale 1:50 @ A2

Crown Copyright
East Dumbartonshire Council Licence No. 100020774

TITLE 21 Southbank Road, Kirkintilloch DRAFT		
SCALE 1:50 @ A2	FILE REF.	DRG. No. 21SB003
DATE 12.03.2021	CLS. REF.	REVISION
DRAWN BY JG		