



NOTE
FOR ALL SECTIONS
SEE DRG 1617 / 3

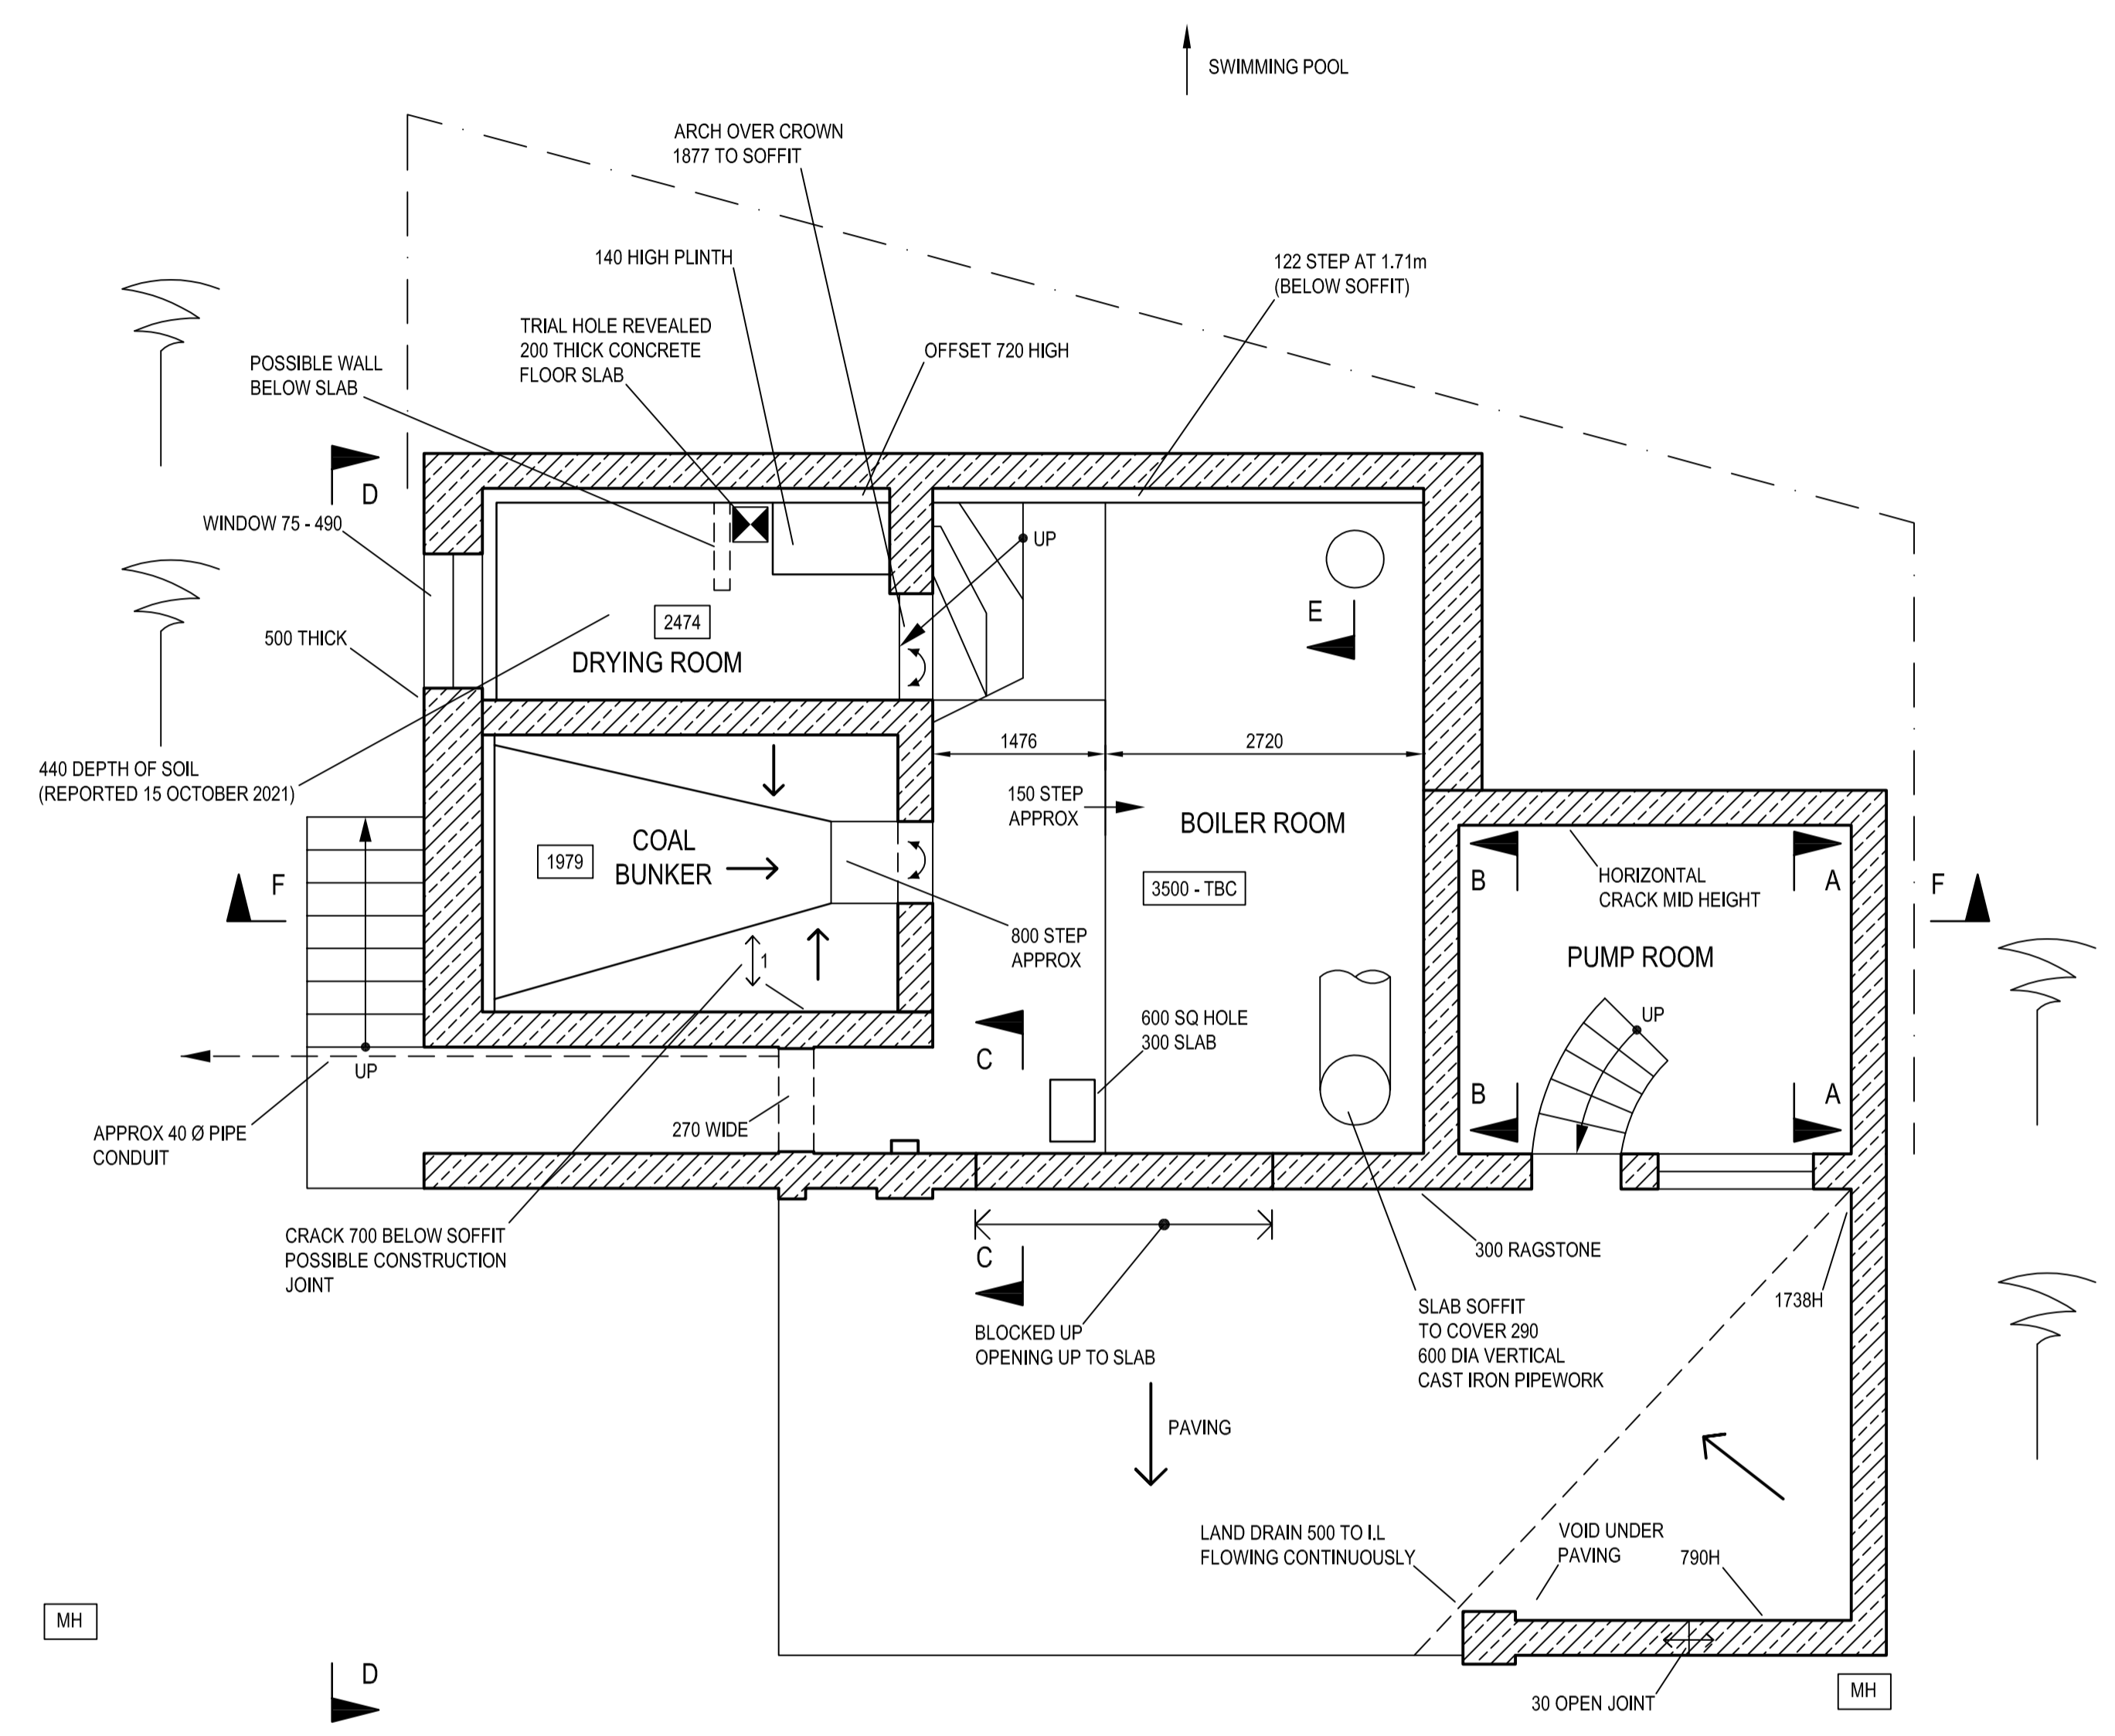

PUMPING STATION PLAN
SCALE 1:50

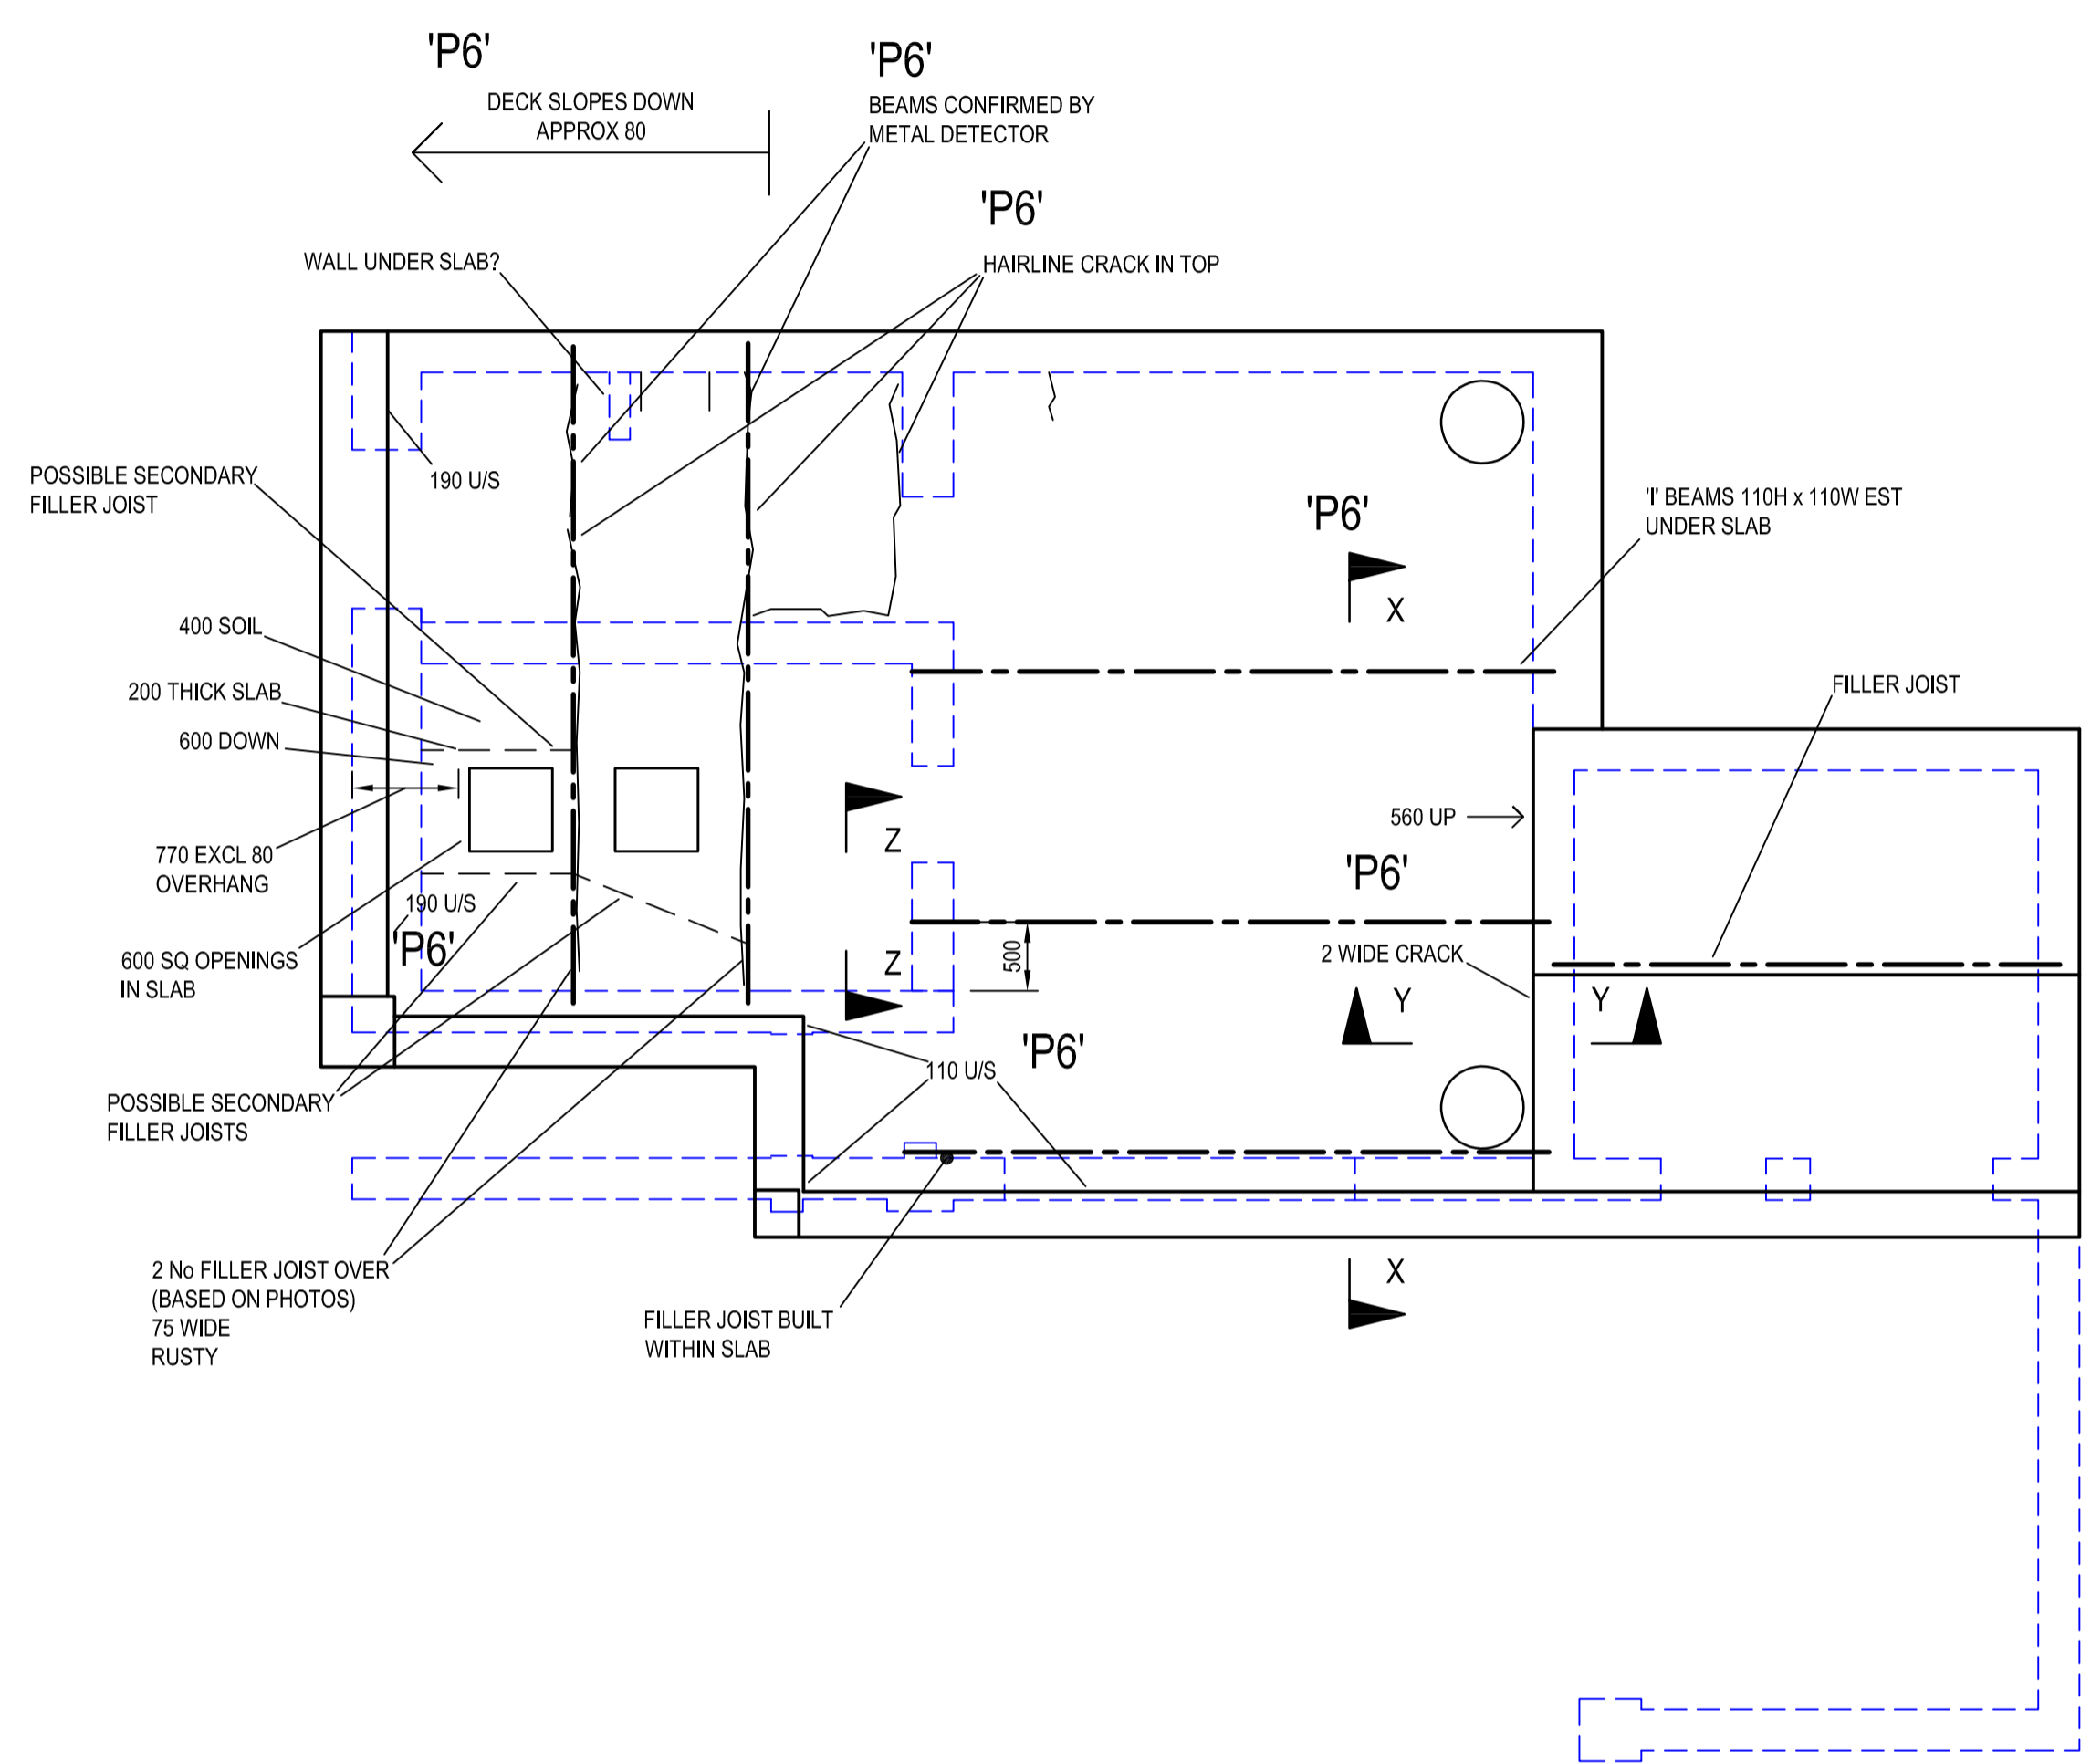

PUMPING STATION ROOF PLAN
SCALE 1:50

KEY TO WALL NOTATION

- ← 2 = WIDTH OF CRACK IN mm AND DIRECTION OF DISPLACEMENT
- ↕ = SHEAR DISPLACEMENT
- ⊙ = DISPLACEMENT INTO PLANE OF PAPER (TAIL OF DART)
- ⊙ = DISPLACEMENT OUT OF PLANE OF PAPER (HEAD OF DART)
- TT = OLD TELL TALE CRACK
- HL = HAIRLINE CRACK
- U/S = UPSTAND

ACA JOB No 1617

PRELIMINARY

Rev	Date	Drawn	Amendment
P6	14.8.23	JB	Minor amendments as 'P6'
P5	23.6.23	JB	Minor amendments as 'P5'
P4	15.3.23	JB	Hole in slab moved - as 'P4'
P3	2.12.21	JB	Updated to show results 3rd inspection 30 Sept 2021
P2	15.7.21	JB	Updated to show results 2nd inspection
P1	24.2.21	JB	Preliminary issue



Suffolk House 154 High Street
Sevenoaks Kent TN13 1XE UK
UK: +44 (0)1732 740195
www.ctp-llp.com

Job
Swimming Pool Pumping Station
Chartwell
Westerham
TN16 6PS

Description
Existing Plans

Scale	1:50 at A1		
Drawn	JB	Checked	AC
Date	Feb 2021	Drg No	A9514 / 2 P6

