



Project No: D6322	Drawing No: E.04	Revision no: A
-----------------------------	----------------------------	--------------------------

Title:
Proposed Site Plan Electrical Services

- Notes:
- | No. | Detail: |
|-----|---|
| 1. | DIMENSIONS
Figured dimensions are to be taken in preference to scaled dimensions. All dimensions are to be verified on site prior to work commencing. |
| 2. | DISCREPANCIES
Any discrepancy is to be referred to the consultant before proceeding. |
| 3. | COPYRIGHT © 2023
Copyright in this drawing is the property of Michael Jones & Associates LLP and must not be reproduced nor amended nor used for the execution of any works whether in connection with the proposed works for which it is prepared or otherwise without the express consent of Michael Jones & Associates LLP. All rights reserved. |
| 4. | RELATED DOCUMENTS
This drawing shall be read in conjunction with the relevant written Specification of Works, accompanying drawings equipment schedules and all other relevant documents connected to those works shown on this drawing. |

NOTES

1. LV CABLE SERVING NEW DB4 LOCATION SHALL BE PULLED BACK FROM OLD LOCATION & TERMINATED AT NEW LOCATION. THE SUPPLY END OF THE CABLE SHALL BE DISCONTINUED FROM THE OLD BRICK BUILT ENCLOSURE / SWITCHGEAR ON THE SITE BOUNDARY & DIVERTED INTO THE MCCB PANELBOARD IN THE GREEN GRP ENCLOSURE ON THE SITE BOUNDARY.
2. THE SUPPLY END OF THE LV CABLE SERVING DB2 SHALL BE DISCONNECTED FROM THE OLD BRICK BUILT ENCLOSURE / SWITCHGEAR ON THE SITE BOUNDARY & DIVERTED INTO THE MCCB PANELBOARD IN THE GREEN GRP ENCLOSURE ON THE SITE BOUNDARY CONTRACTOR TO CHECK CABLE LENGTH

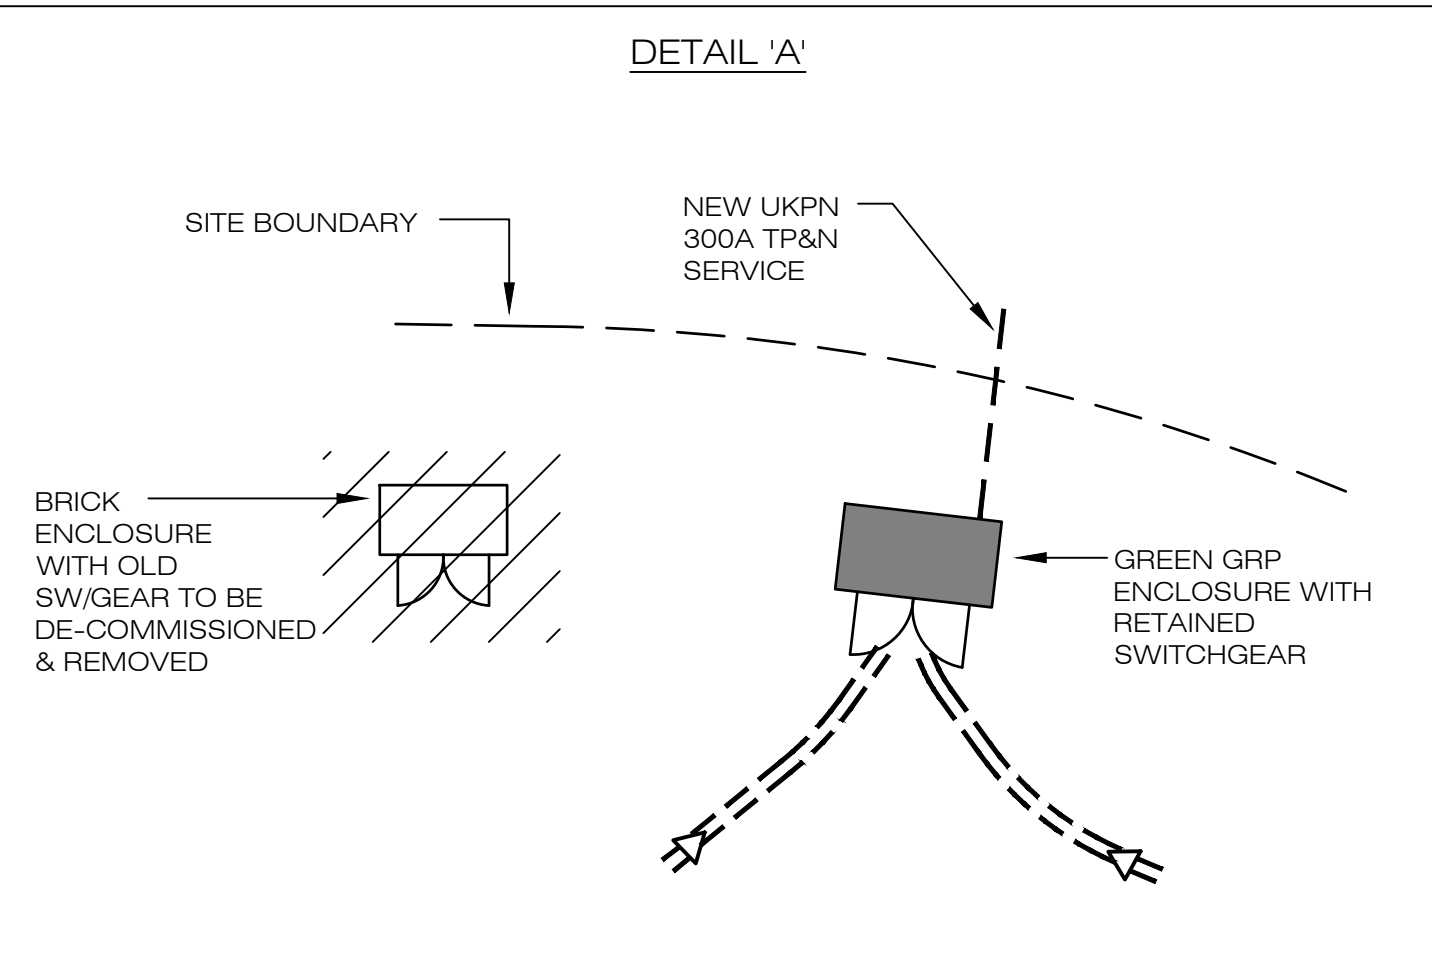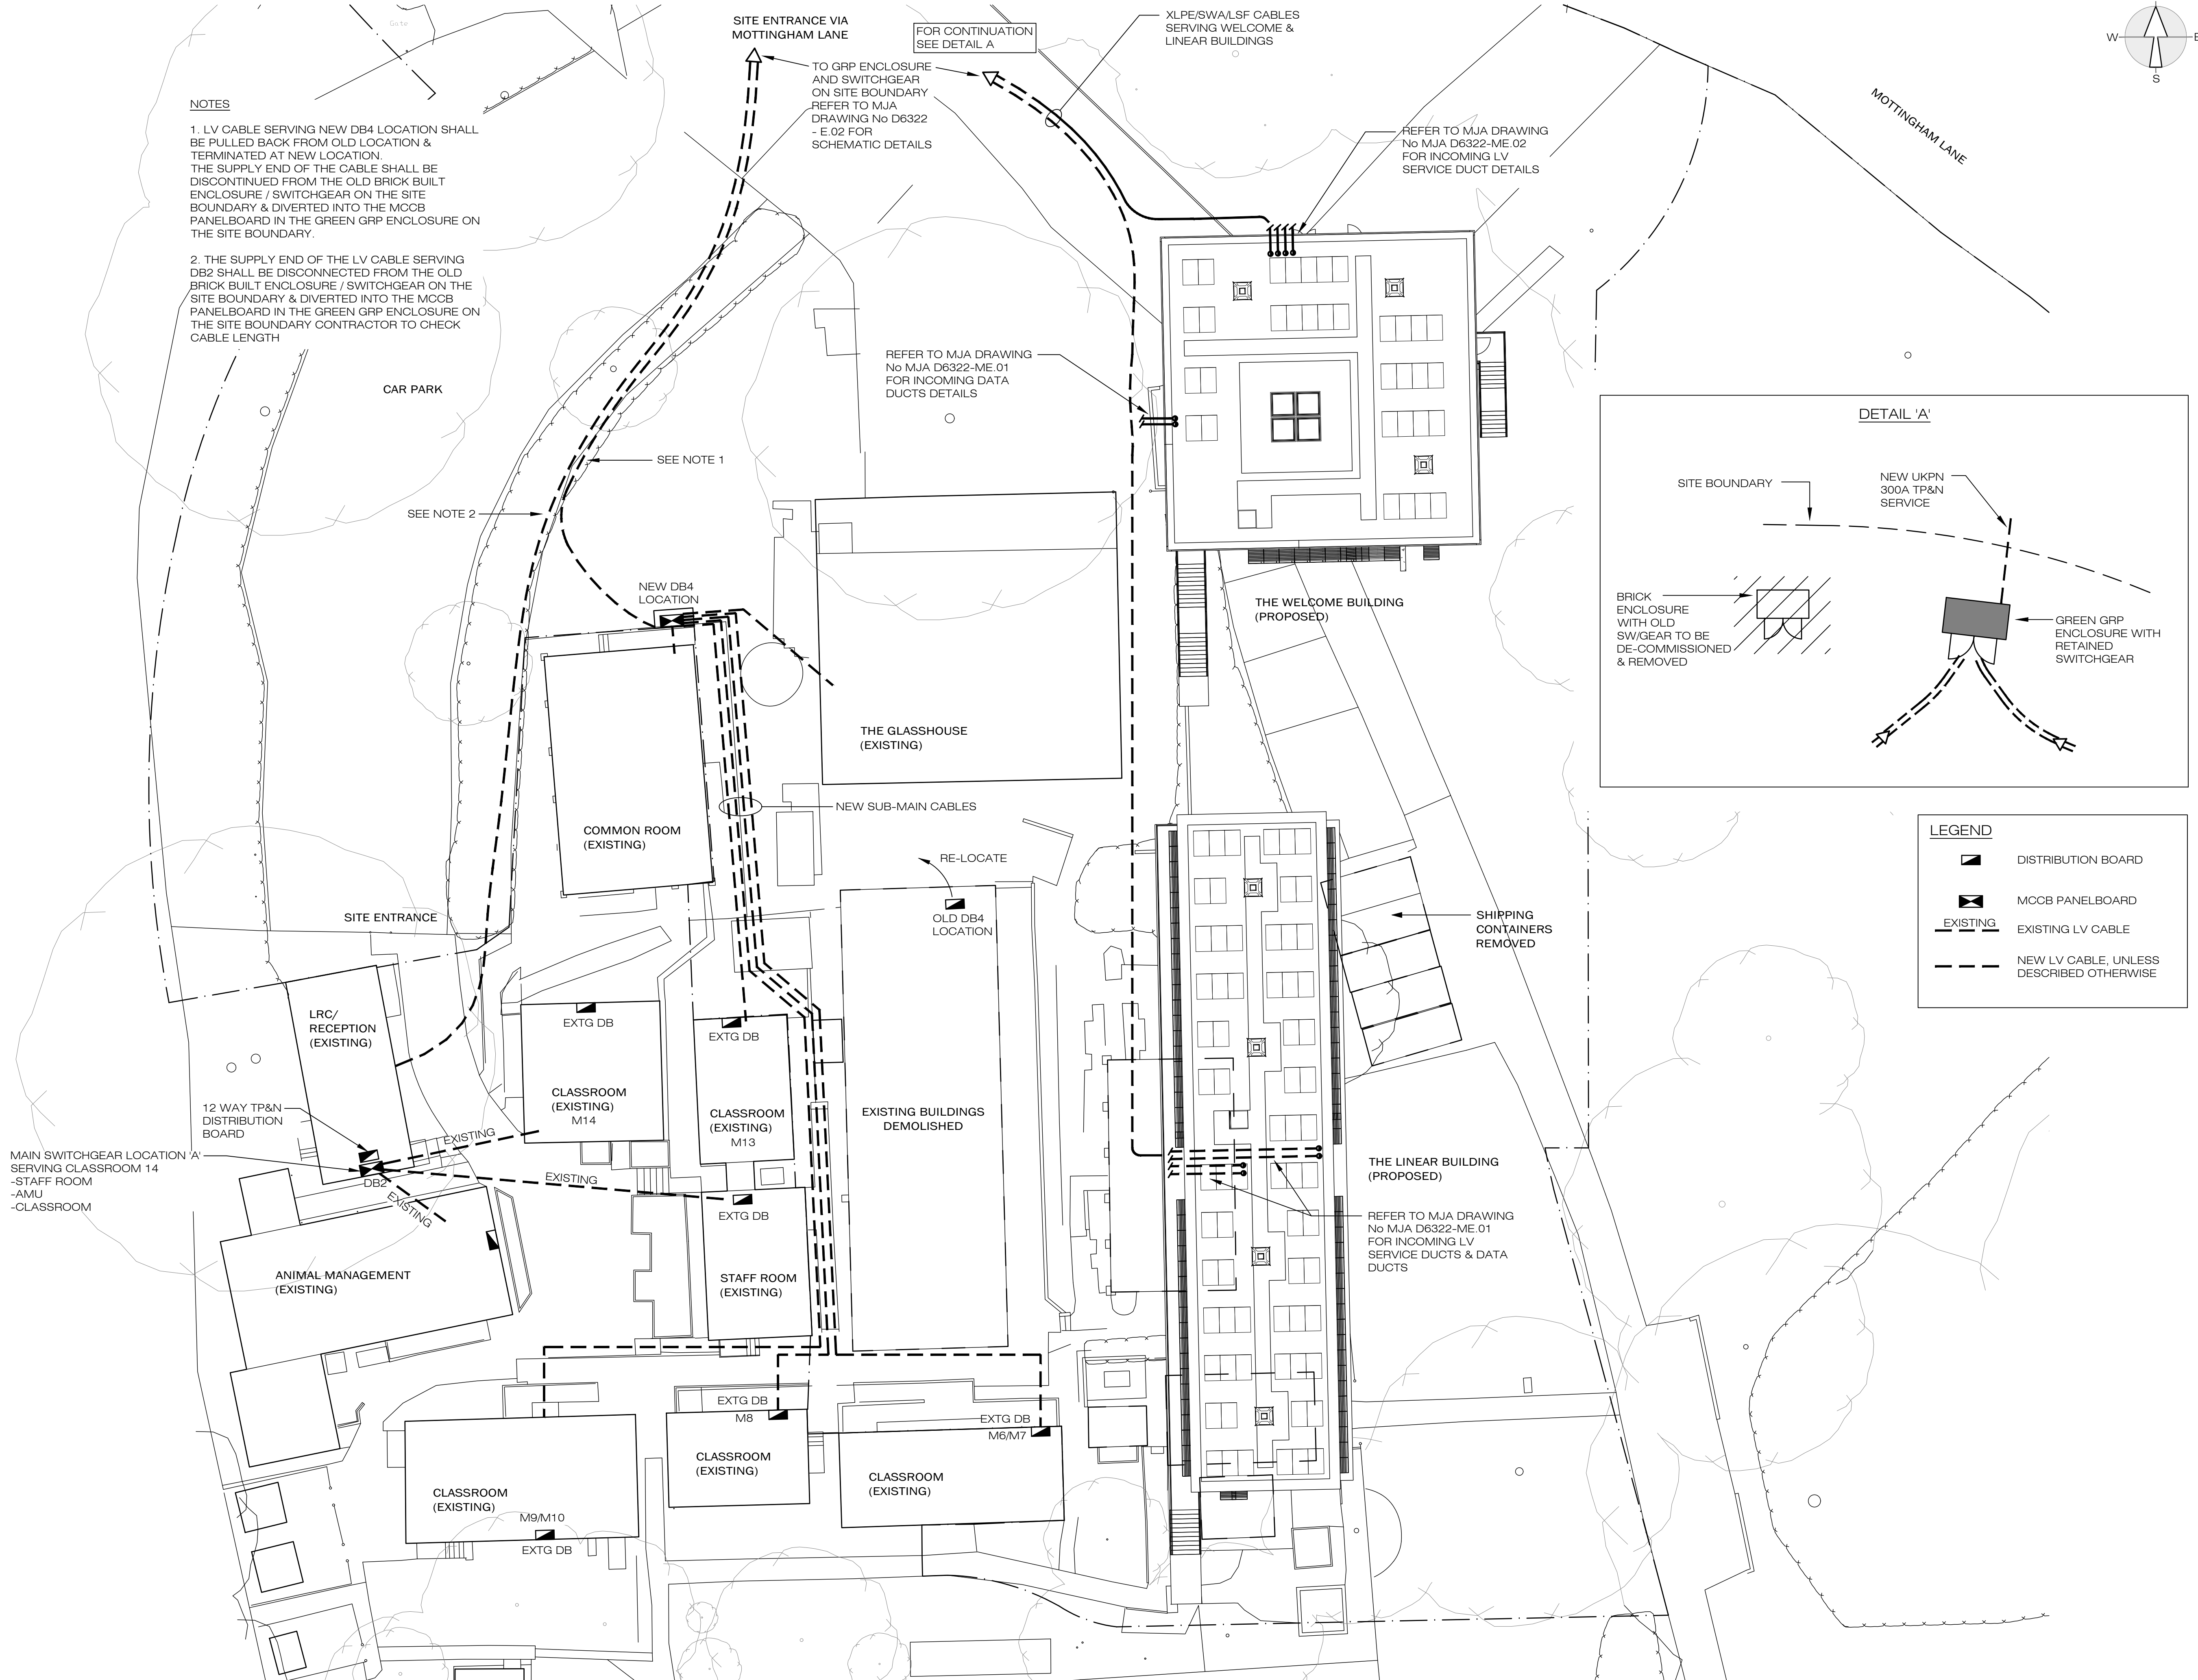

LEGEND

	DISTRIBUTION BOARD
	MCCB PANELBOARD
	EXISTING LV CABLE
	NEW LV CABLE, UNLESS DESCRIBED OTHERWISE

A	8th Dec 2023	TENDER ISSUE (DRAFT)
-	8th Sept 2023	PRELIMINARY ISSUE
No.	Date:	Amendment:
Revision:		

Michael Jones & Associates LLP
ENGINEERING CONSULTANTS
Crossway House
8 London Road, Reigate, Surrey, RH2 9HY
Tel: +44(0)1737 245610 Fax: +44(0)1737 241142
e mail: info@mjasociates.co.uk
www.mjasociates.co.uk

Scale:	Date:	Drawn:	Chkd:
1:200@A1	Sept 2023	PM	MJA

Client:
Capel Manor College c/o ACS

Project:
**Linear & Welcome Buildings
Capel Manor College,
Mottingham Lane, London, SE12 9AW**

Title:
Proposed Site Plan Electrical Services

Project No: D6322	Drawing No: E.04	Revision No: A
-----------------------------	----------------------------	--------------------------

TENDER ISSUE (DRAFT)