

 


Dylan Jones - Powerhouse Detail 1

North Elevation

Plinth Height
200mm

Section A-A

Temporary opening for pipe
min 800 x 800

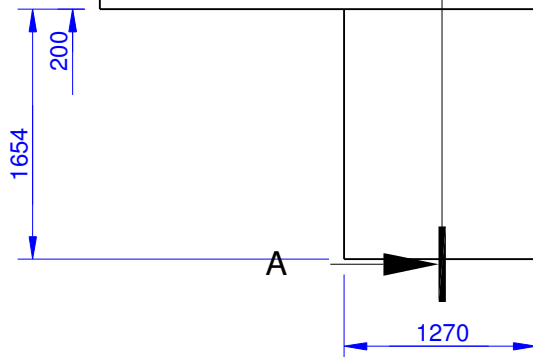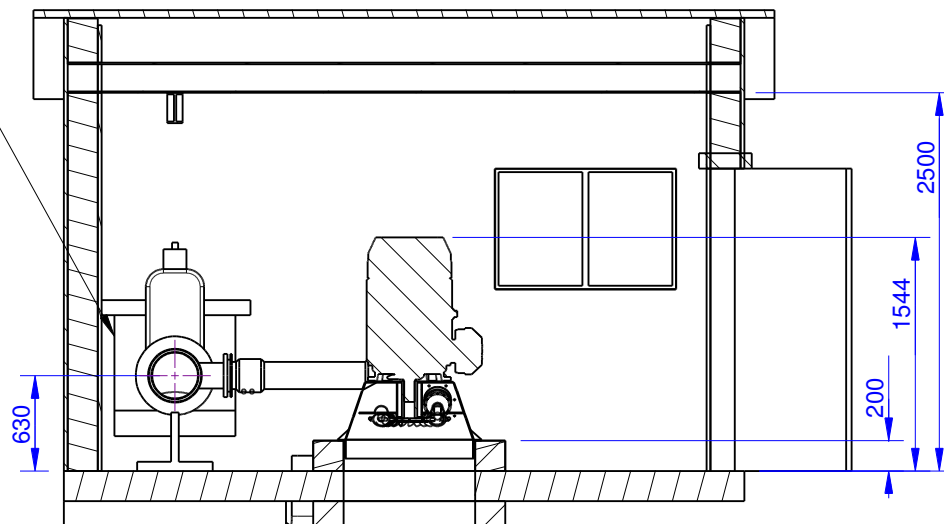

Tee to pig route
600mm
Twinwall
Tailrace

150mm cable duct
600mm Min Bend Radius

Item	Level mAOD
Top of Peg PH	161,149
Top of Peg X	160,931
Top of Peg Y	161,222
Top of Peg Z	161,064
Top of Peg Outfall	161,061
Top of Baseslab	160,831
Stainless screw in Rock, X3	160,681
Stainless screw in Rock, X4	163,270

All dimensions in mm. All levels relative to Newlyn.

Client : Dylan Jones
Address : Ty Mawr, Mallwyd
Machynlleth, SY20 9HS
Drawn By : MJP

Date : 16/01/23
Scale : 1 : 50 @ A4
Drawing No : 23011605
Version : 1

Revision Details



Greenearth Hydro Limited
Siop Newydd, Rhiw, Pwllheli, LL53 8AE
Tel: 07980 670046 www.greenearthhydro.co.uk
Company Registration Number 7417466
MCS Hydro Transition Installer 123