


 





 





-  Twin socket outlet
-  DATA outlet (i.e. CAT5e/CAT6)
-  Television outlet
-  Satellite TV outlet
-  Spur feeding low level outlet
-  32A Supply for kitchen appliance
-  Recessed downlight
-  Pendant
-  External wall light
-  Fan
-  Fan isolator
-  Heat detector c/w sounder



Draft for Comment

rev.	date	notes
CLIENT		
Chris Wilson		
PROJECT		
Kingfisher House 35 Tywardreath Highway		
TITLE		
Proposed Electrical layout		
DWG NO		REV
2809-600		
DRAWN BY	SCALE	
PPH	1:50@A1	
CHECKED BY	DATE	
	Sept 2022	

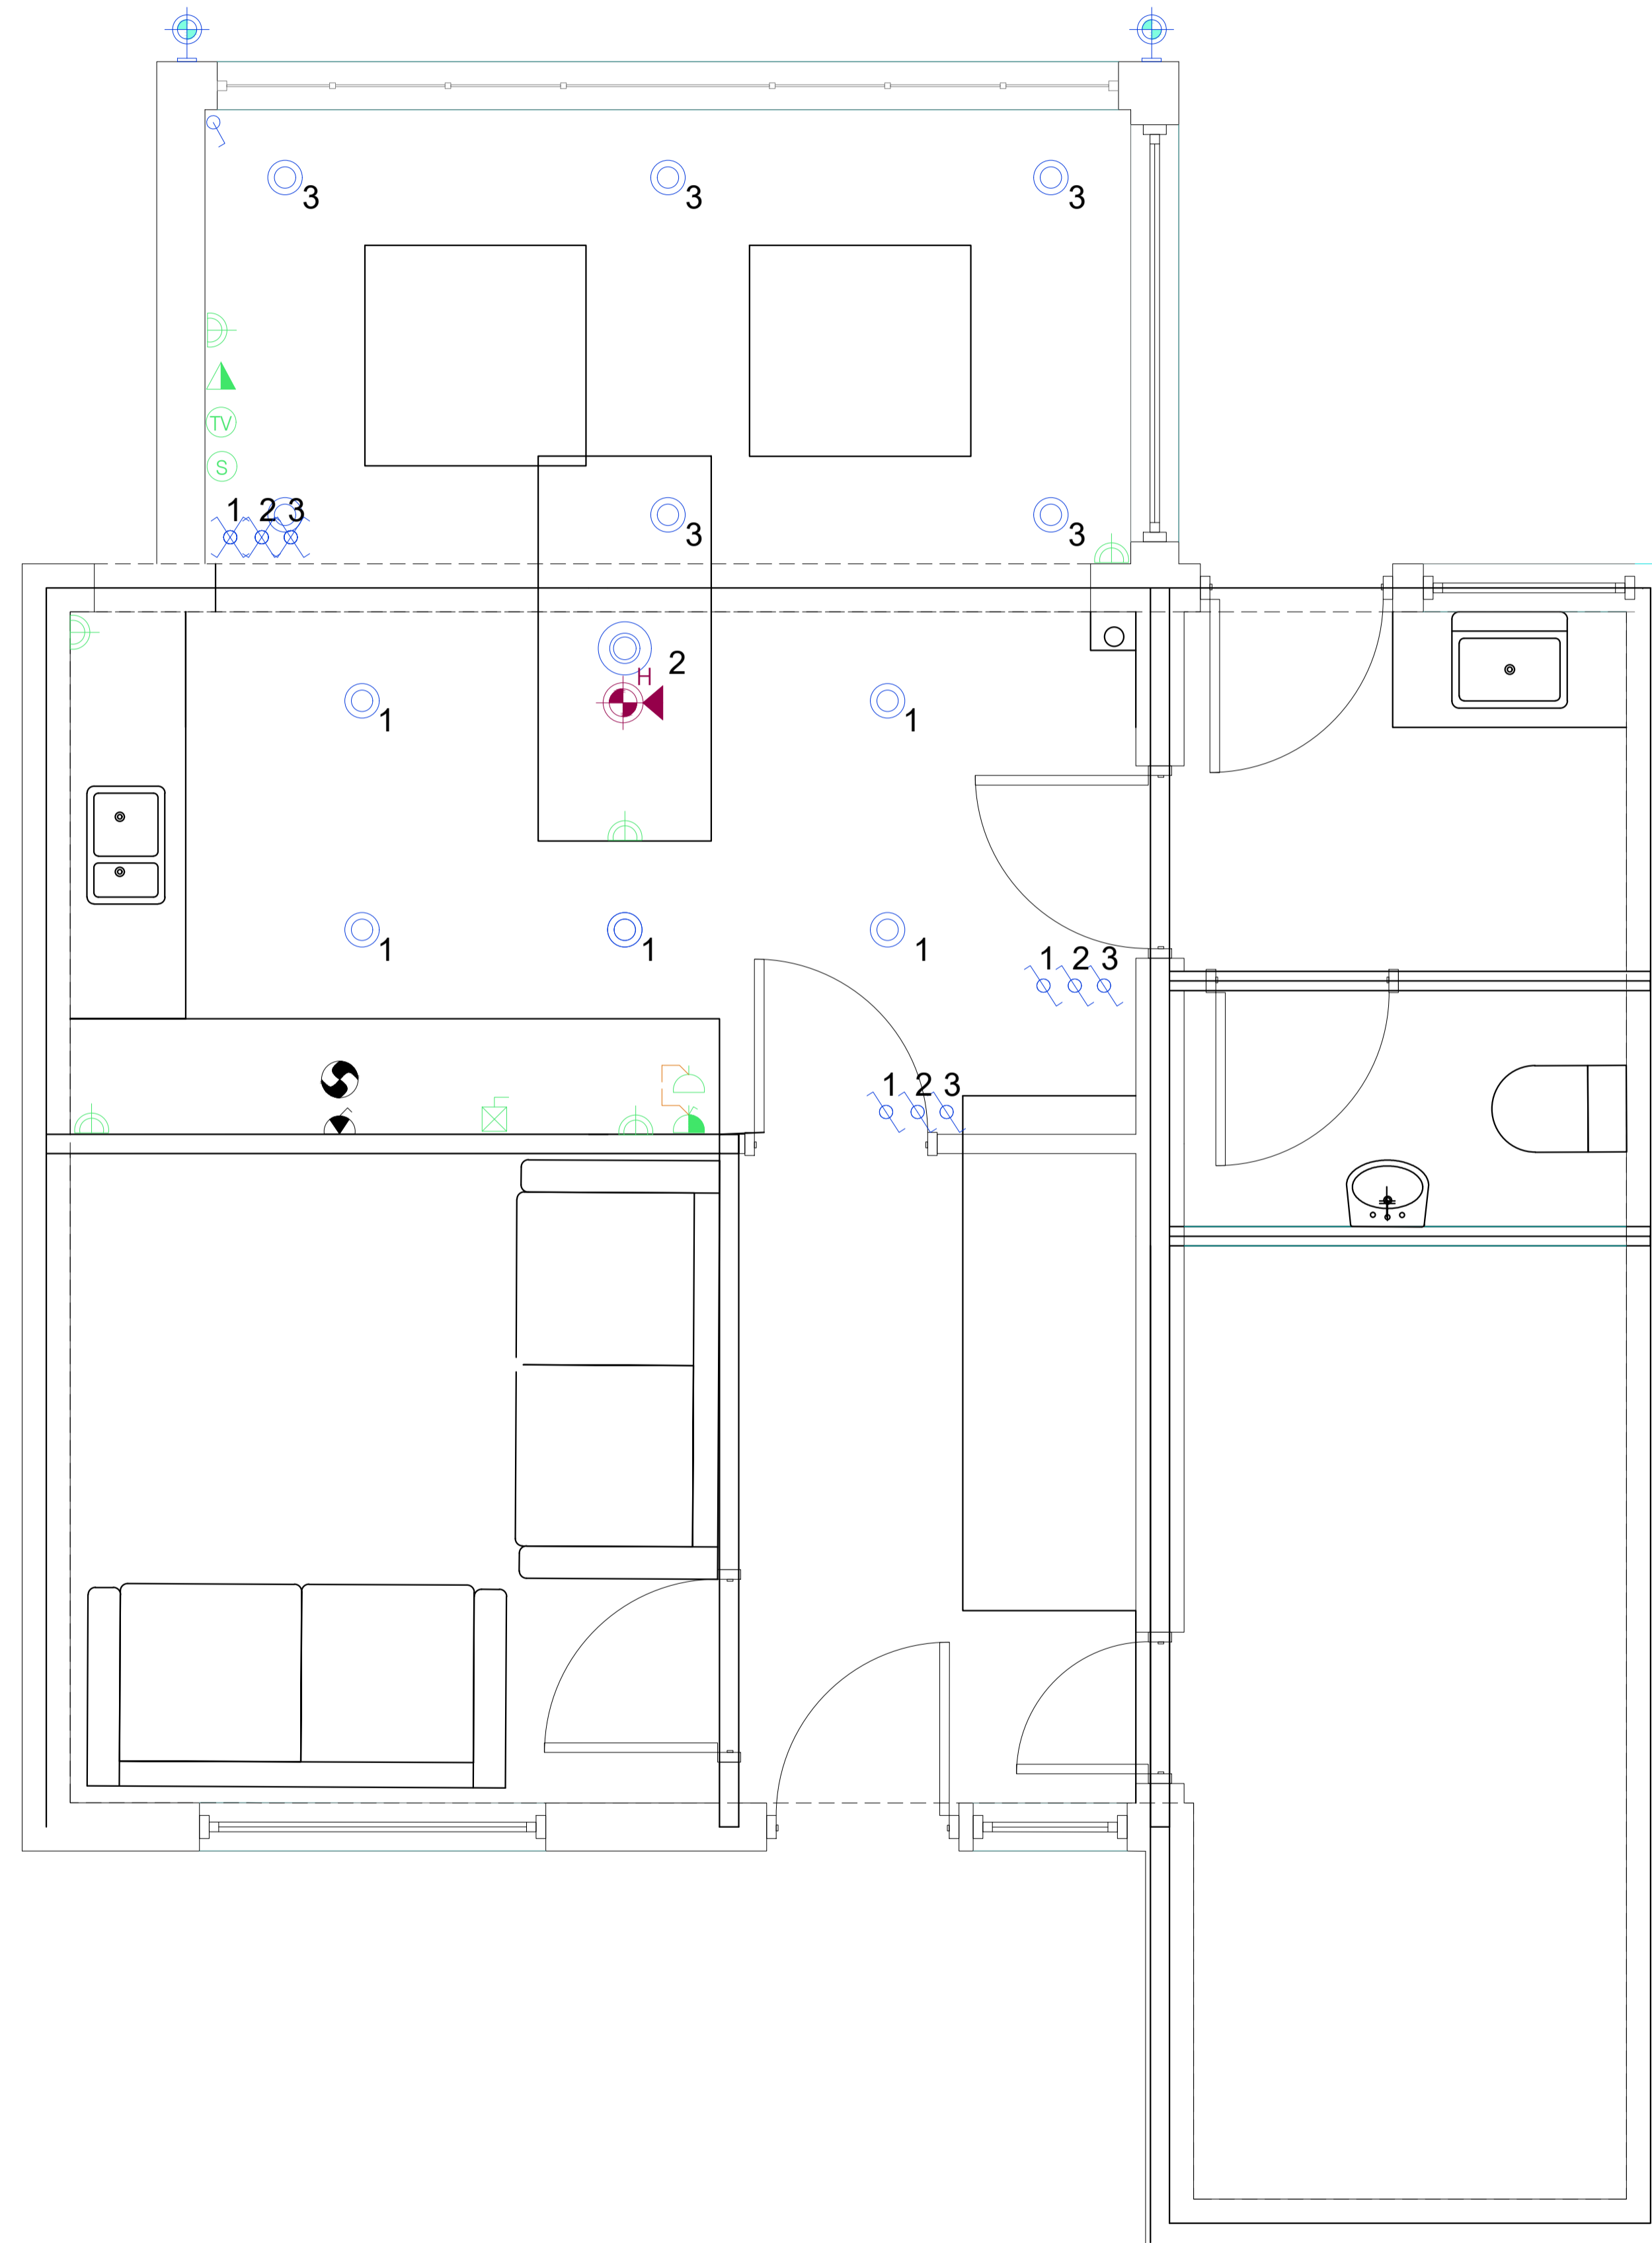

**ASTON REEF
CONSULTANT ENGINEERS**

30 Trevelan Close
St Austell
PL25 4UU

t: 01208 811153
e: enquires@astonreef.com
w: www.astonreef.com