
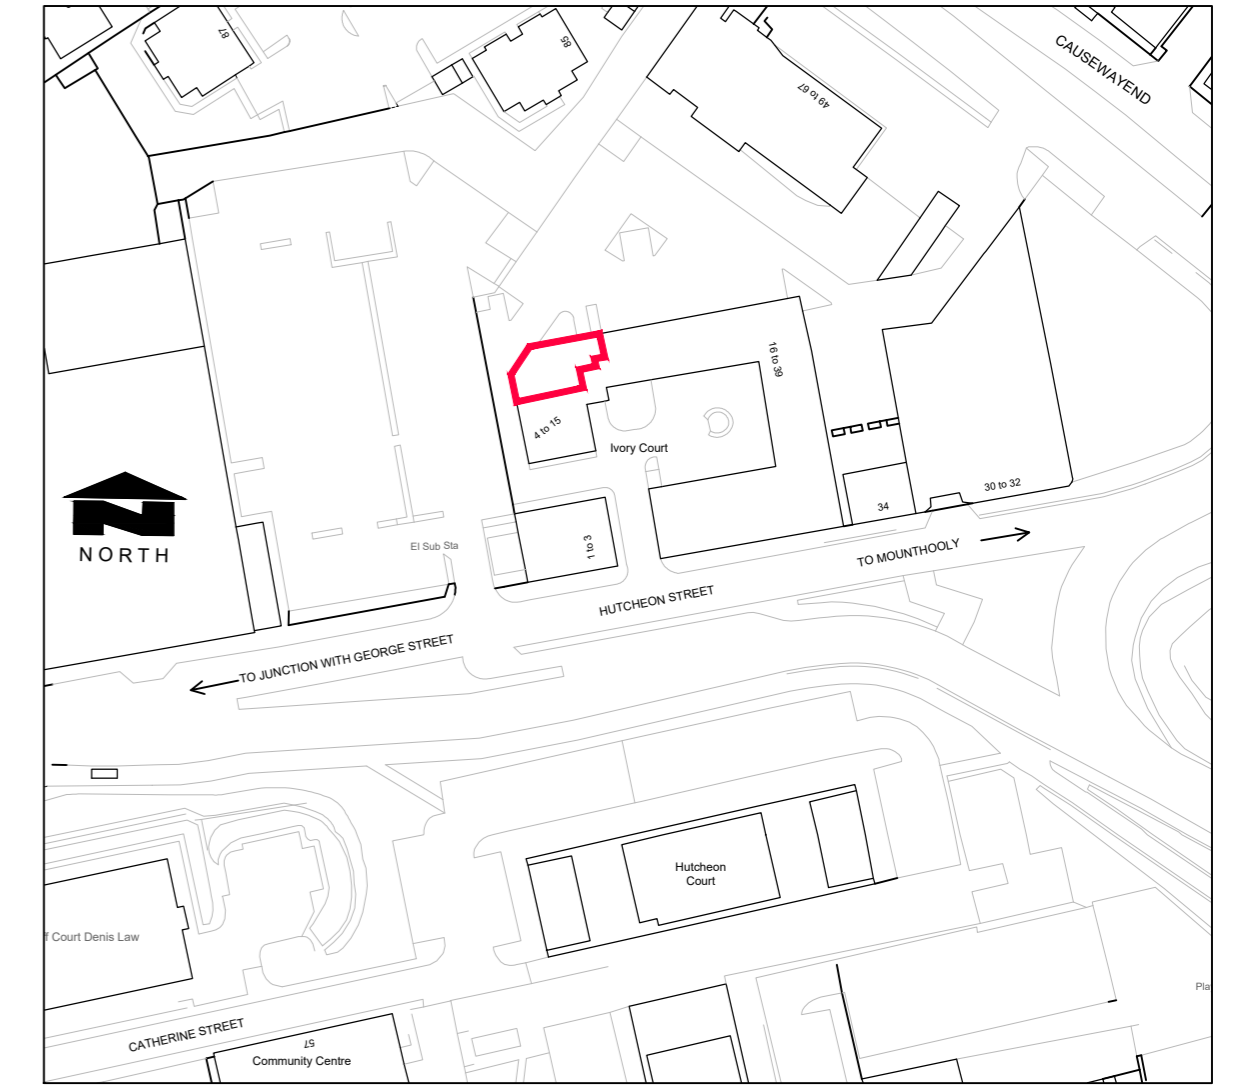
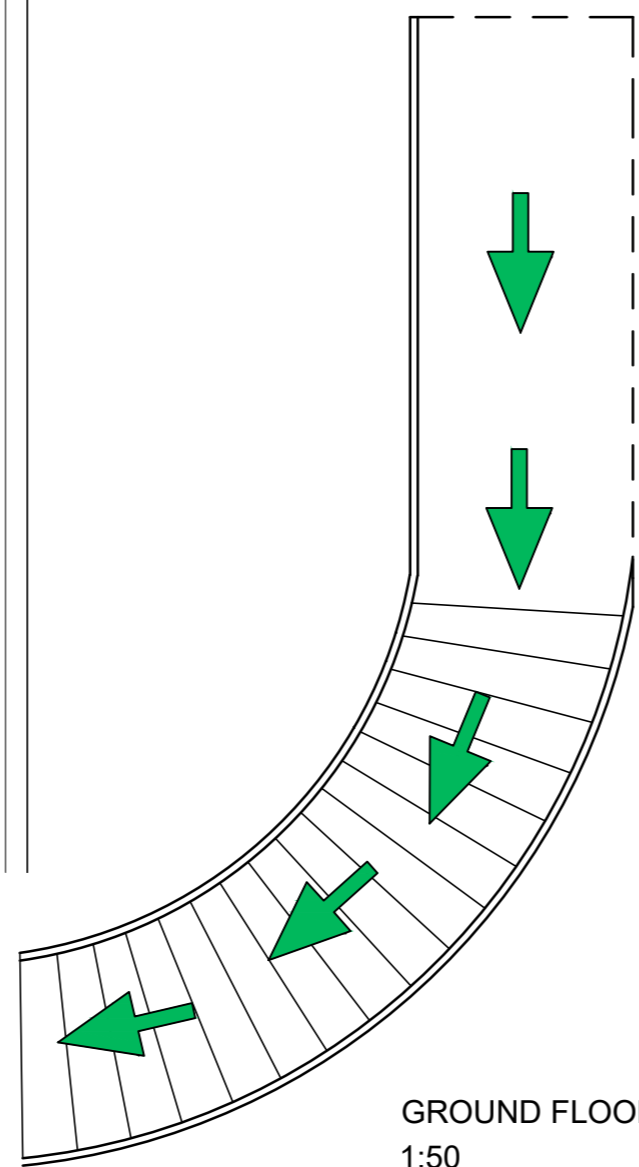
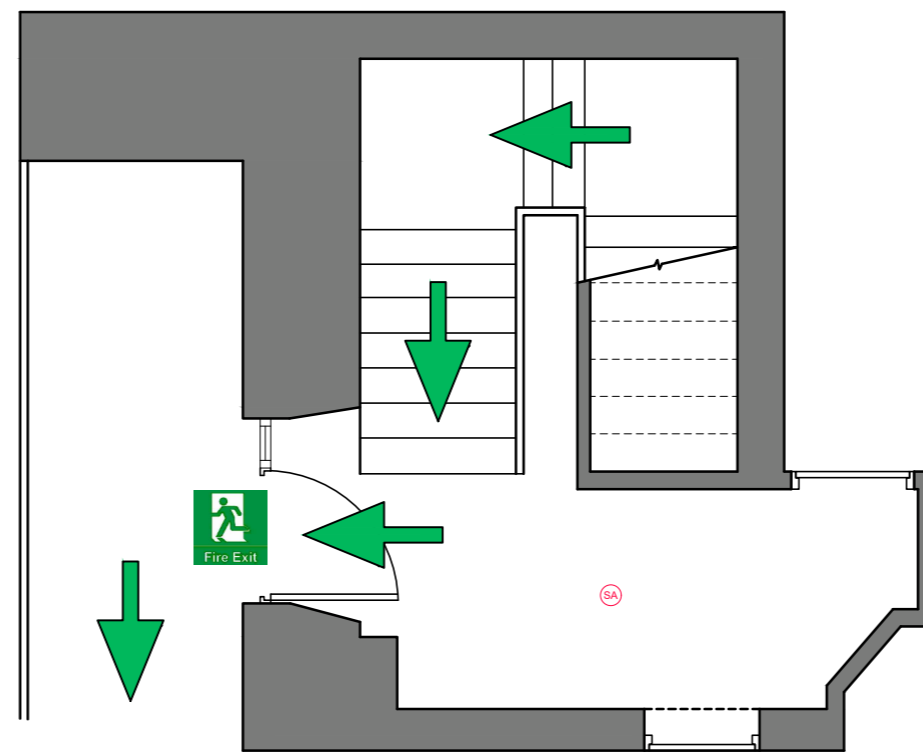


SECOND FLOOR PLAN
1:50

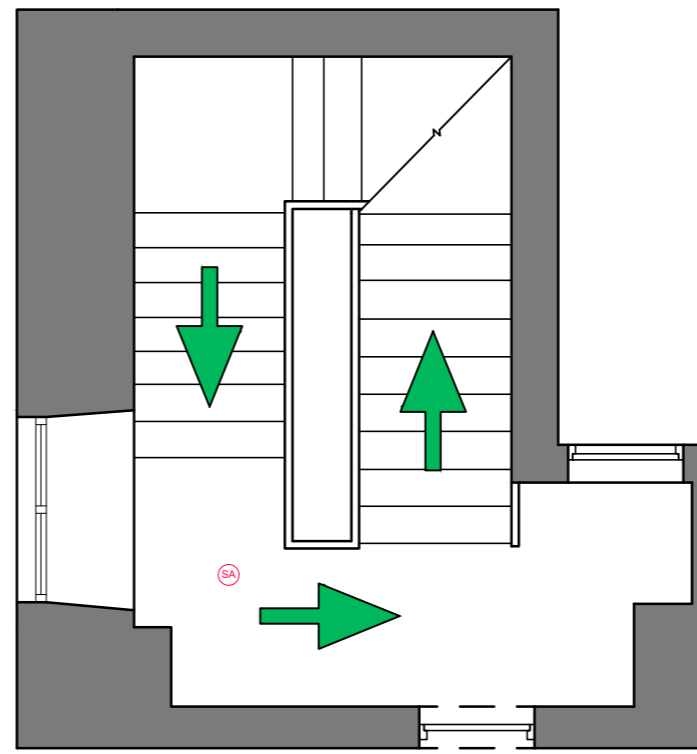

- ELECTRICAL SYMBOLS**
- ⊕ CARBON MONOXIDE DETECTOR
 - ⊙ HEAT DETECTOR
 - ⊙ SMOKE DETECTOR
 - ⊕ PENDANT LIGHT FITTING
 - ⊗ BATHROOM LIGHT FITTING
 - ⊙ SPOT LIGHT FITTING
 - LIGHT SWITCH
 - ⚡ 13A DOUBLE SOCKET
 - ▷ SHAVER SOCKET
- FIRE ESCAPE**
- 🚪 FIRE EXIT
 - ↓ DIRECTION OF TRAVEL

NOTES:

THESE DRAWINGS, & THE INFORMATION CONTAINED HEREIN, ARE FOR GENERAL PRESENTATION PURPOSES FOR THE APPLICATION OF A SHORT TERM LICENSE FOR 12 IVORY COURT, ABERDEEN, AB25 3TD. THESE DRAWINGS ARE NOT INTENDED, & SHOULD NOT BE USED FOR ANY OTHER PURPOSE. THE INFORMATION CONTAINED WITHIN THIS DRAWING IS COPYRIGHTED TO COOPER & MACGREGOR LTD, ANY REPRODUCTION IN PART, OR AS A WHOLE, IS PROHIBITED.

THIS DRAWING IS TO BE READ IN CONJUNCTION WITH ALL OTHER RELEVANT DRAWINGS, SPECIFICATIONS & PROJECT INFORMATION.

DO NOT SCALE OFF THIS DRAWING. ANY DISCREPANCIES ARE TO BE BROUGHT TO THE IMMEDIATE ATTENTION OF COOPER & MACGREGOR LTD.

Cooper & MacGregor Ltd
Chartered Architect

01224 323839
mail@coopmac.scot
www.coopmac.scot

86 Summerhill Crescent, Aberdeen, AB15 6ED
Registered in Scotland, Company No: SC562315, Directors: Angela Cooper & Robert MacGregor

PROJECT: SHORT TERM LET APPLICATION
ADDRESS: 12 IVORY COURT, ABERDEEN, AB25 3TD

DWG TITLE: SHORT TERM LET FLOOR PLAN.

SCALE: AS SHOWN @ A2 DWG NO: 157-301 REV: A