



- LEGEND (PLAN):**
- HIGHWAY BOUNDARY LIMITS
 - MAJOR CONTOUR - 0.1m INTERVALS
 - MINOR CONTOUR - 0.025m INTERVALS
 - CURRENT PLANNING APPLICATION BOUNDARY
 - PLANNING PERMISSION BOUNDARY 20/2481/EIS 11 JUNE 2021
- LEGEND (PROFILE):**
- EXISTING GROUND LEVEL
 - PROPOSED GROUND LEVEL

- NOTES:**
- ALL DIMENSIONS ARE IN METERS UNLESS OTHERWISE STATED.
 - DO NOT SCALE FROM DRAWING, USE FIGURED DIMENSIONS ONLY.
 - VERTICAL PROFILE CURVES AND GRADIENTS ARE IN ACCORDANCE WITH THE COUNCIL DESIGN GUIDE AND SPECIFICATION.
 - REFER TO DRAWING NO: STO-ARC-XX-XX-DR-CE-5101 FOR GENERAL ARRANGEMENT DETAILS.
 - REFER TO DRAWING NO'S: STO-ARC-XX-XX-DR-CE-5106 TO 5113 FOR CROSS SECTIONS.
 - REFER TO DRAWING STO-ARC-XX-XX-DR-CE-5500 FOR HIGHWAY DRAINAGE LAYOUT.
 - SPECIFICATION TO BE THE STOCKTON BOROUGH COUNCIL HIGHWAYS DESIGN GUIDE. SPECIFIC ATTENTION IS DRAWN TO THE CONSTRUCTION (DESIGN AND MANAGEMENT) REGULATIONS 2007 DEFINED WITHIN THE STATUTORY REQUIREMENTS CHAPTER.

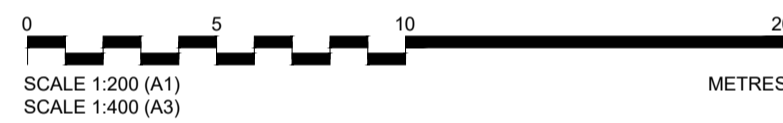


PLAN - SCALE 1:200

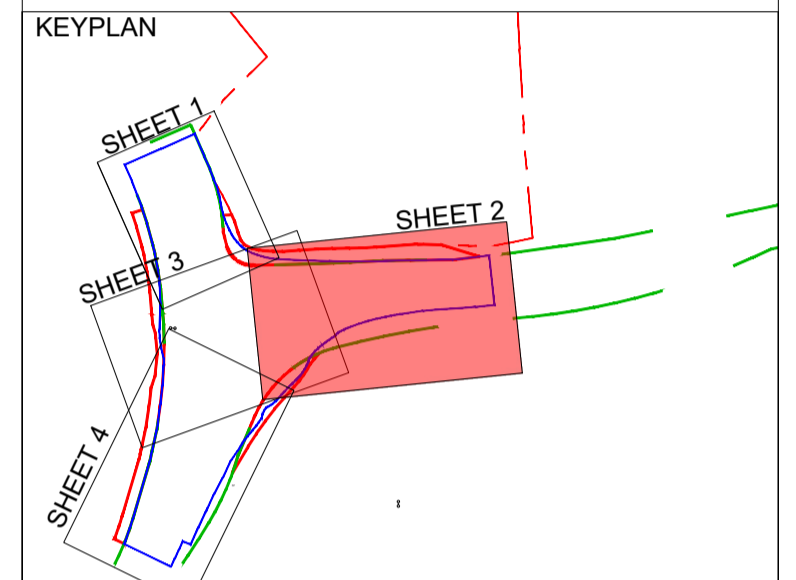



| Rev | Date | Description | Drawn | Check | Approv |
|-----|----------|-----------------------------|-------|-------|--------|
| P03 | 11/12/23 | BOUNDARIES & CLIENT UPDATED | DD | DO | MD |
| P02 | 26/07/22 | NOTE ADDED | LR | DO | MD |
| P01 | 08/10/21 | FIRST ISSUE | AW | DO | MD |

LONG SECTION - SCALE 1:200 H 1:20 V

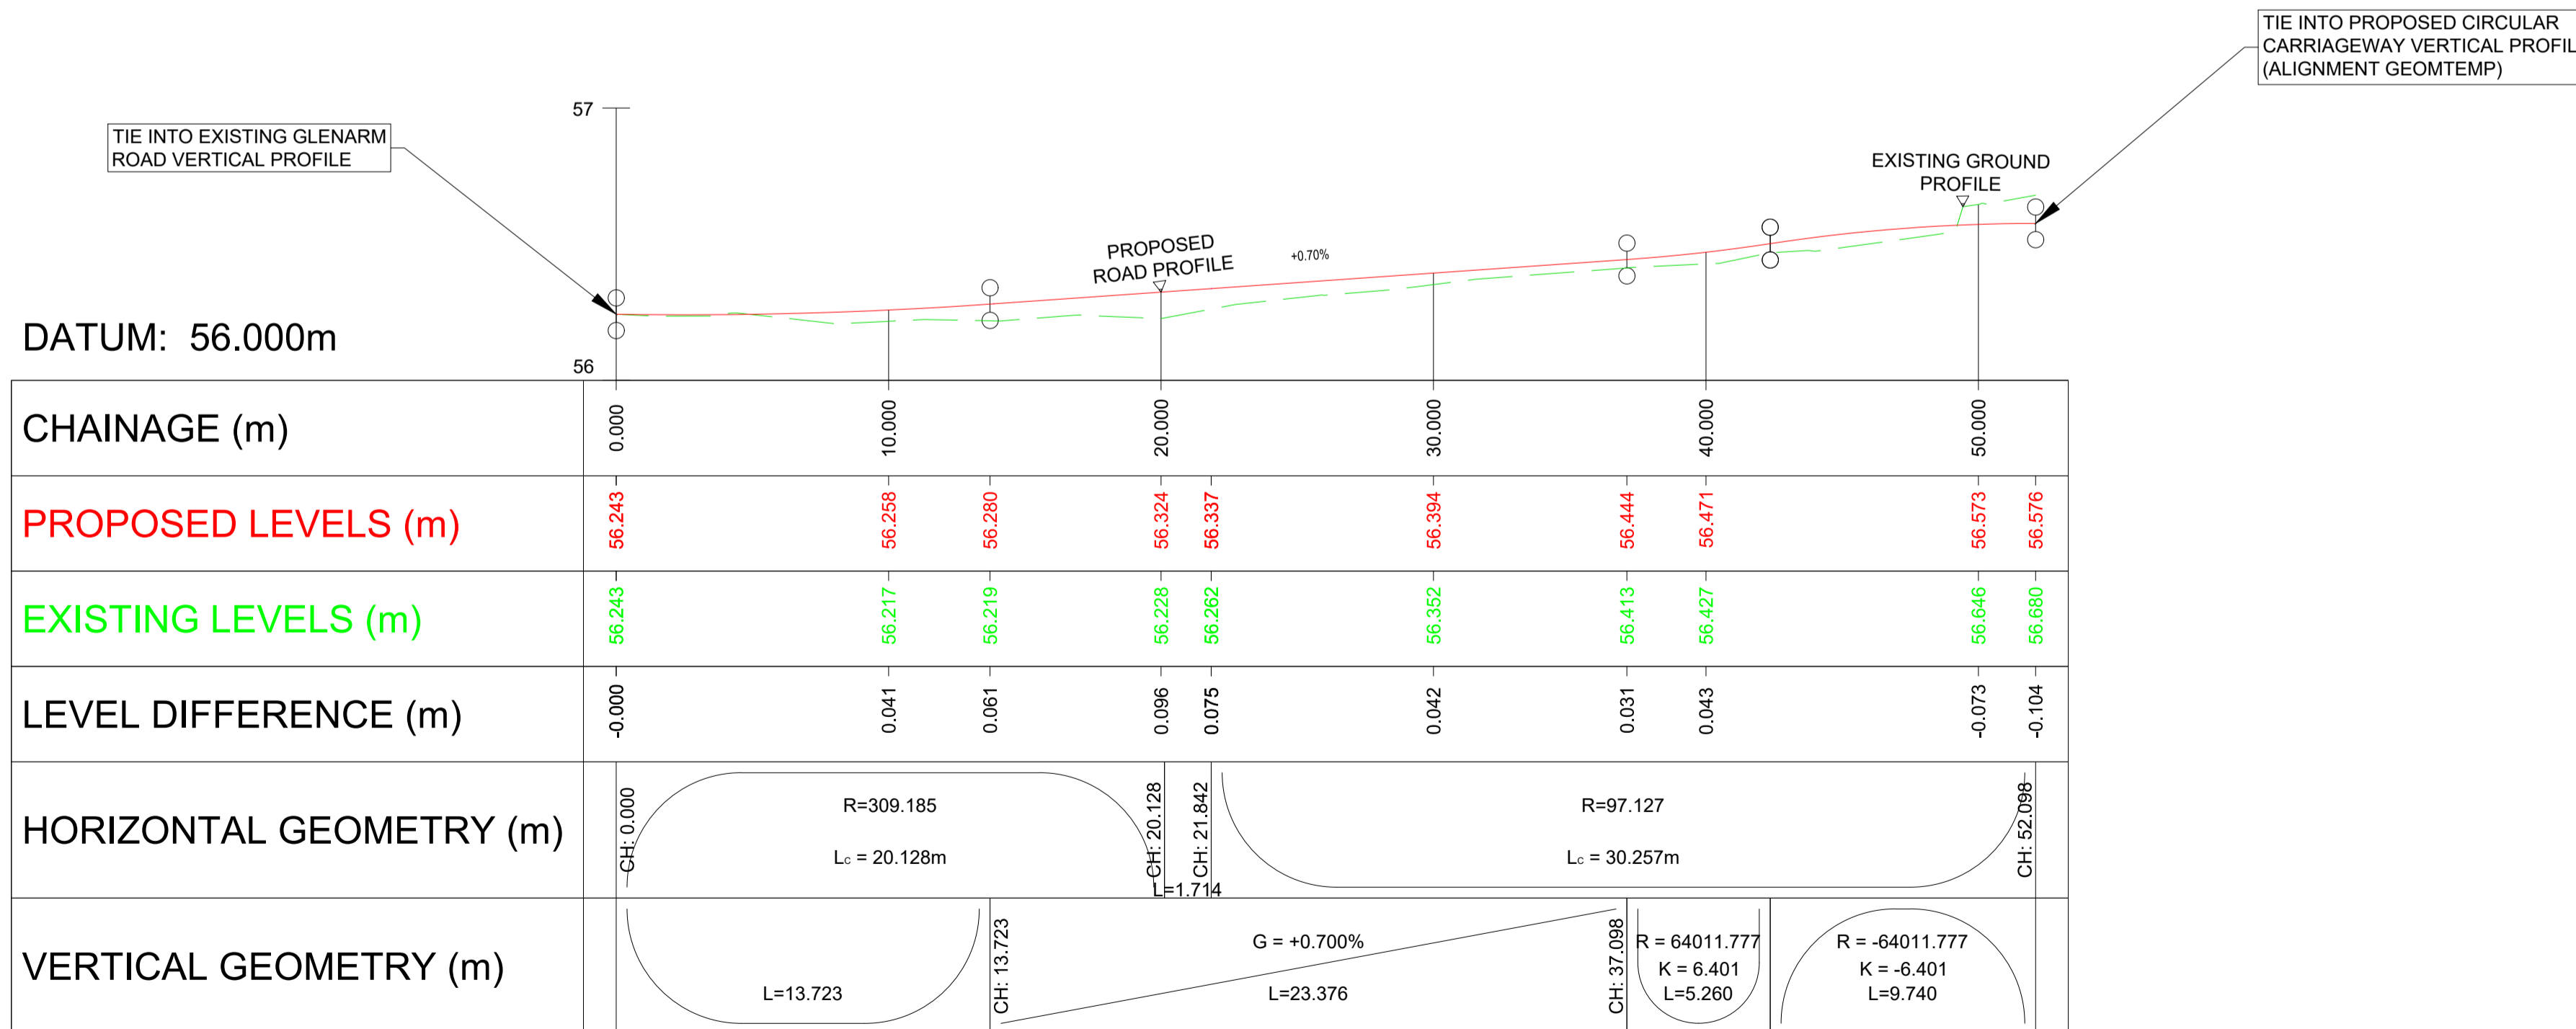

ALIG-GEOMBL2

  SCALE: H 1:200. V 1:20. DATUM: 56.000



Client
Amazon UK Services LTD

PROJECT:
STOCKTON

Site
Chapel Lane North
Stockton-on-Tees

Client
Amazon UK Services Ltd

ARCADIS Design & Consultancy for technical and built assets

Registered office:
Arcadis House
34 York Way
London
N1 9AB

Coordinating office:
2 Glass Wharf
Temple Quay
Bristol BS2 0FR
Tel: +44 (0)11 7372 1200

www.arcadis.com

TITLE:
STOCKTON
HANZARD DRIVE / GLENARM
ROAD ROUNDABOUT
PLAN AND PROFILE
SHEET 2 OF 4

| Designed | M.Colin | Signed | Date |
|-------------------|--------------|-----------------|------------|
| Drawn | A.Wilczynska | Signed | 08/10/2021 |
| Checked | D.Ogden | Signed | 08/10/2021 |
| Approved | M.Davies | Signed | 08/10/2021 |
| Scale: | AS SHOWN | Datum: | OSGB 1936 |
| Original Size: | A1 | Grid: | OSGB 1936 |
| Suitability Code: | S0 | Project Number: | 10042440 |

Suitability Description:
**PRELIMINARY
NOT TO BE USED FOR CONSTRUCTION**

Drawing Number:
STO-ARC-XX-XX-DR-CE-5103

Revision:
P03