


- LEGEND (PLAN):**
- HIGHWAY BOUNDARY LIMITS
 - MAJOR CONTOUR - 0.1m INTERVALS
 - MINOR CONTOUR - 0.025m INTERVALS
 - CURRENT PLANNING APPLICATION BOUNDARY
 - PLANNING PERMISSION BOUNDARY 20/2481/EIS 11 JUNE 2021
- LEGEND (PROFILE):**
- EXISTING GROUND LEVEL
 - PROPOSED GROUND LEVEL




- NOTES:**
- ALL DIMENSIONS ARE IN METRES UNLESS OTHERWISE STATED.
 - DO NOT SCALE FROM DRAWING, USE FIGURED DIMENSIONS ONLY.
 - VERTICAL PROFILE CURVES AND GRADIENTS ARE IN ACCORDANCE WITH THE COUNCIL DESIGN GUIDE AND SPECIFICATION.
 - REFER TO DRAWING NO: STO-ARC-XX-XX-DR-CE-5101 FOR GENERAL ARRANGEMENT DETAILS.
 - REFER TO DRAWING NO'S: STO-ARC-XX-XX-DR-CE-5106 TO 5113 FOR CROSS SECTIONS.
 - REFER TO DRAWING STO-ARC-XX-XX-DR-CE-5500 FOR HIGHWAY DRAINAGE LAYOUT.
 - SPECIFICATION TO BE THE STOCKTON BOROUGH COUNCIL HIGHWAYS DESIGN GUIDE. SPECIFIC ATTENTION IS DRAWN TO THE CONSTRUCTION (DESIGN AND MANAGEMENT) REGULATIONS 2007 DEFINED WITHIN THE STATUTORY REQUIREMENTS CHAPTER.

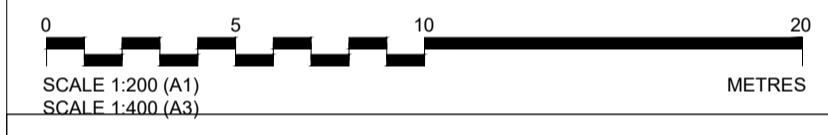

P04	11/12/23	BOUNDARIES & CLIENT UPDATED	DD	DO	MD
P03	26/07/22	NOTE ADDED	LR	DO	MD
P02	27/10/21	WEST SHARED-USE PATH ADDED	AW	DO	MD
P01	08/10/21	FIRST ISSUE	AW	DO	MD
Rev	Date	Description	Drawn	Check	Approv



PLAN - SCALE 1:200

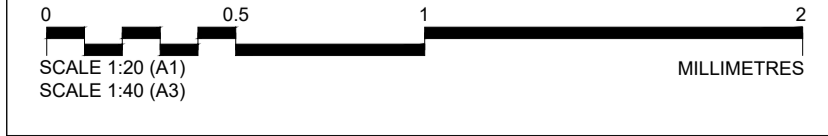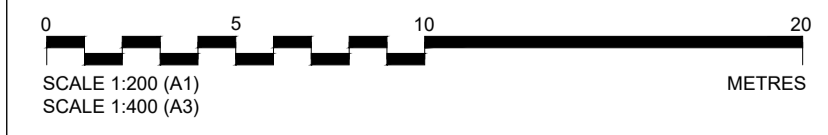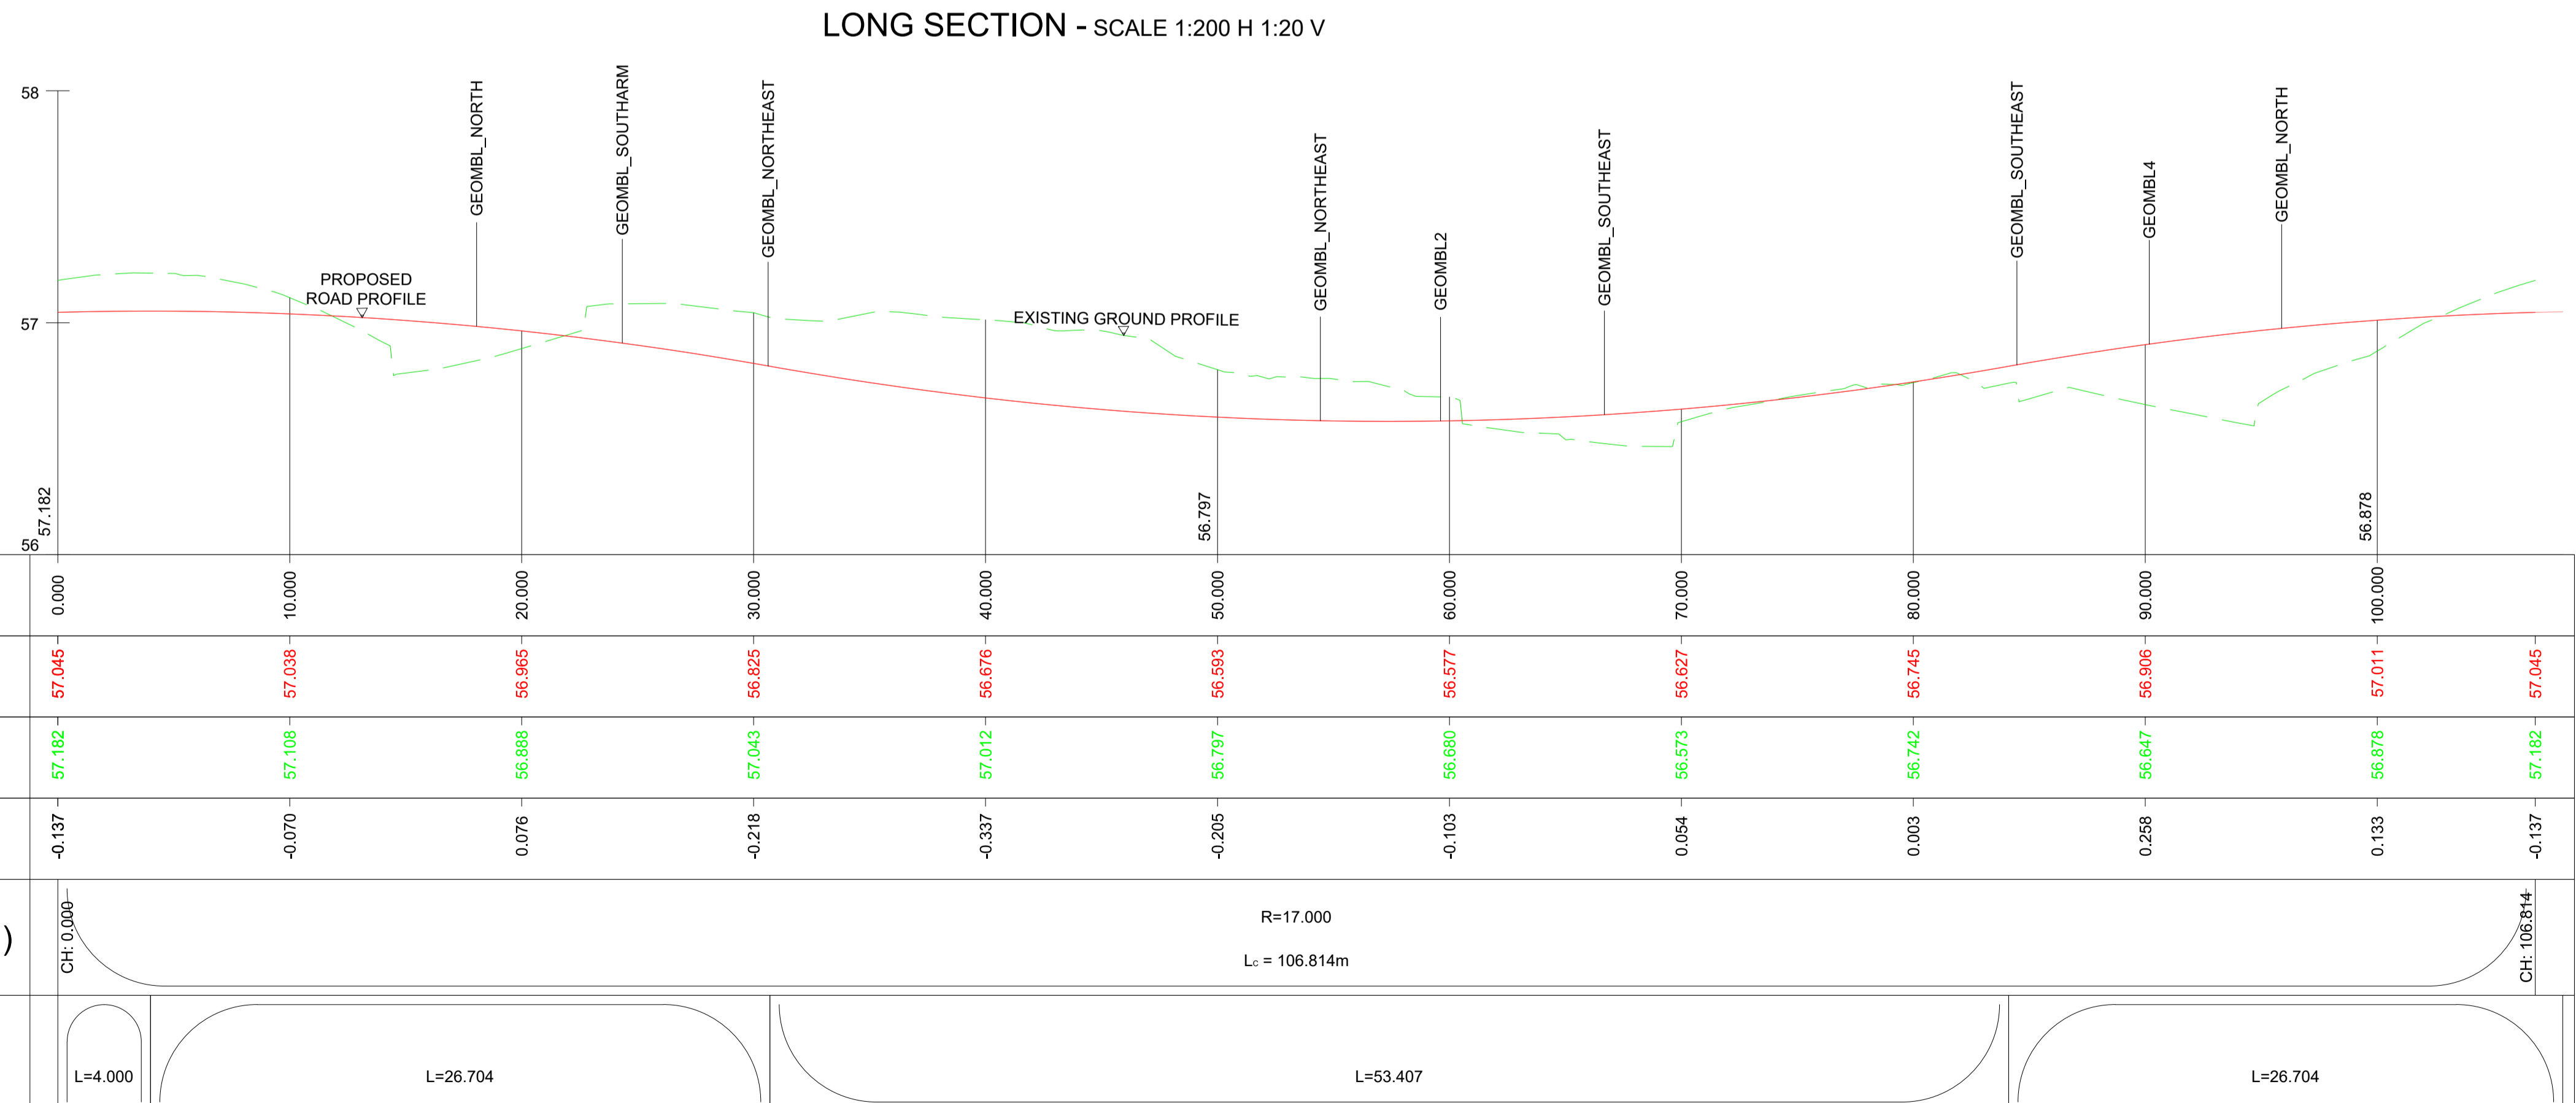

ALIG-GEOMTMP

SCALE: H 1:200. V 1:20. DATUM: 56.000

Client
Amazon UK Services LTD

PROJECT:
STOCKTON

Site	Client
Chapel Lane North Stockton-on-Tees	Amazon UK Services Ltd

ARCADIS Design & Consultancy
 Registered office: Arcadis House, 34 York Way, London N1 9AB
 Coordinating office: 2 Glass Wharf, Temple Quay, Bristol BS2 0FR
 Tel: +44 (0)11 7372 1200
 www.arcadis.com

TITLE: STOCKTON HANZARD DRIVE / GLENARM ROAD ROUNDABOUT
PLAN AND PROFILE SHEET 3 OF 4

Designed	M.Colin	Signed		Date	27/10/2021
Drawn	A.Wilczynska	Signed		Date	27/10/2021
Checked	D.Ogden	Signed		Date	27/10/2021
Approved	M.Davies	Signed		Date	27/10/2021
Scale:	AS SHOWN	Datum:	OSGB 1936		
Original Size:	A1	Grid:	OSGB 1936		
Suitability Code:	S0	Project Number:	10042440		

Suitability Description: PRELIMINARY NOT TO BE USED FOR CONSTRUCTION

Drawing Number:	STO-ARC-XX-XX-DR-CE-5104	Revision:	P04
-----------------	--------------------------	-----------	-----