




GROUND FLOOR PLAN

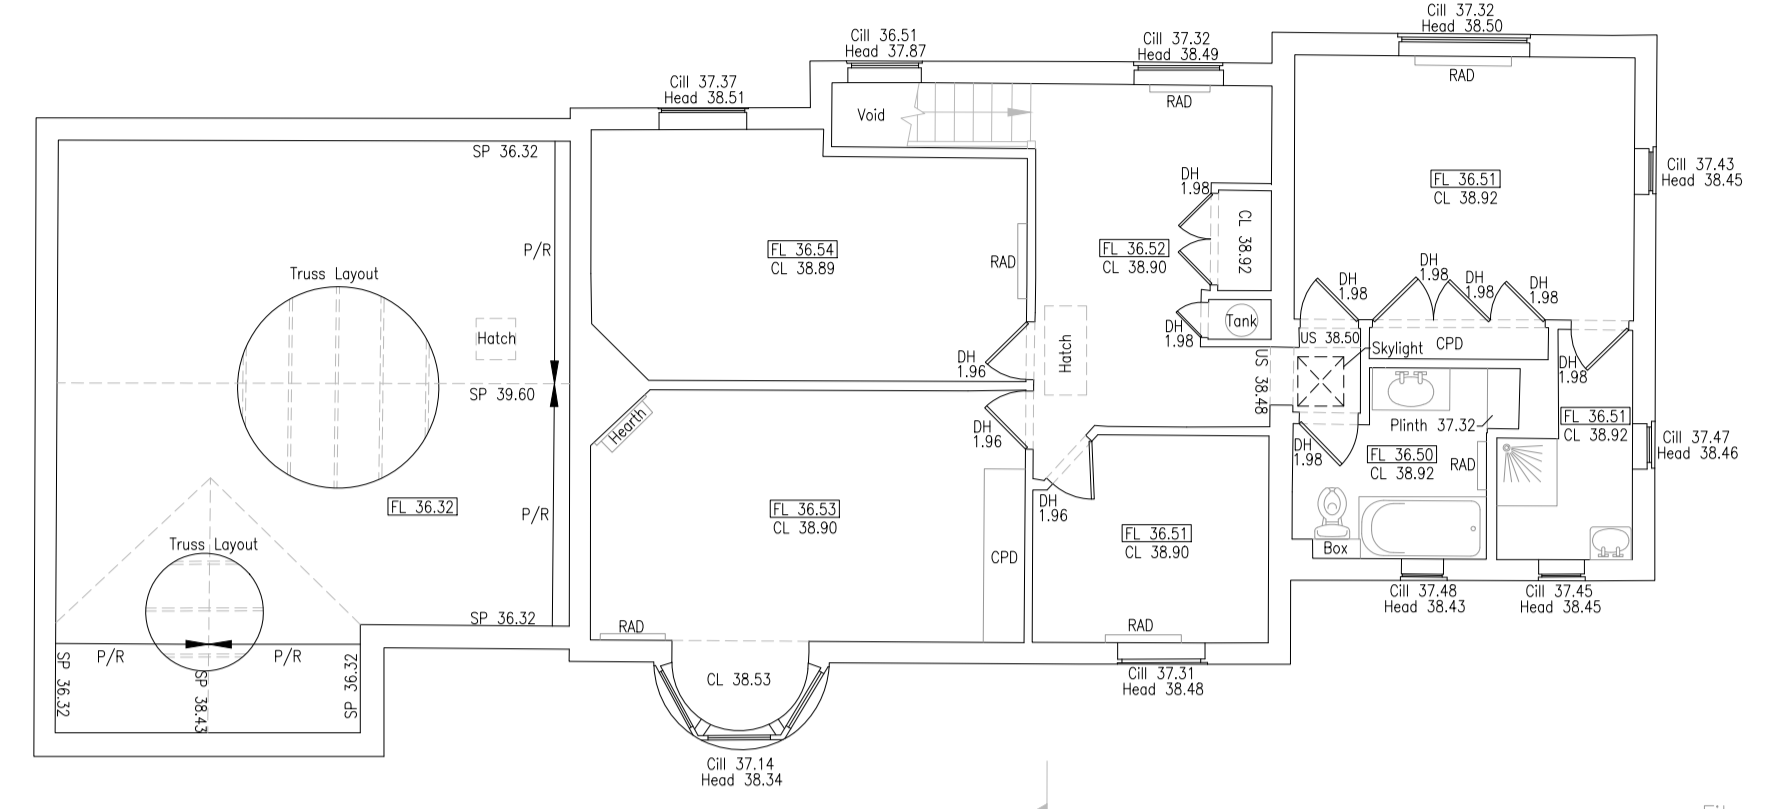


FIRST FLOOR PLAN

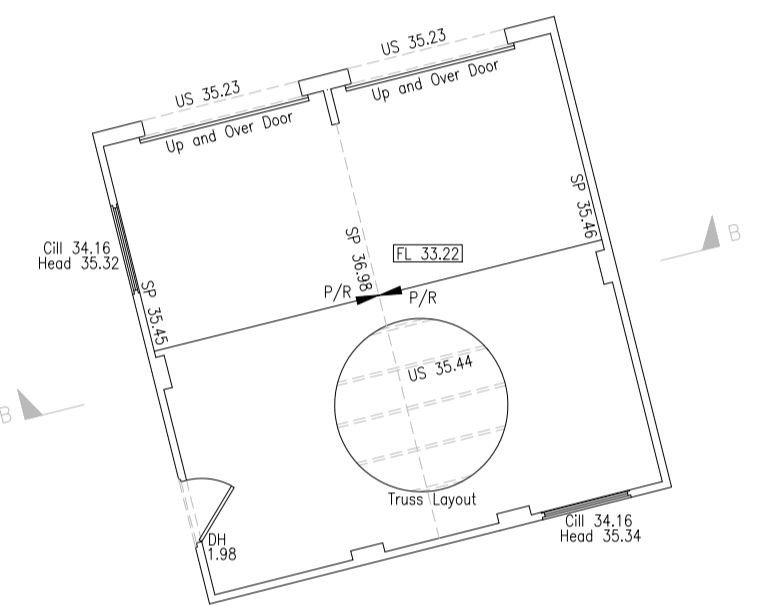



GROUND FLOOR PLAN

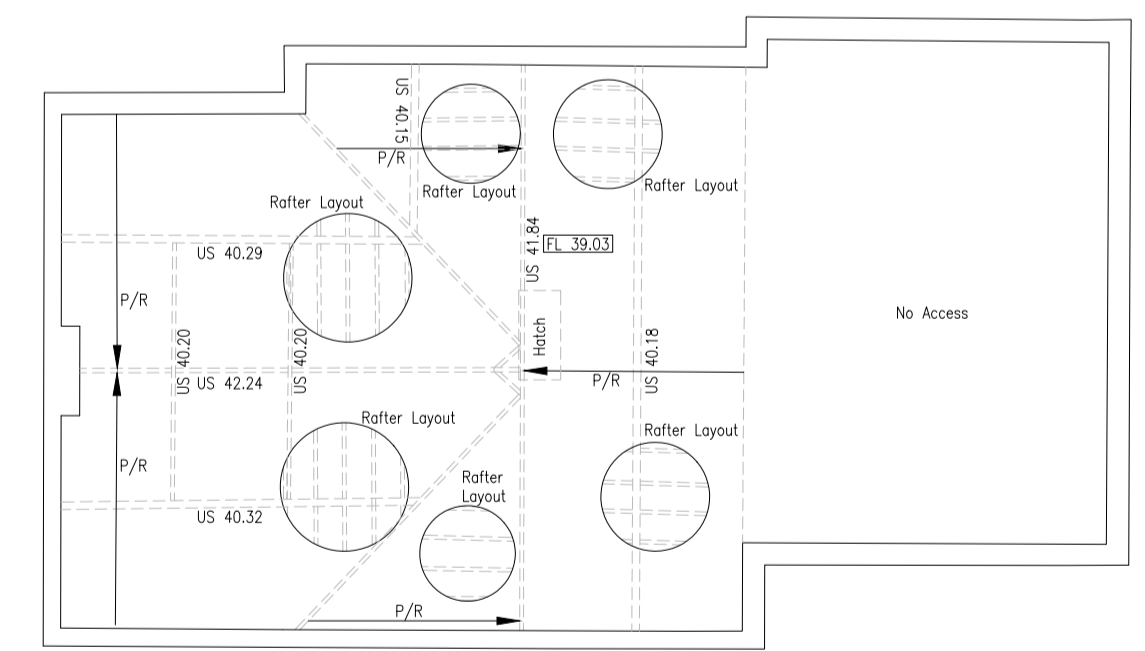

ATTIC PLAN

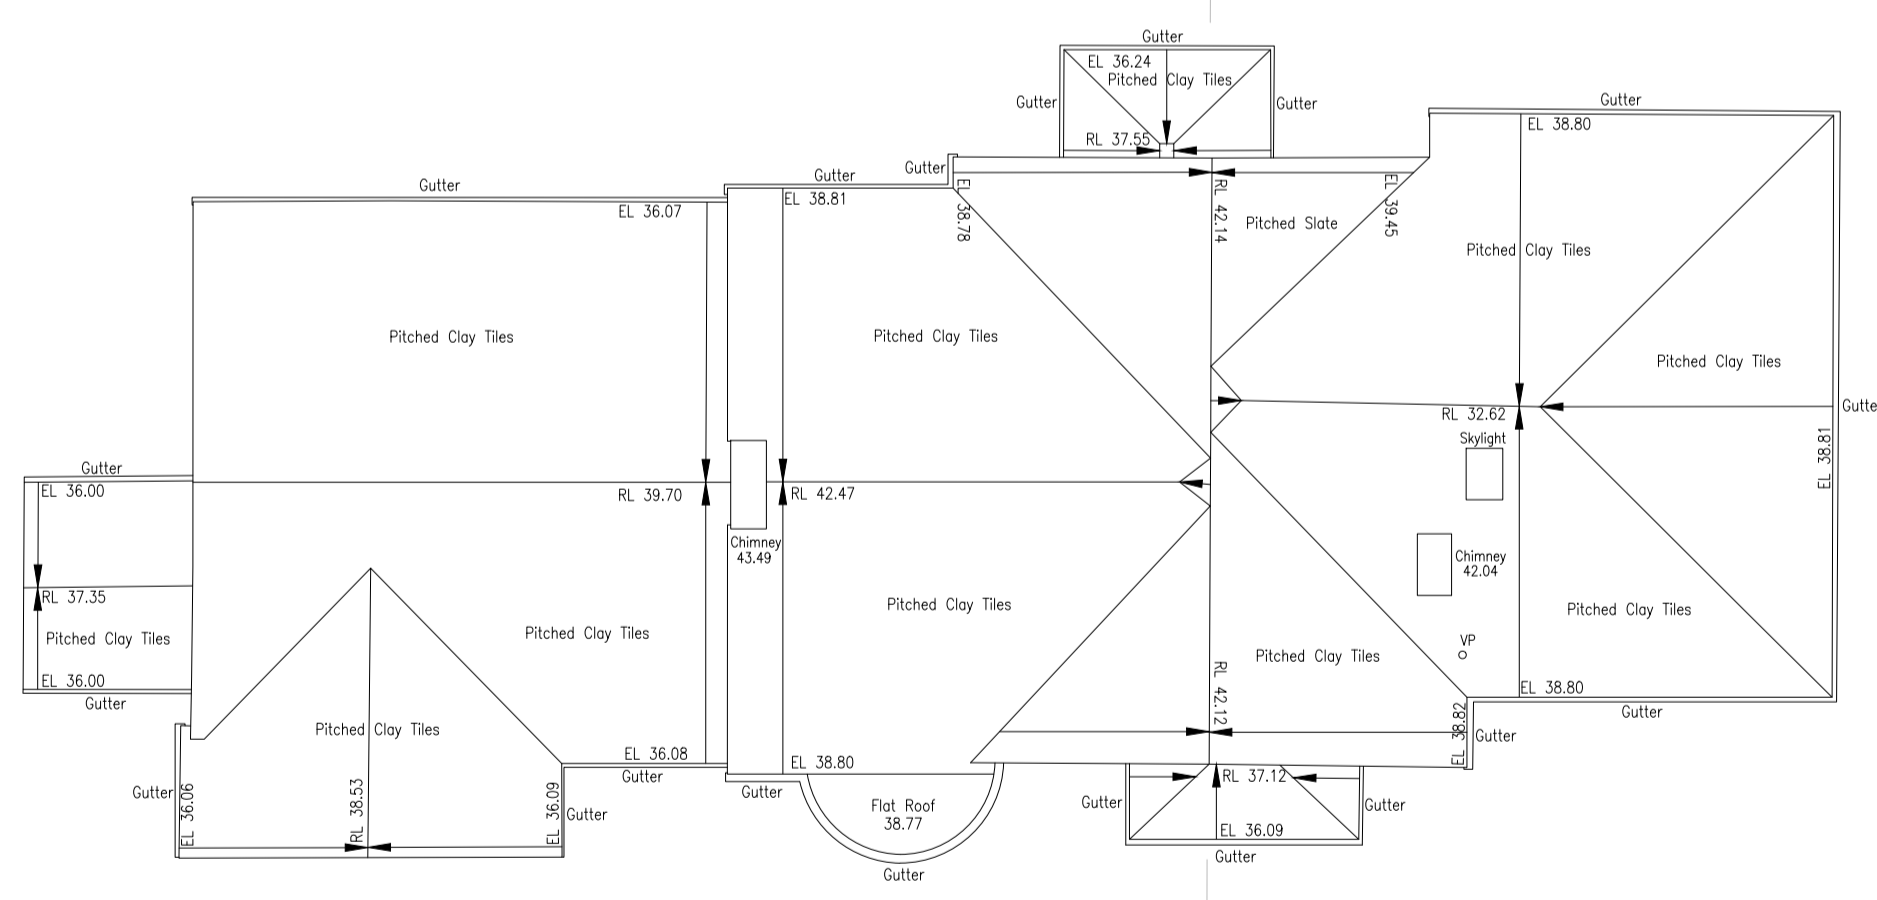

ROOF PLAN

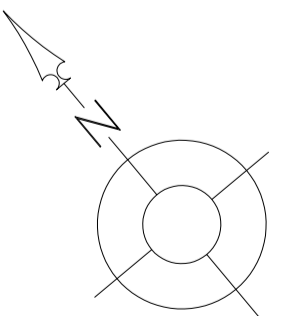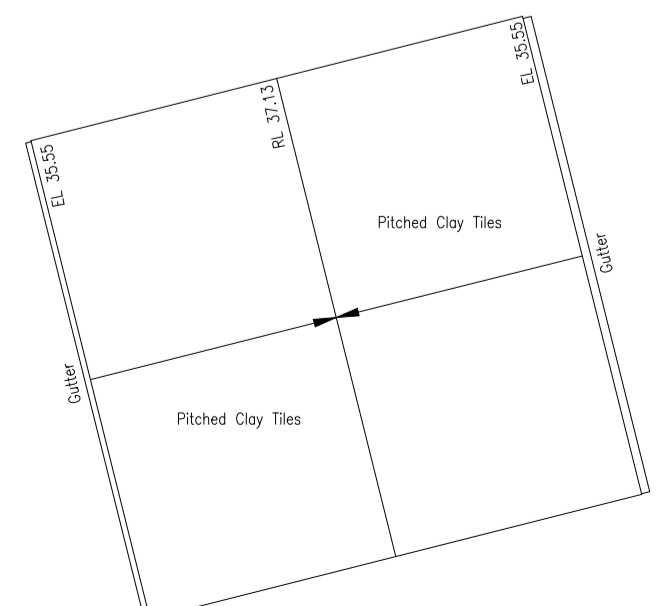


**Legend:**

Abbreviated Features:	Symbols:	Symbols:
AB Air Brick	LI Light	Radiator
B Balcony	O/F Overflow Pipe	Light
C/R Clear Boarded	P/C Pitched Ceiling	Emergency Light
C-H Cill to Head	PE Pipe	Strip Light
C/L Chain Link	P/R Pitched Roof	Wall Mounted Light
CL Ceiling Level	P/W Plumb & Wire	Mains Point
CPD Cupboard	R/R Radiator	Blank Plate
CR Crown Point Level	RWP Radiator Pipe	Light Switch
DH Door Height	RD Roofing Edge	Pendant Switch
Dr Drain	RWP Radiator Pipe	Isolator Switch
FE Fire Exit	SD Sliding Doors	Alarm Bell
F-C Floor to Cill	SS Suspended Ceiling Level	Fire Alarm Push
FL Floor Level	SP Spring Point Level	Smoke Detector
FW Four Water	SP Soil & Vent Pipe	Alarm Panel
MH Manhole	SW Surface Water	Thermofast
C Gully	US Underdrain	Modes
I Inspection Chamber	UL Underdrain to Lift	Alarm Panel
I Invert Level	VP Vent Pipe	Thermofast
I/R Iron Rappings	VI Vent	Modes
		Electric Box
		Hector
		Water Stop Tap
		Overhead Features

Plan Coordinate Control:-  
N/A

Level Datum:-  
All Levels relate to OSGB36 using GPS

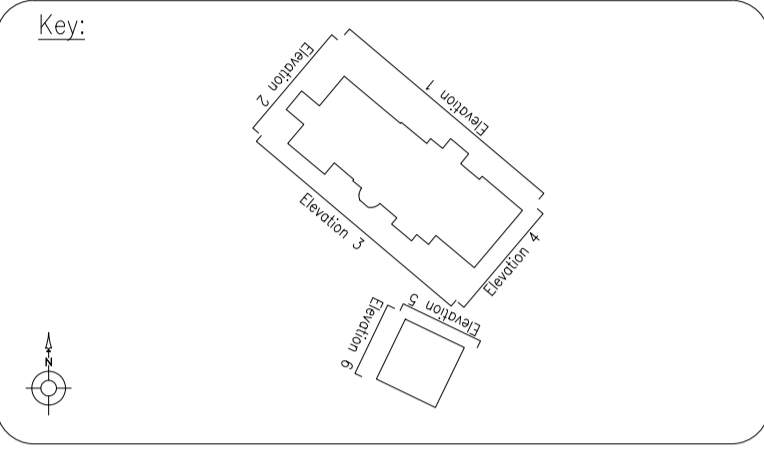

**Notes:**

REV NO REV NOTE DATE SIGNED

3 Brookfield, Duncan Close,  
 Moulton Park, Northampton, NN3 6WL  
 Tel: 01604 491543  
 Email: info@globalsurveys.co.uk

Site: 12 Herne Road  
 Oundle  
 PE8 4BS  
 Client: Laura Oughton  
 Survey Title: Measured Building Survey  
 Ground, First, Attic & Roof Plans

Date	November 2022	Scale	1/100 @ A1
Dwg No.	22587-MBS	Surveyor	GD
Sheet	1 of 2	Checked	SPH