



William Blyth Airvent Pantile


William Blyth
 Hoe Hill, Barton-Upon-Humber, North Lincolnshire DN18 5RB
 Tel: 01652 632175 Fax: 01226 700350

Air Vent Data Sheet

Minimum Roof Pitch 30°
 Head lap minimum 75 mm
 Batten spacing 267 mm
 Size of tile 343 x 241 mm
 Profile Depth 60 mm
 Hanging length 310 mm
 Batten size up to 450mm rafter centres: 38mm x 25mm up to 600mm rafter centres: 50mm x 25mm
 Nail size / type 38 mm x 2.65 mm aluminium clout nails
 Air Flow of Eyelid: 13600mm²
 *Please note, due to the handmade nature of our products, all sizes are approximate.

"Barco" Old English Handmade Pantiles
 William Blyth is a trading division of Gordon Harrison Ltd
 Head Office: Monckton Manor, Chevet Lane, Notton, Wakefield WF4 2PD
 Email: enquiries@williamblyth.co.uk Website: www.williamblyth.co.uk

New extract vent from Ensuite to terminate to tile vent

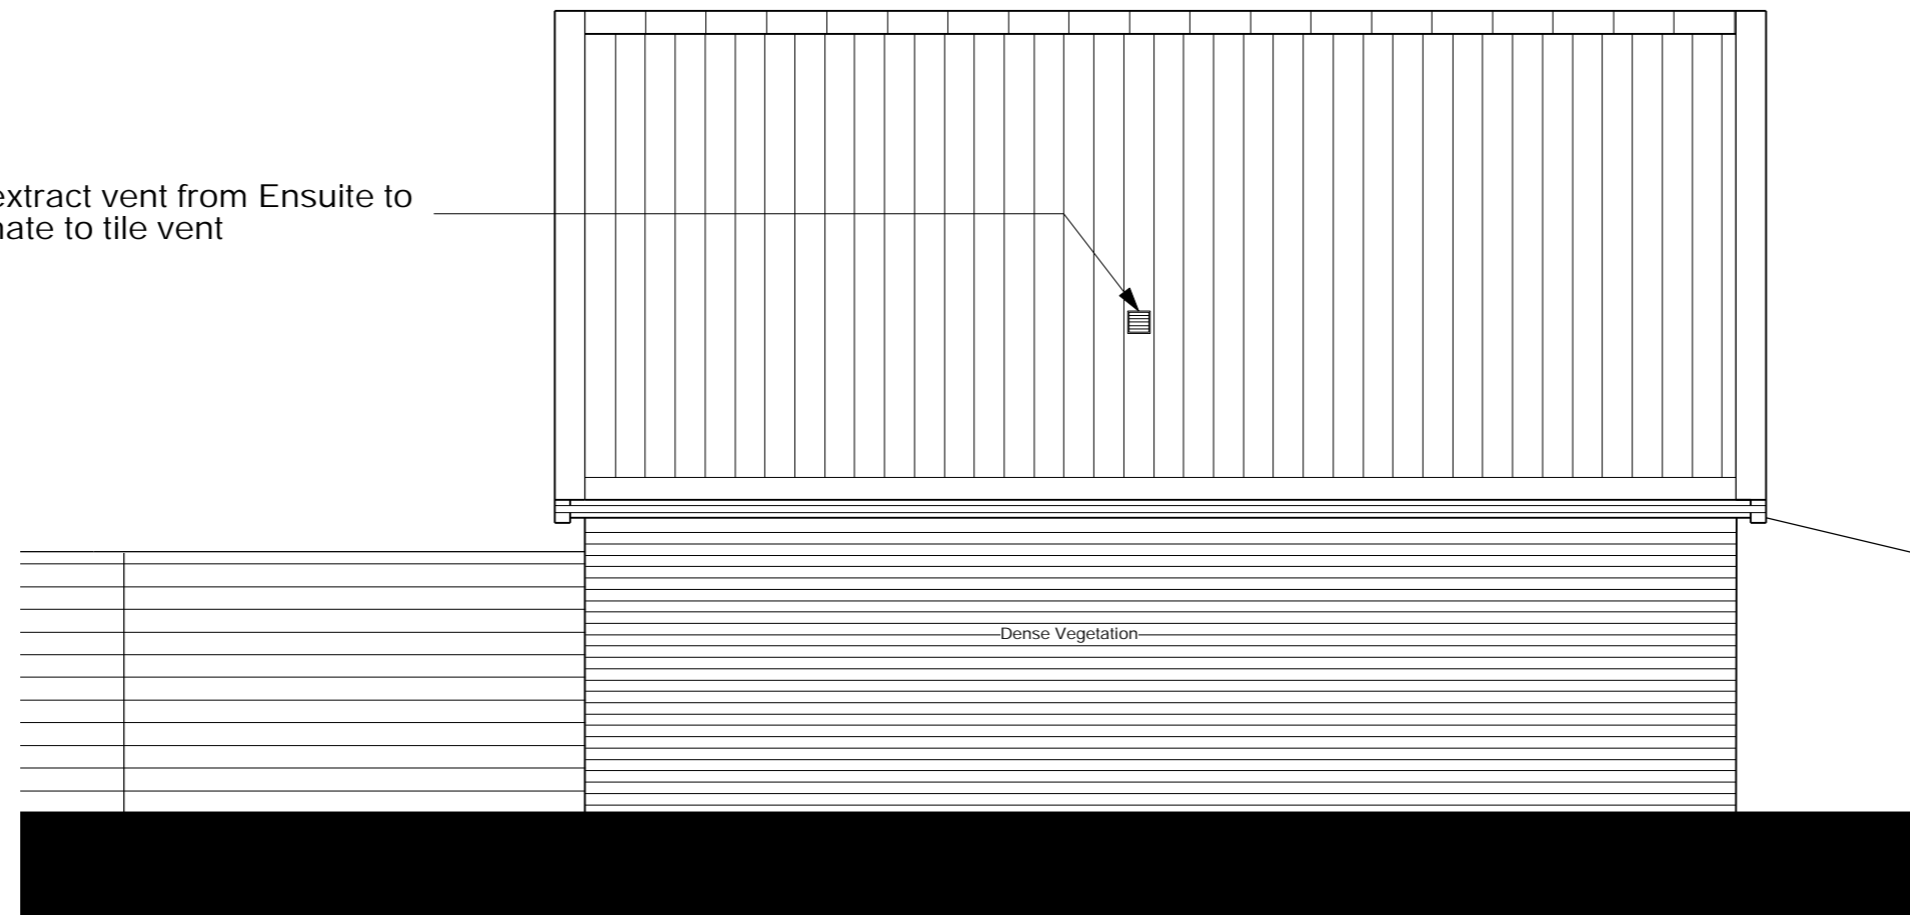

Proposed East Elevation
 Scale 1:50


Ensuite Extract Fan:

It is proposed to install the William Blyth Pantile vent system for the new mechanical ventilation extract in the Ensuite. This tile will be flush with the existing pantiles and will not break up the line of the roof. To install the tile, existing tiles will be carefully removed and stored and then relaid following the installation of the vent. The pipe from the extract is to be connected to the vent internally.

Kitchen Extract Fan:

It is proposed to install a cast iron brick air vent for the new mechanical ventilation extract in the Kitchen. This fan will be fixed into the existing external wall and will not affect the existing material.

New extract vent from Kitchen to terminate to wall mounted extract

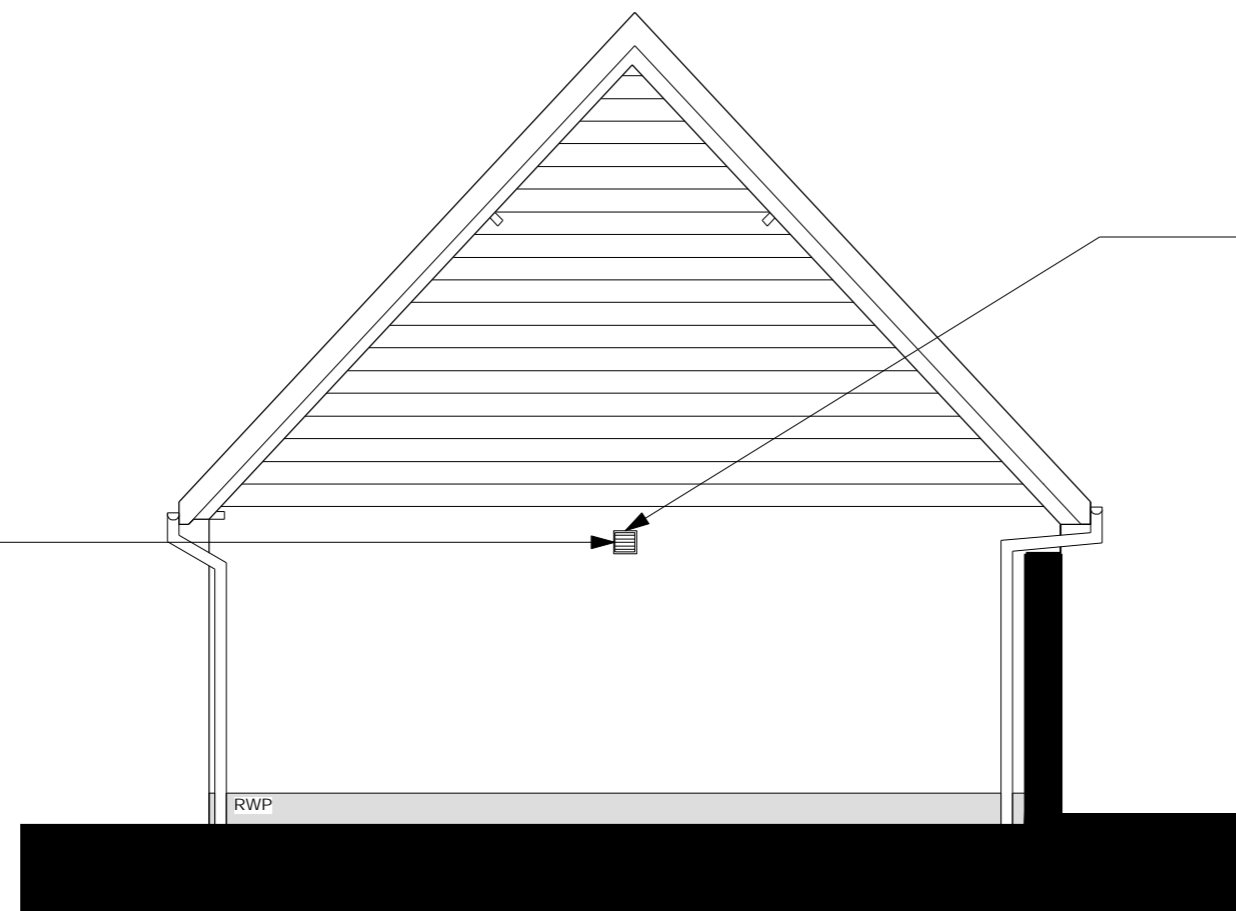

Proposed North Elevation
 Scale 1:50



Proposed Mechanical Ventilation Details
 Scale 1:50



REVISION	DESCRIPTION	DATE	DRAWN	CHECK
JOB NO.	5644	DRAWING NO.	PA_14	REVISION
TITLE	Proposed Mechanical Ventilation Details			
SCALE	1:50	SHEET SIZE	A1	
ISSUE DATE	January - 2024			
AUTHOR	CM	CHECK	CW	
PROJECT	Proposed Alterations and Refurbishment of Outbuilding White House, The Street, Chelsworth, Suffolk, IP7 7HU			
CLIENT	Dodgson, Mrs P & Davidson Mr. S			
STATUS	For Planning			



Market Place / Hadleigh / Ipswich / Suffolk / IP7 5DN
 Do not scale from drawing - work to figured dimensions only.
 Copyright © Wincer Kievenaar Architects Limited
 5644_PA DOC drawings.vwx