







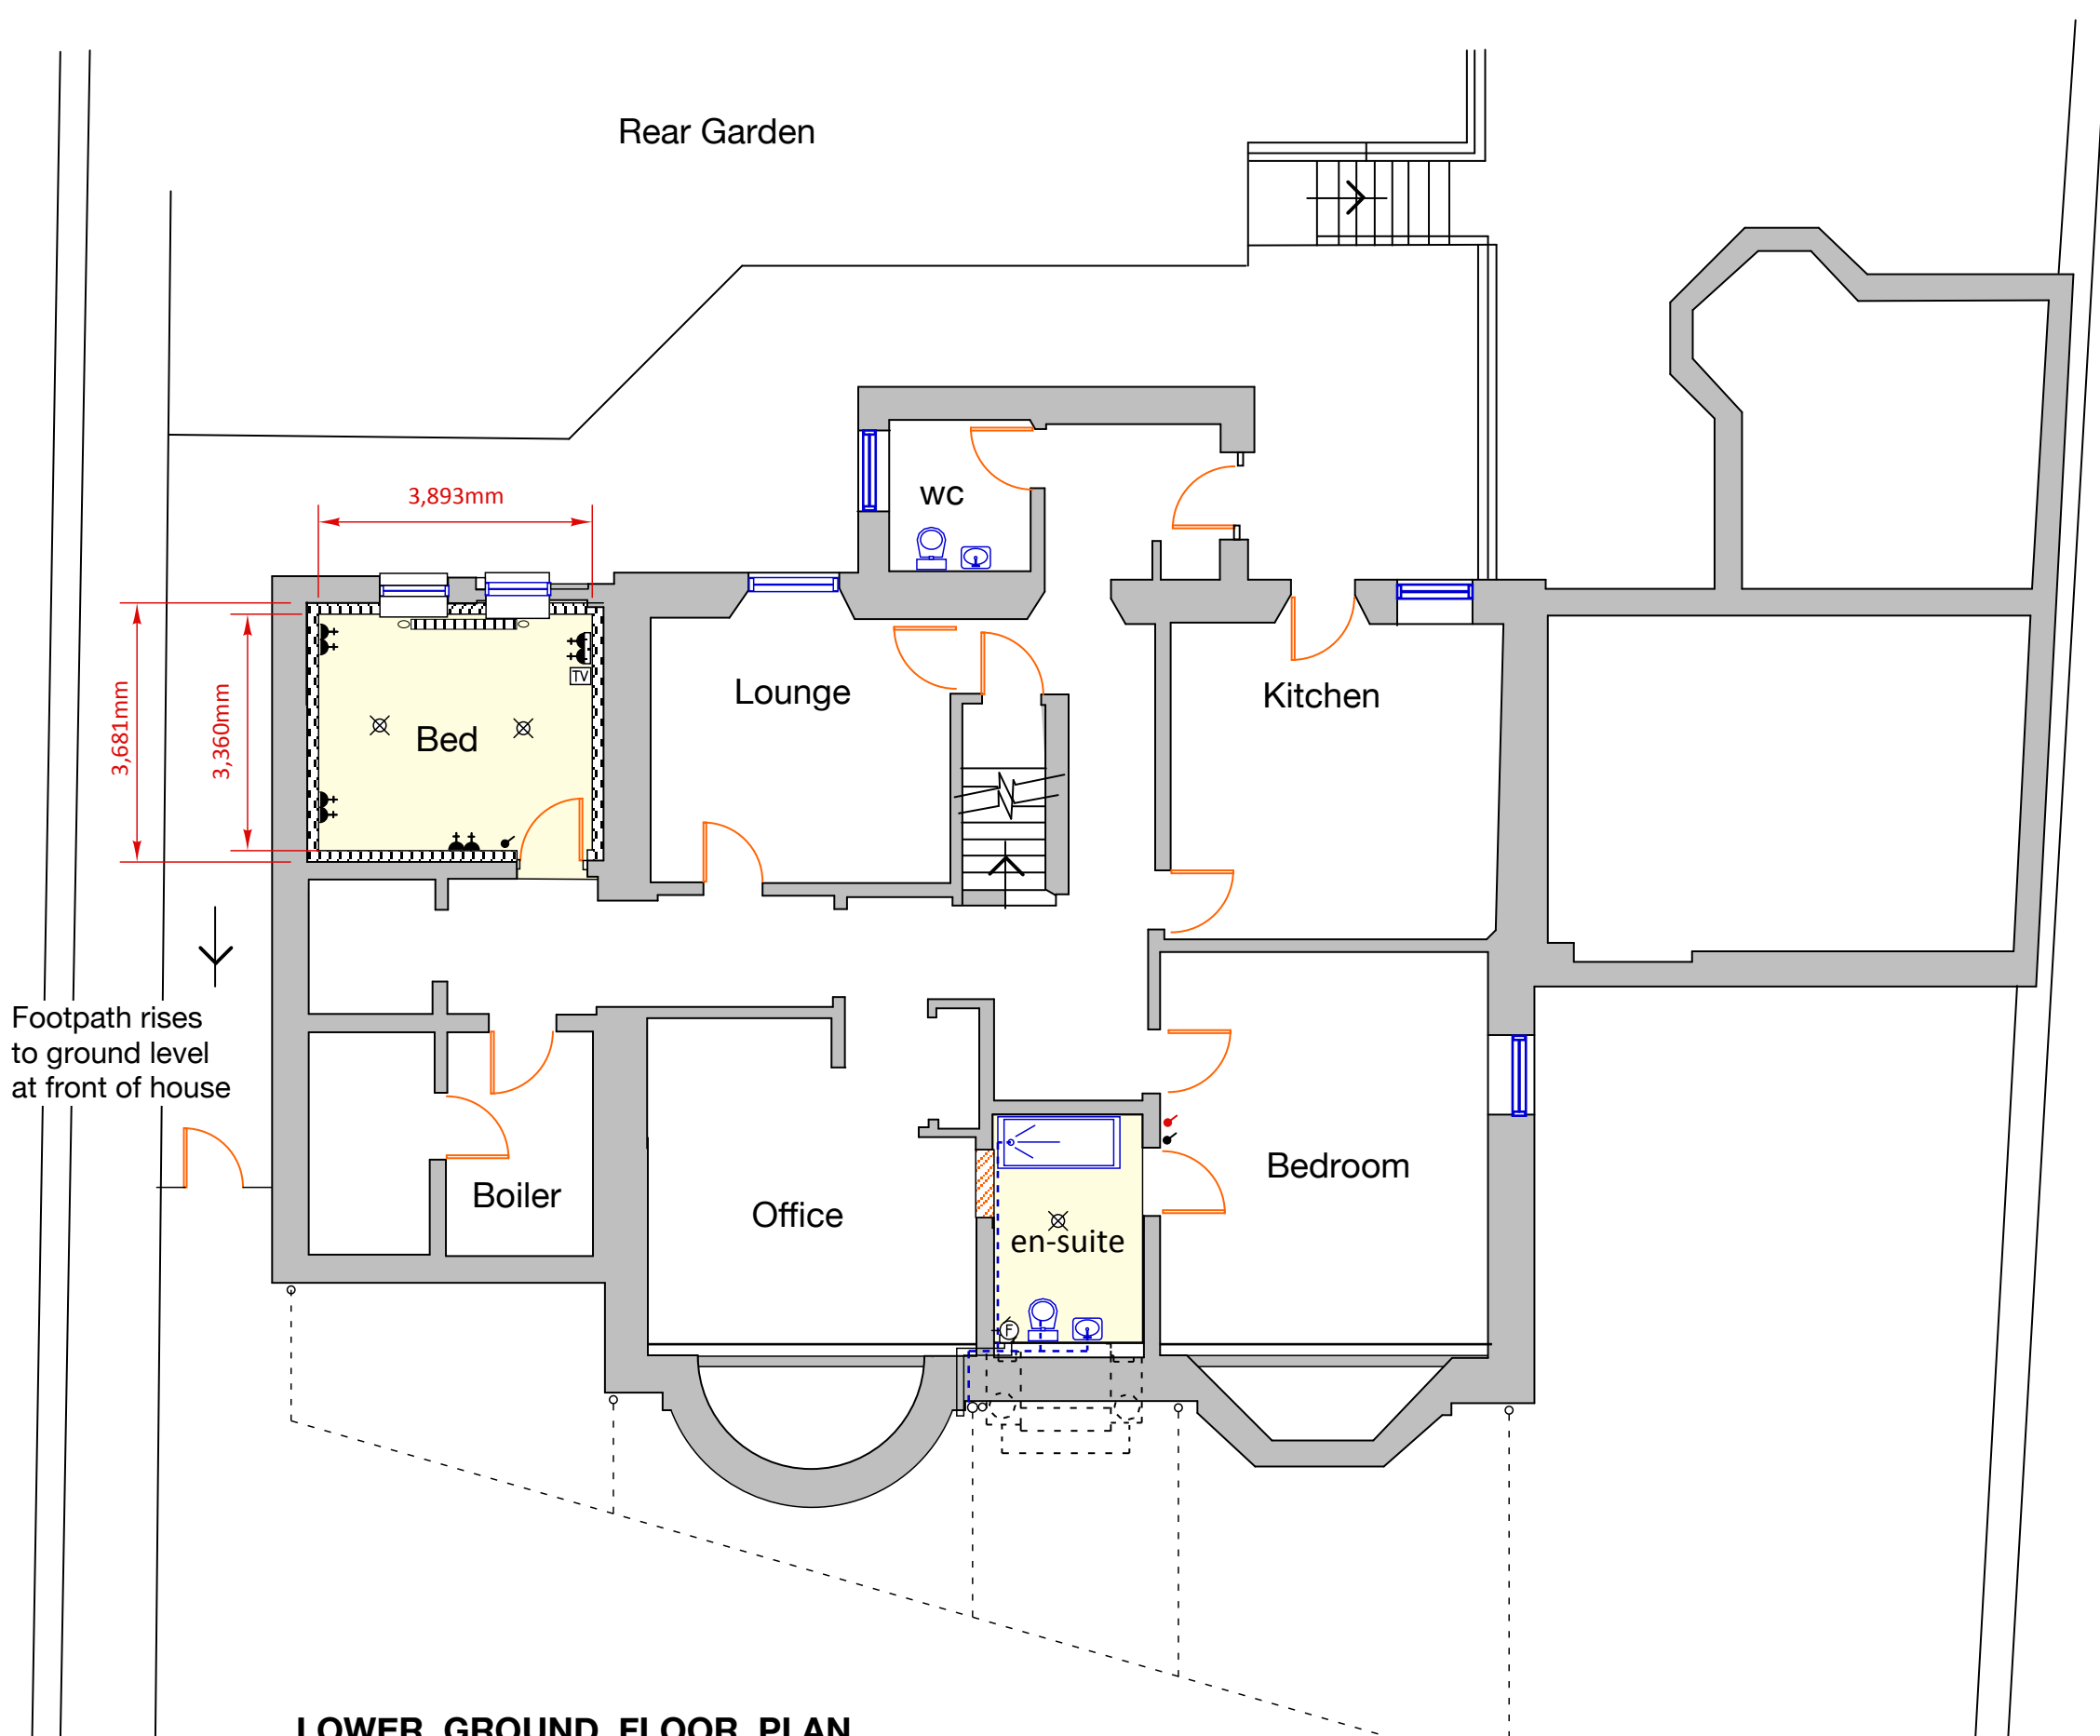



ELECTRICAL LEGEND:

-  Double switch socket
-  Remote spur for shower
-  Light Fixture ceiling...pendant
-  Light switch
-  Wall Mounted Exhaust Fan
-  Tv Outlet
-  radiators with TRV
-  Double switch + Broadband socket



Client Mr Usman Quayuu	Address 15 Newark Drive, Glasgow	 KEITH EDWARDS ARCHITECT 2 CALEDON STREET, GLASGOW G12 9DX tel : 0141 341 0694
Project Proposed bed + shower at Basment Level	Dwg A1591.23.08	
Title Basement Plan ... proposed	Date 30.11.23	Scale 1:100