

Light	Symbol	Description / Type	Mounting height	Aiming angle	Luminaire profile *
A		Wall mounted half lantern to either side of front door	Approx. 1.8m above FFL	Horizontal	
B		Wall mounted downlighters to flank walls of dwelling	Approx. 2.0m above FFL	Downwards	
C		Mini downlighters recessed in soffit at ground and first floor level	Approx. 2.7m above FFL	Downwards	


*Not to scale



A




B

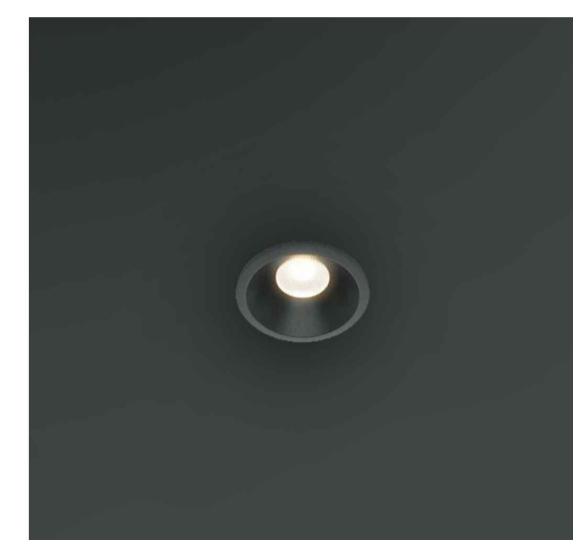

C




1 PLAN
EXTERNAL LIGHTING - FIRST FLOOR PLAN
SCALE 1: 100

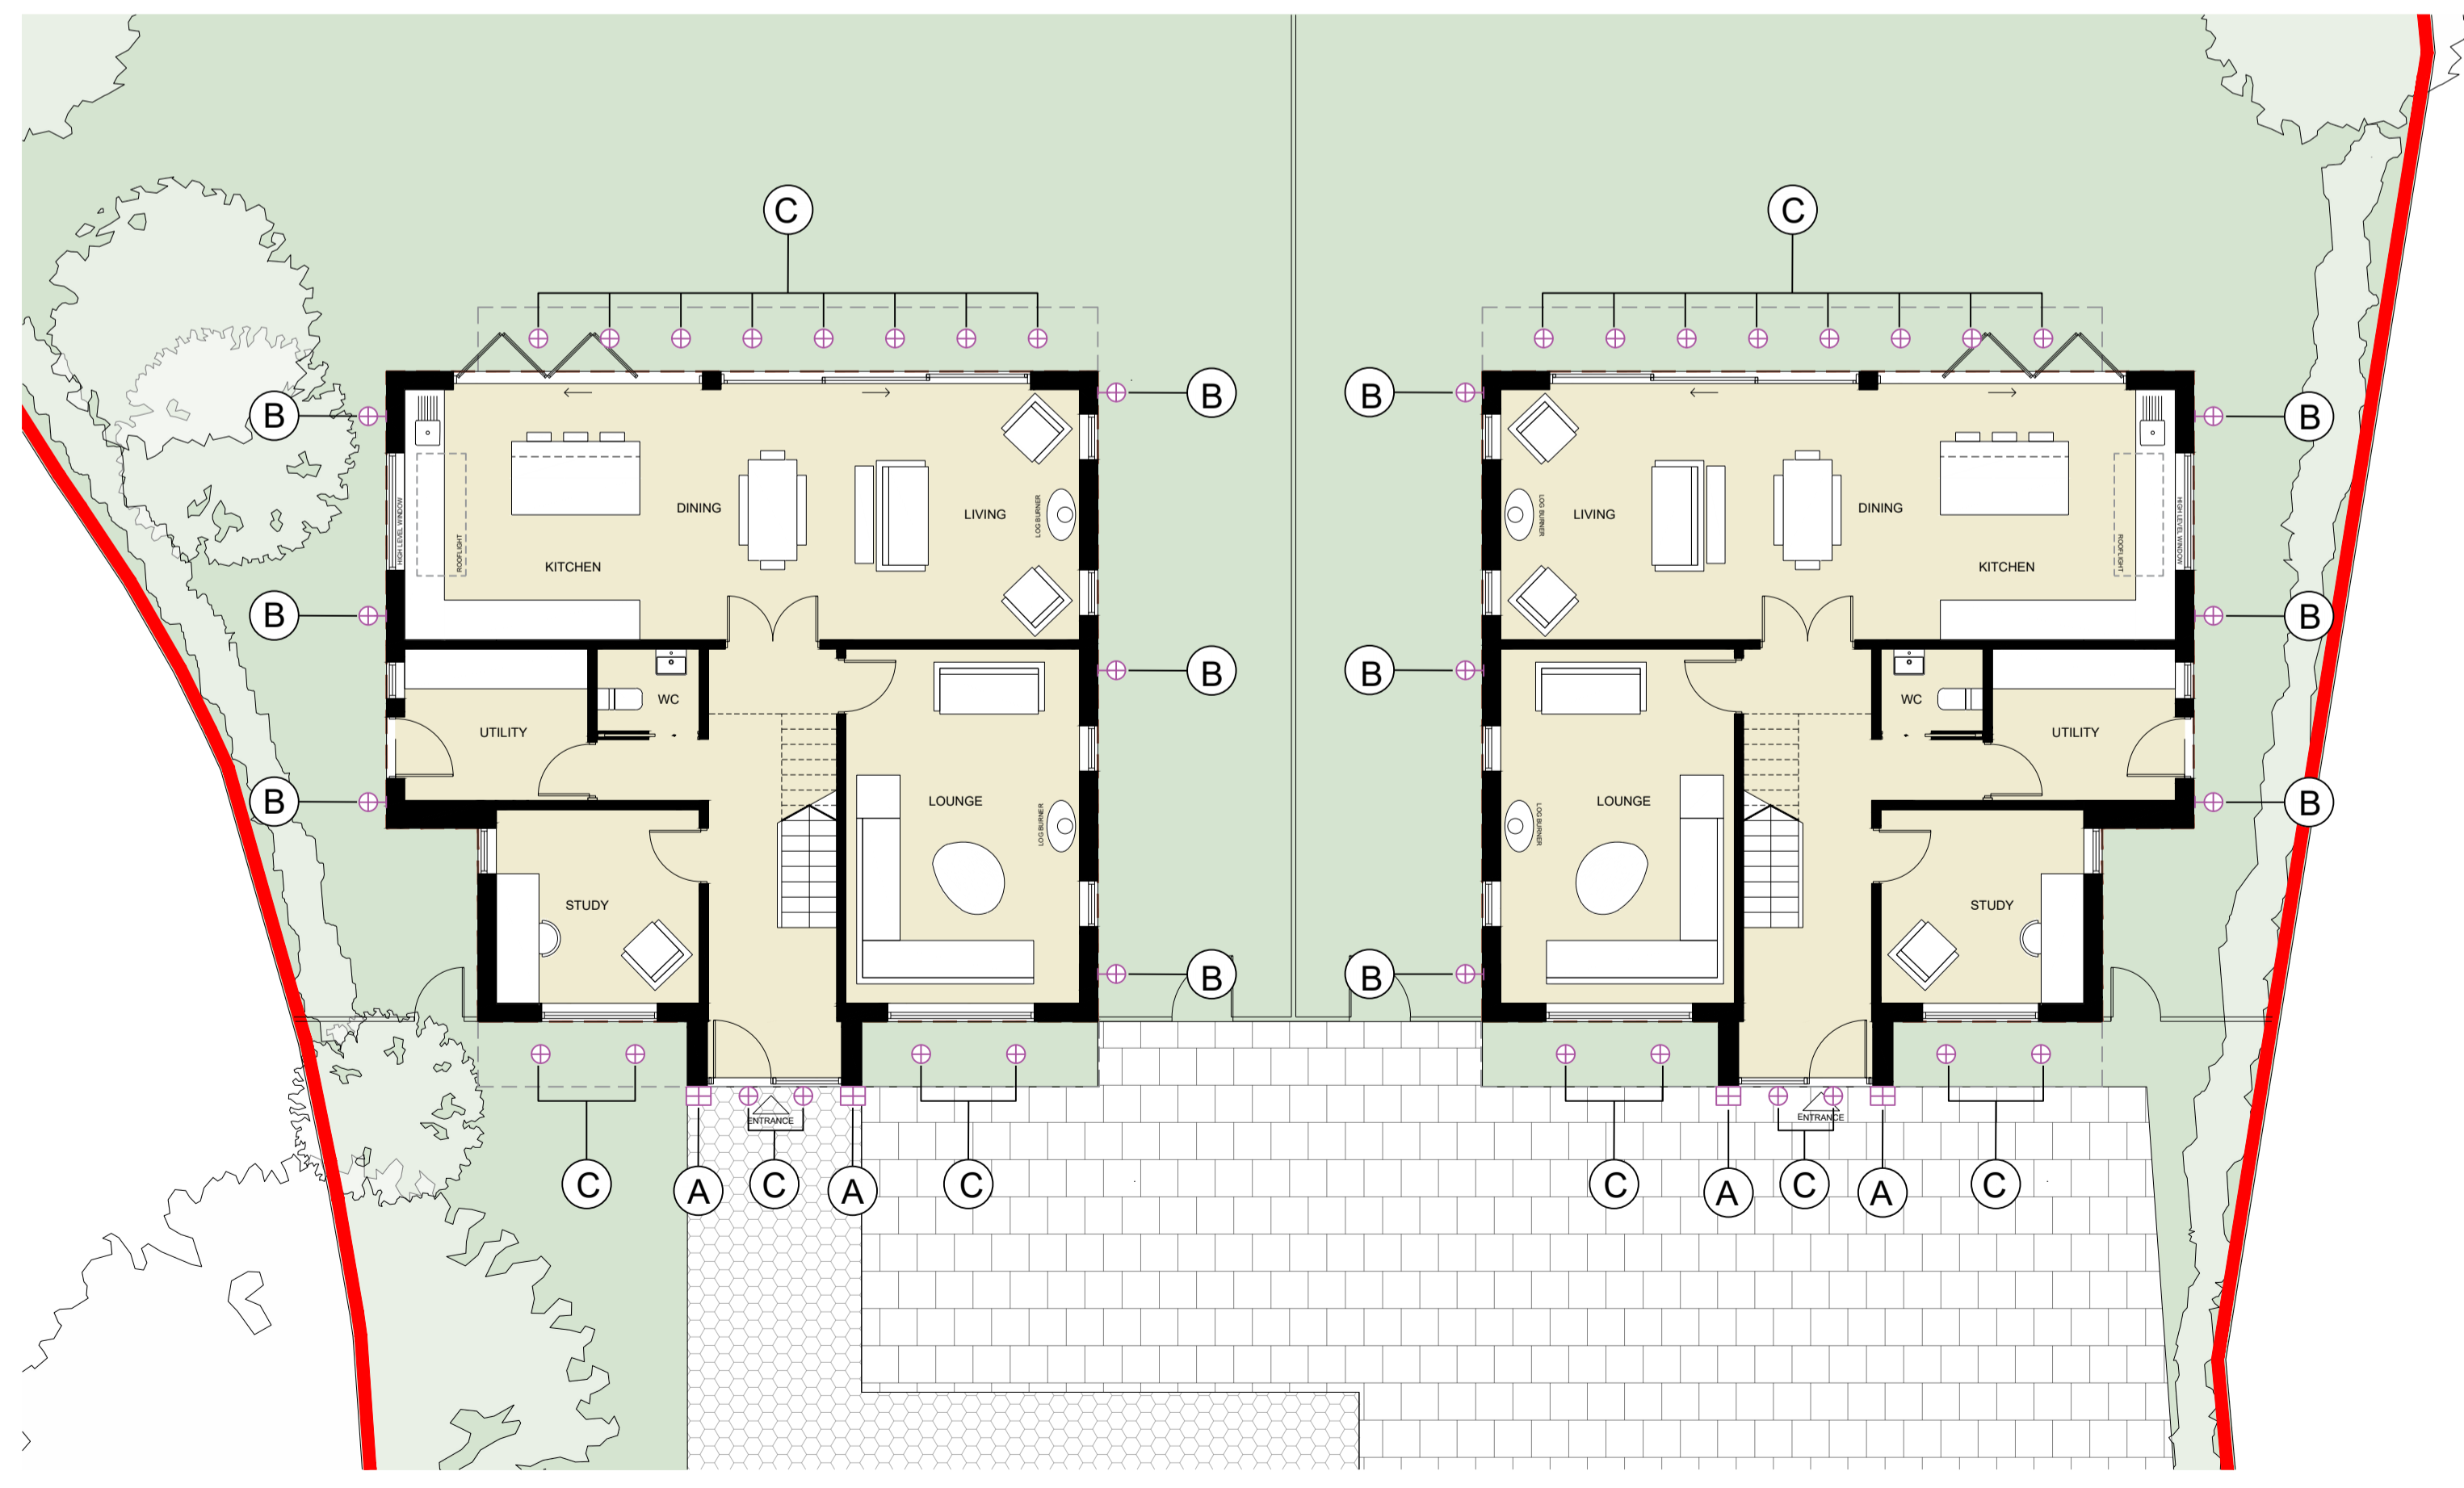

2 PLAN
EXTERNAL LIGHTING - GROUND FLOOR PLAN
SCALE 1: 100

KEY
Application Boundary (0.61 Ha)

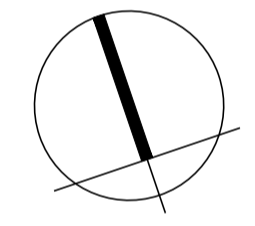


PLANNING

P1 Revised for planning JEP 2024.01.16
REV DESCRIPTION DR / CH DATE
Galen, Pennington Road, Southborough
Tunbridge Wells, Kent TN4 0SS
Proposed External Lighting Plan

Scale @ A1 1:100
Created JANUARY 2024
Drawn By JEP
Checked By SM
Purpose of Issue PLANNING

OPEN architecture
Architecture
Building Surveying
Project Management
Interior Design

Anton House www.openarc.co.uk
South Park T +44 01732 779580
Sevenoaks / Kent / TN13 1EB F +44 01732 741316

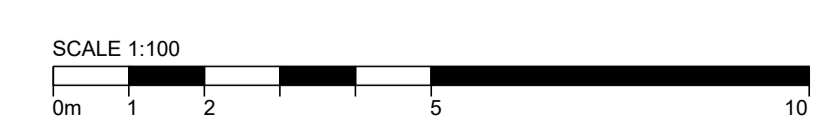

Job Reference Drawing Number Rev
19062 P152 P1