



Notes: This drawing is the copyright Paddock Johnson Partnership Limited and may not be used without their prior written consent.
Written dimensions to be taken in preference to scaled dimensions.
Due to the inaccuracies of scanning, scanned images should not be scaled.

+ REV: DATE: DESCRIPTION: BY:

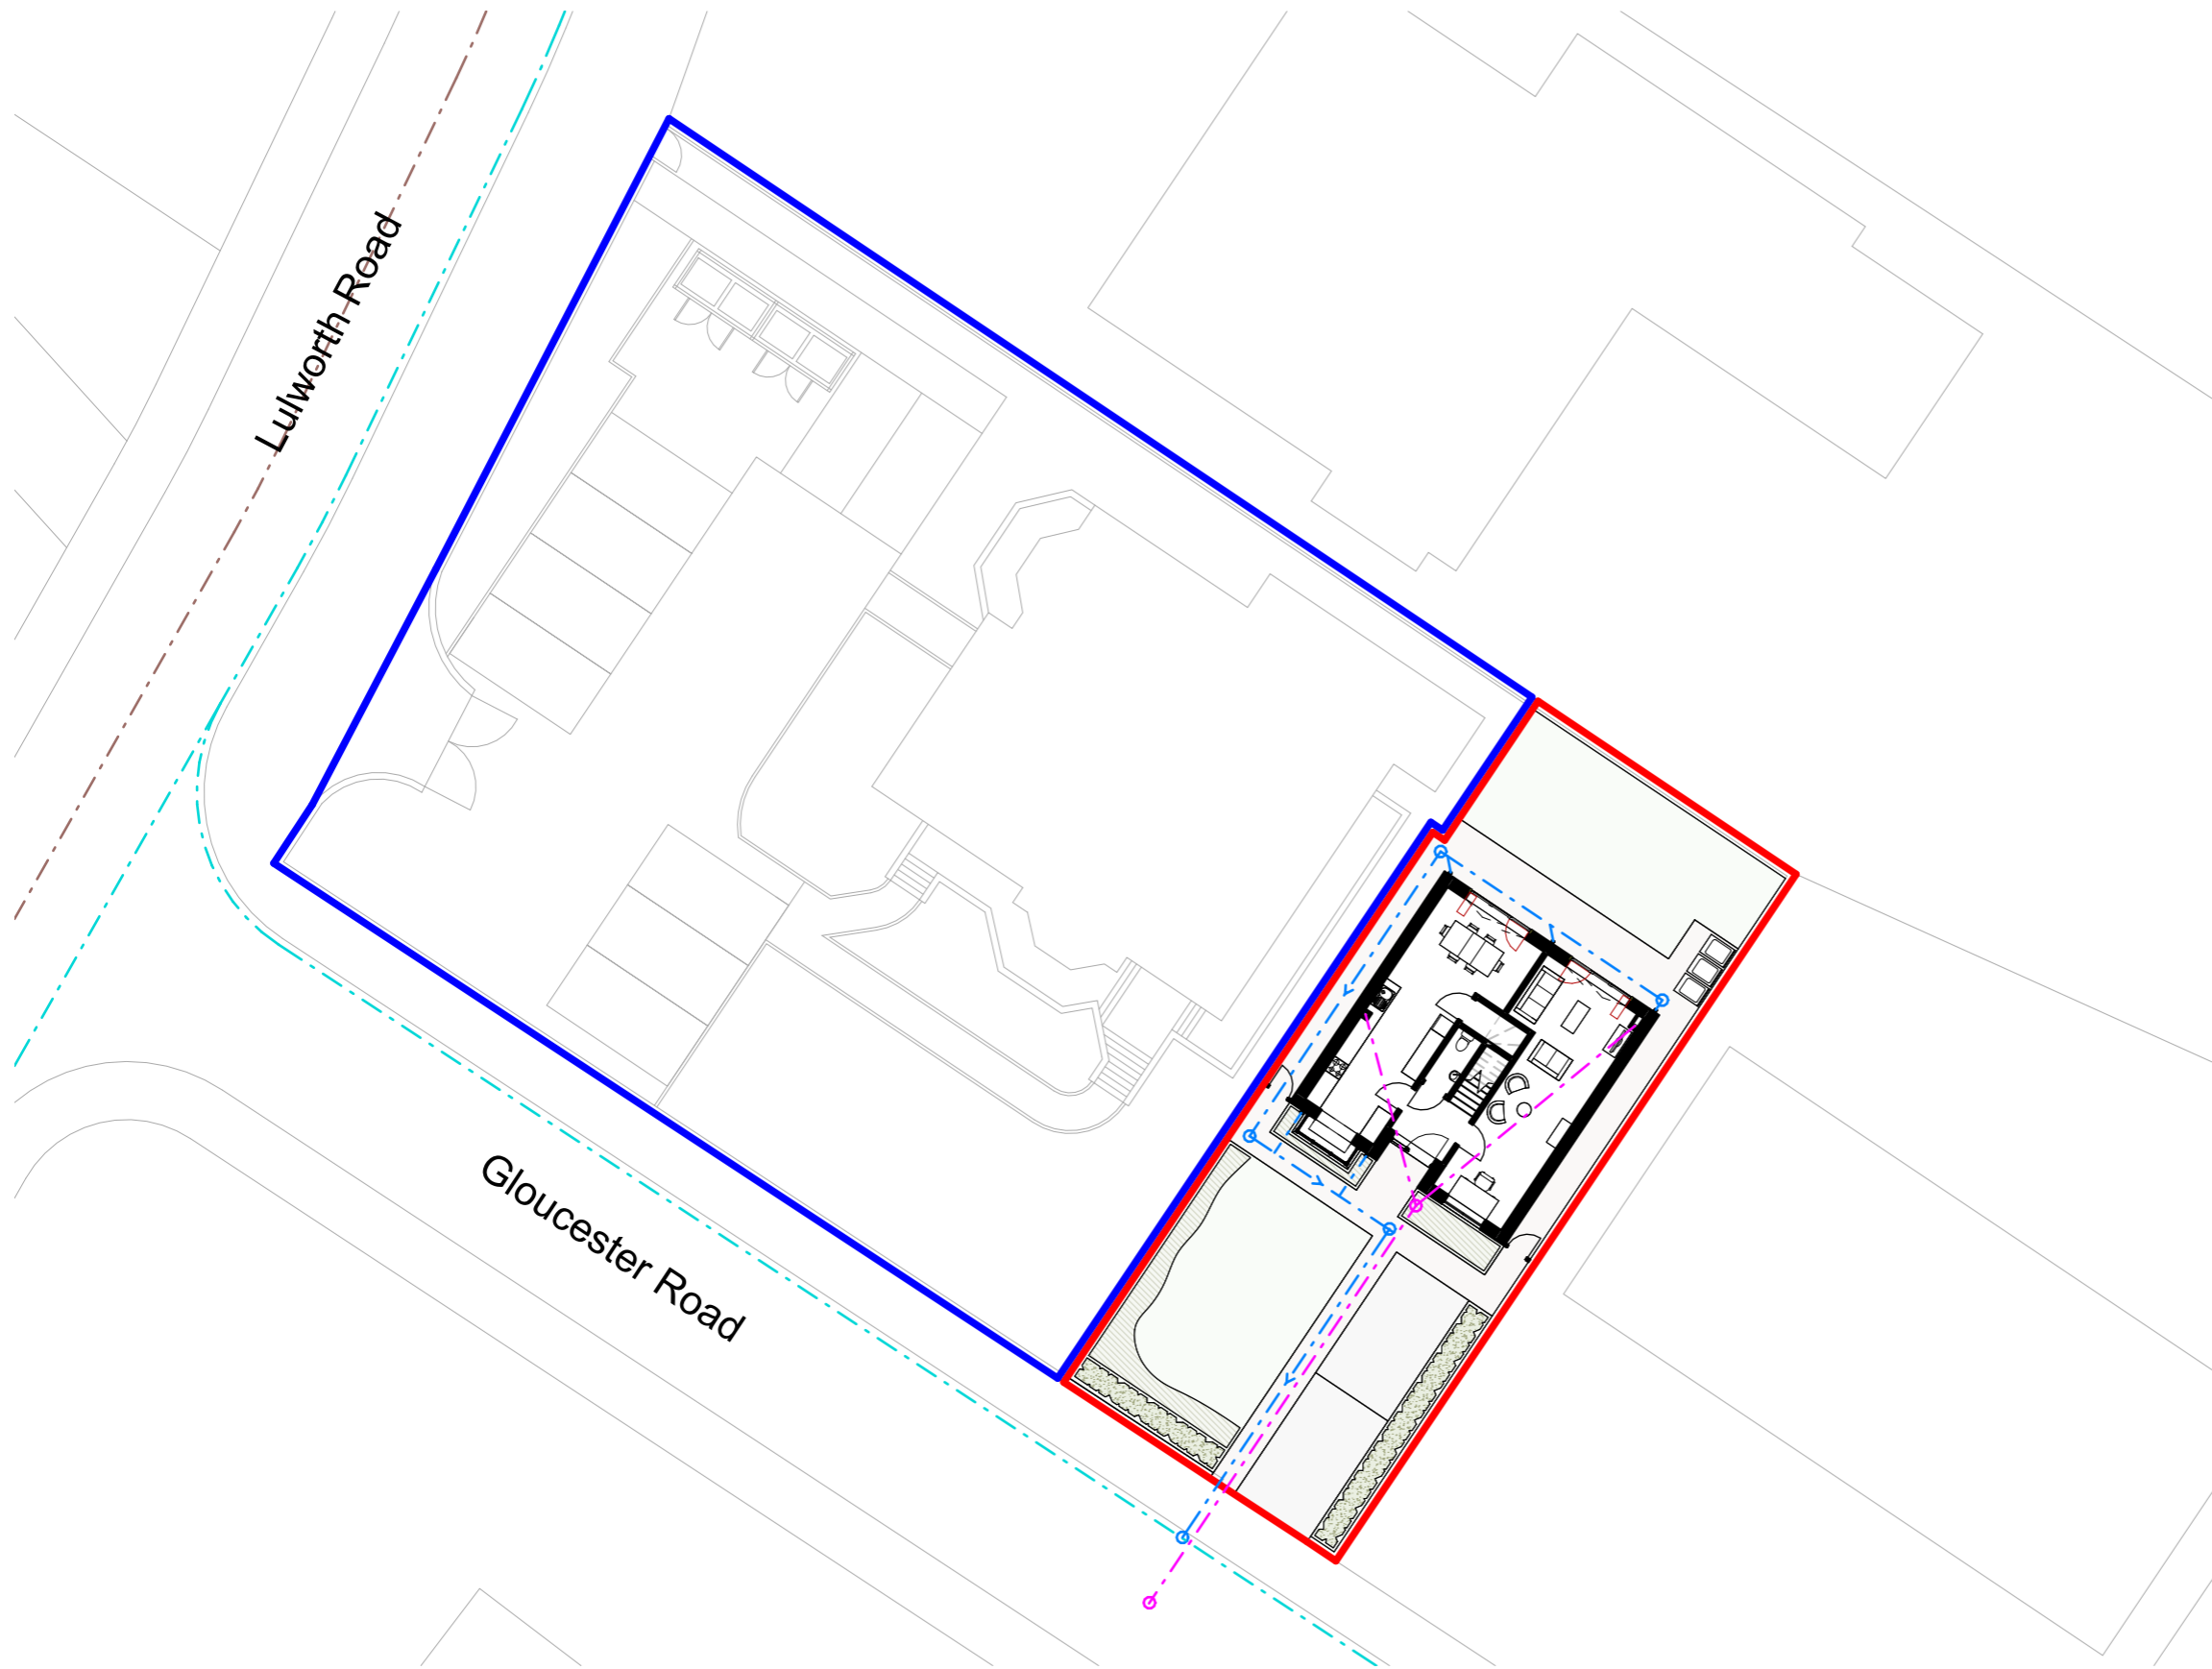

Key Plan

 - - - - - Proposed FW Route
- - - - - Estimated Existing FW Route
- - - - - Proposed SW Route
- - - - - Estimated Existing SW Route



1 00 Proposed Drainage Strategy
Scale: 1 : 250

CLIENT: Mart Build
PROJECT: New House
1E, Gloucester Road, Southport,
PR8 2AU

DRAWING TITLE: Proposed Drainage Layout

DRAWING NUMBER: **24005-PJA-00-ZZ-DR-A-6000**
SCALE: As indicated@A3
DATE: 12.01.24
STATUS: **PLANNING**
BY: OM
CHECKED: SH

PADDOCK
JOHNSON

Studio 2, The Lyceum,
Bath Street, Port Sunlight,
Merseyside, CH62 4UJ
0151 643 1234
admin@paddockjohnson.com
www.paddockjohnson.com
Paddock Johnson Partnership
Limited. Registered in England
and Wales. No. 06684275