
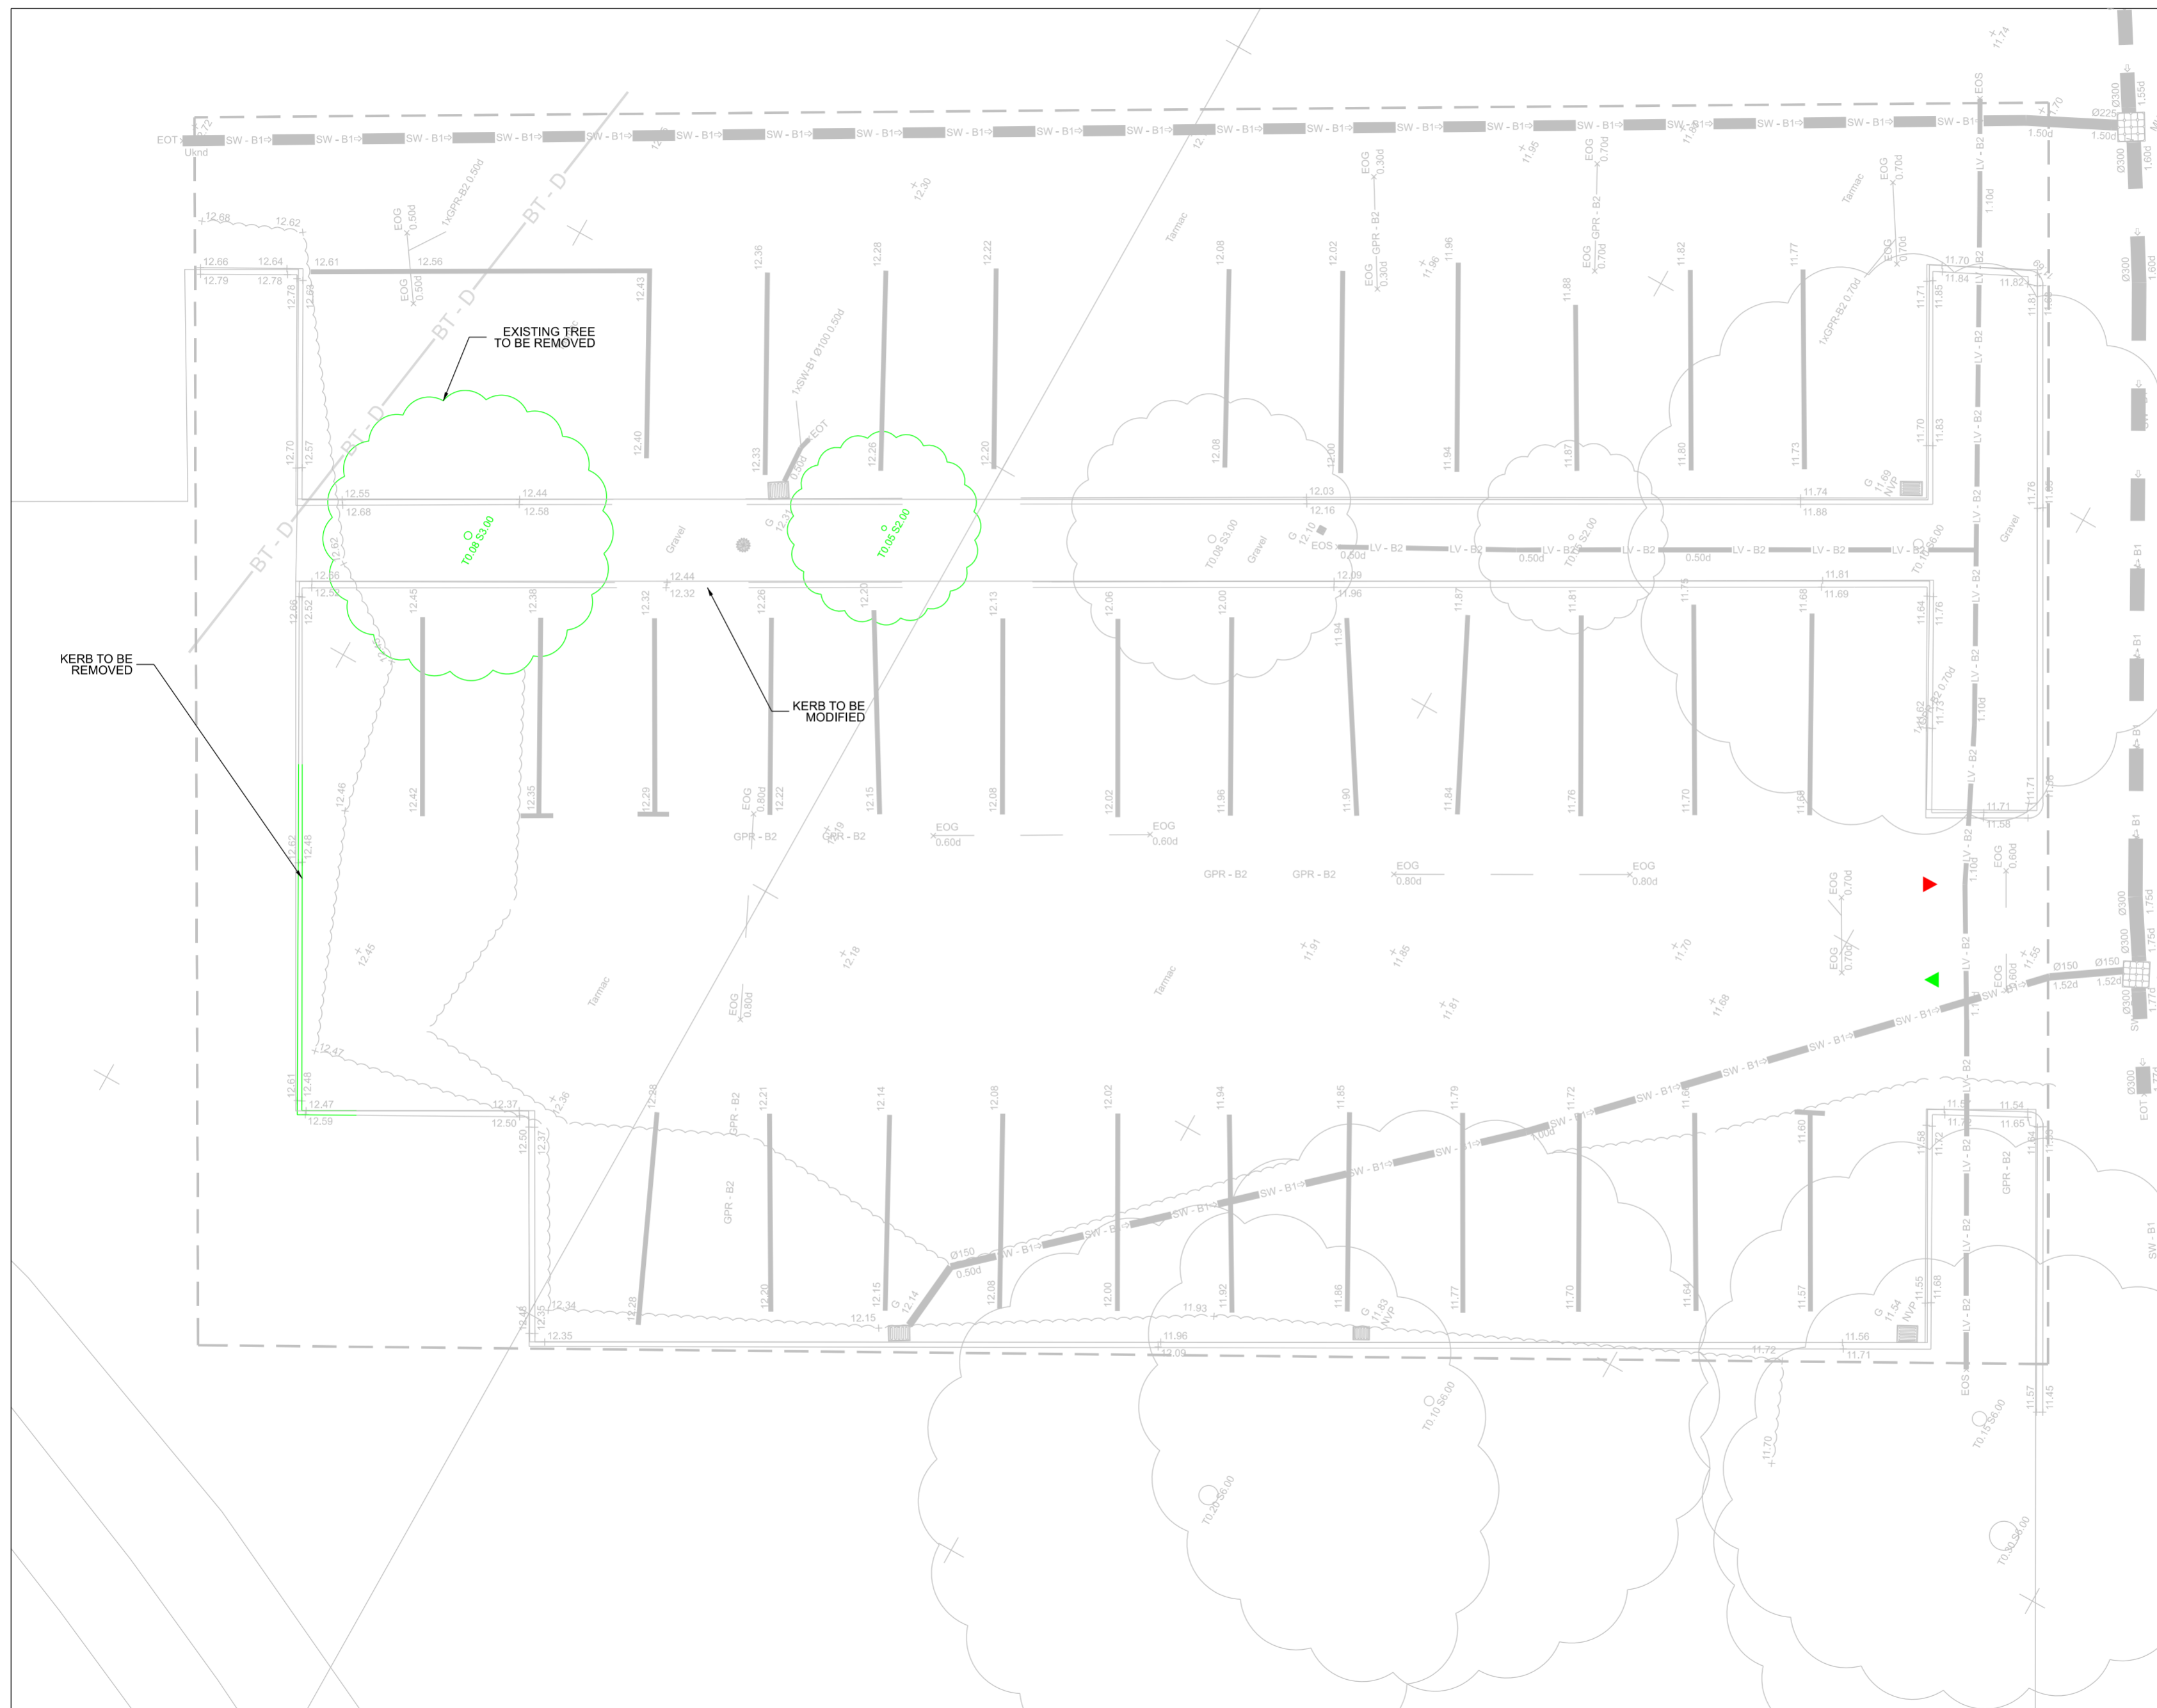


EXISTING SITE PLAN  
SCALE 1:100

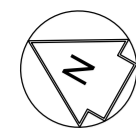

NOTES:  
1. ALL THE DIMENSIONS ARE IN MILLIMETERS (mm) AND LEVELS ARE IN METERS (m) UNLESS STATED OTHERWISE.

▲ MAIN ENTRANCE AND EXIT OF THE SITE

**COLOUR CONVENTIONS**  
 BLACK - EXISTING OR UNCHANGED  
 BLUE - MODIFIED OR TO BE MOVED  
 GREEN - REDUNDANT OR TO BE REMOVED  
 RED - PROPOSED OR ADDITIONAL  
 PURPLE - WORKS BY OTHERS

P02	18/01/24	DDRAWING TITLE CHANGED	ADI	Chk	App
P01	15/12/23	ISSUED FOR REVIEW	ADI	Chk	App
Rev	Date	Description of Revisions	Drawn	Chkd	Appr

Suitability S0 - WORK IN PROGRESS

**POISE**  
 Poise Group Ltd  
 124 City Road  
 London  
 EC1V 2NX


Contractor(s)  
**IONITY**  
 Ionity GmbH  
 Moosacher Strasse 84,  
 D-80809 Munich  
 Germany

Project  
 IONITY  
 BLACKPOOL

Drawing Title  
 IONITY ELECTRIC VEHICLE CHARGING  
 BLACKPOOL  
 EXISTING SITE PLAN

Designed	A THAKUR	Signed		Date	11/12/23
Drawn	ADITYA	Signed		Date	11/12/23
Checked	Checked	Signed		Date	Date3
Approved	Approved	Signed		Date	Date4

Scale(s)	1:100	ELR & Mileage	ELR&Mileage
Alternative Reference	Alternative Reference	Sheet	01 of 01
Drawing Number	8312-POI-DRG-CIV-500011	Revision	P02

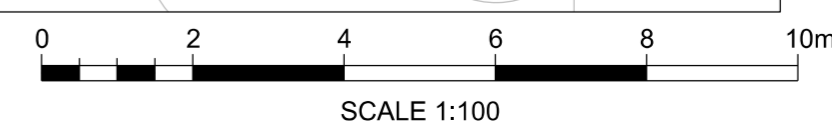

SCALE 1:100