


Langton Green Community Sports Association


Creation of an Artificial Grass Pitch

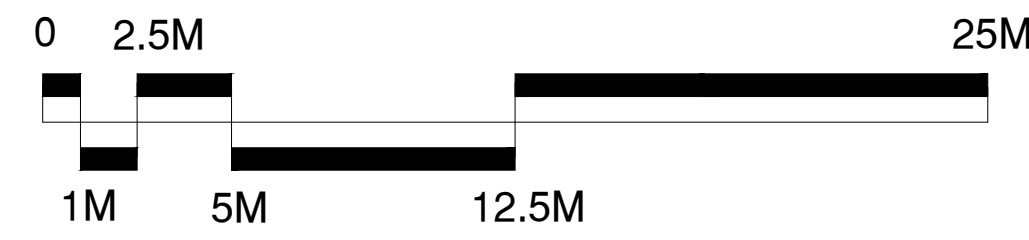

SSU
SURFACING STANDARDS LIMITED
Office 2, Elmwood House,
Lano Sports Centre, Langton Green, LE12 0JY
01535 400 012

LANO SPORTS **CLS SPORTS**

1. DO NOT SCALE FROM DRAWING UNLESS FOR PLANNING PURPOSES ONLY. ALL DIMENSIONS TO BE CHECKED ON SITE PRIOR TO COMMENCEMENT OF WORKS.
2. THIS DRAWING IS COPYRIGHT TO SURFACING STANDARDS LTD.
3. ALL PERSONNEL SHOULD BE AWARE OF THE HEALTH AND SAFETY PLAN WHICH IS RETAINED IN THE SITE MANAGERS OFFICE.

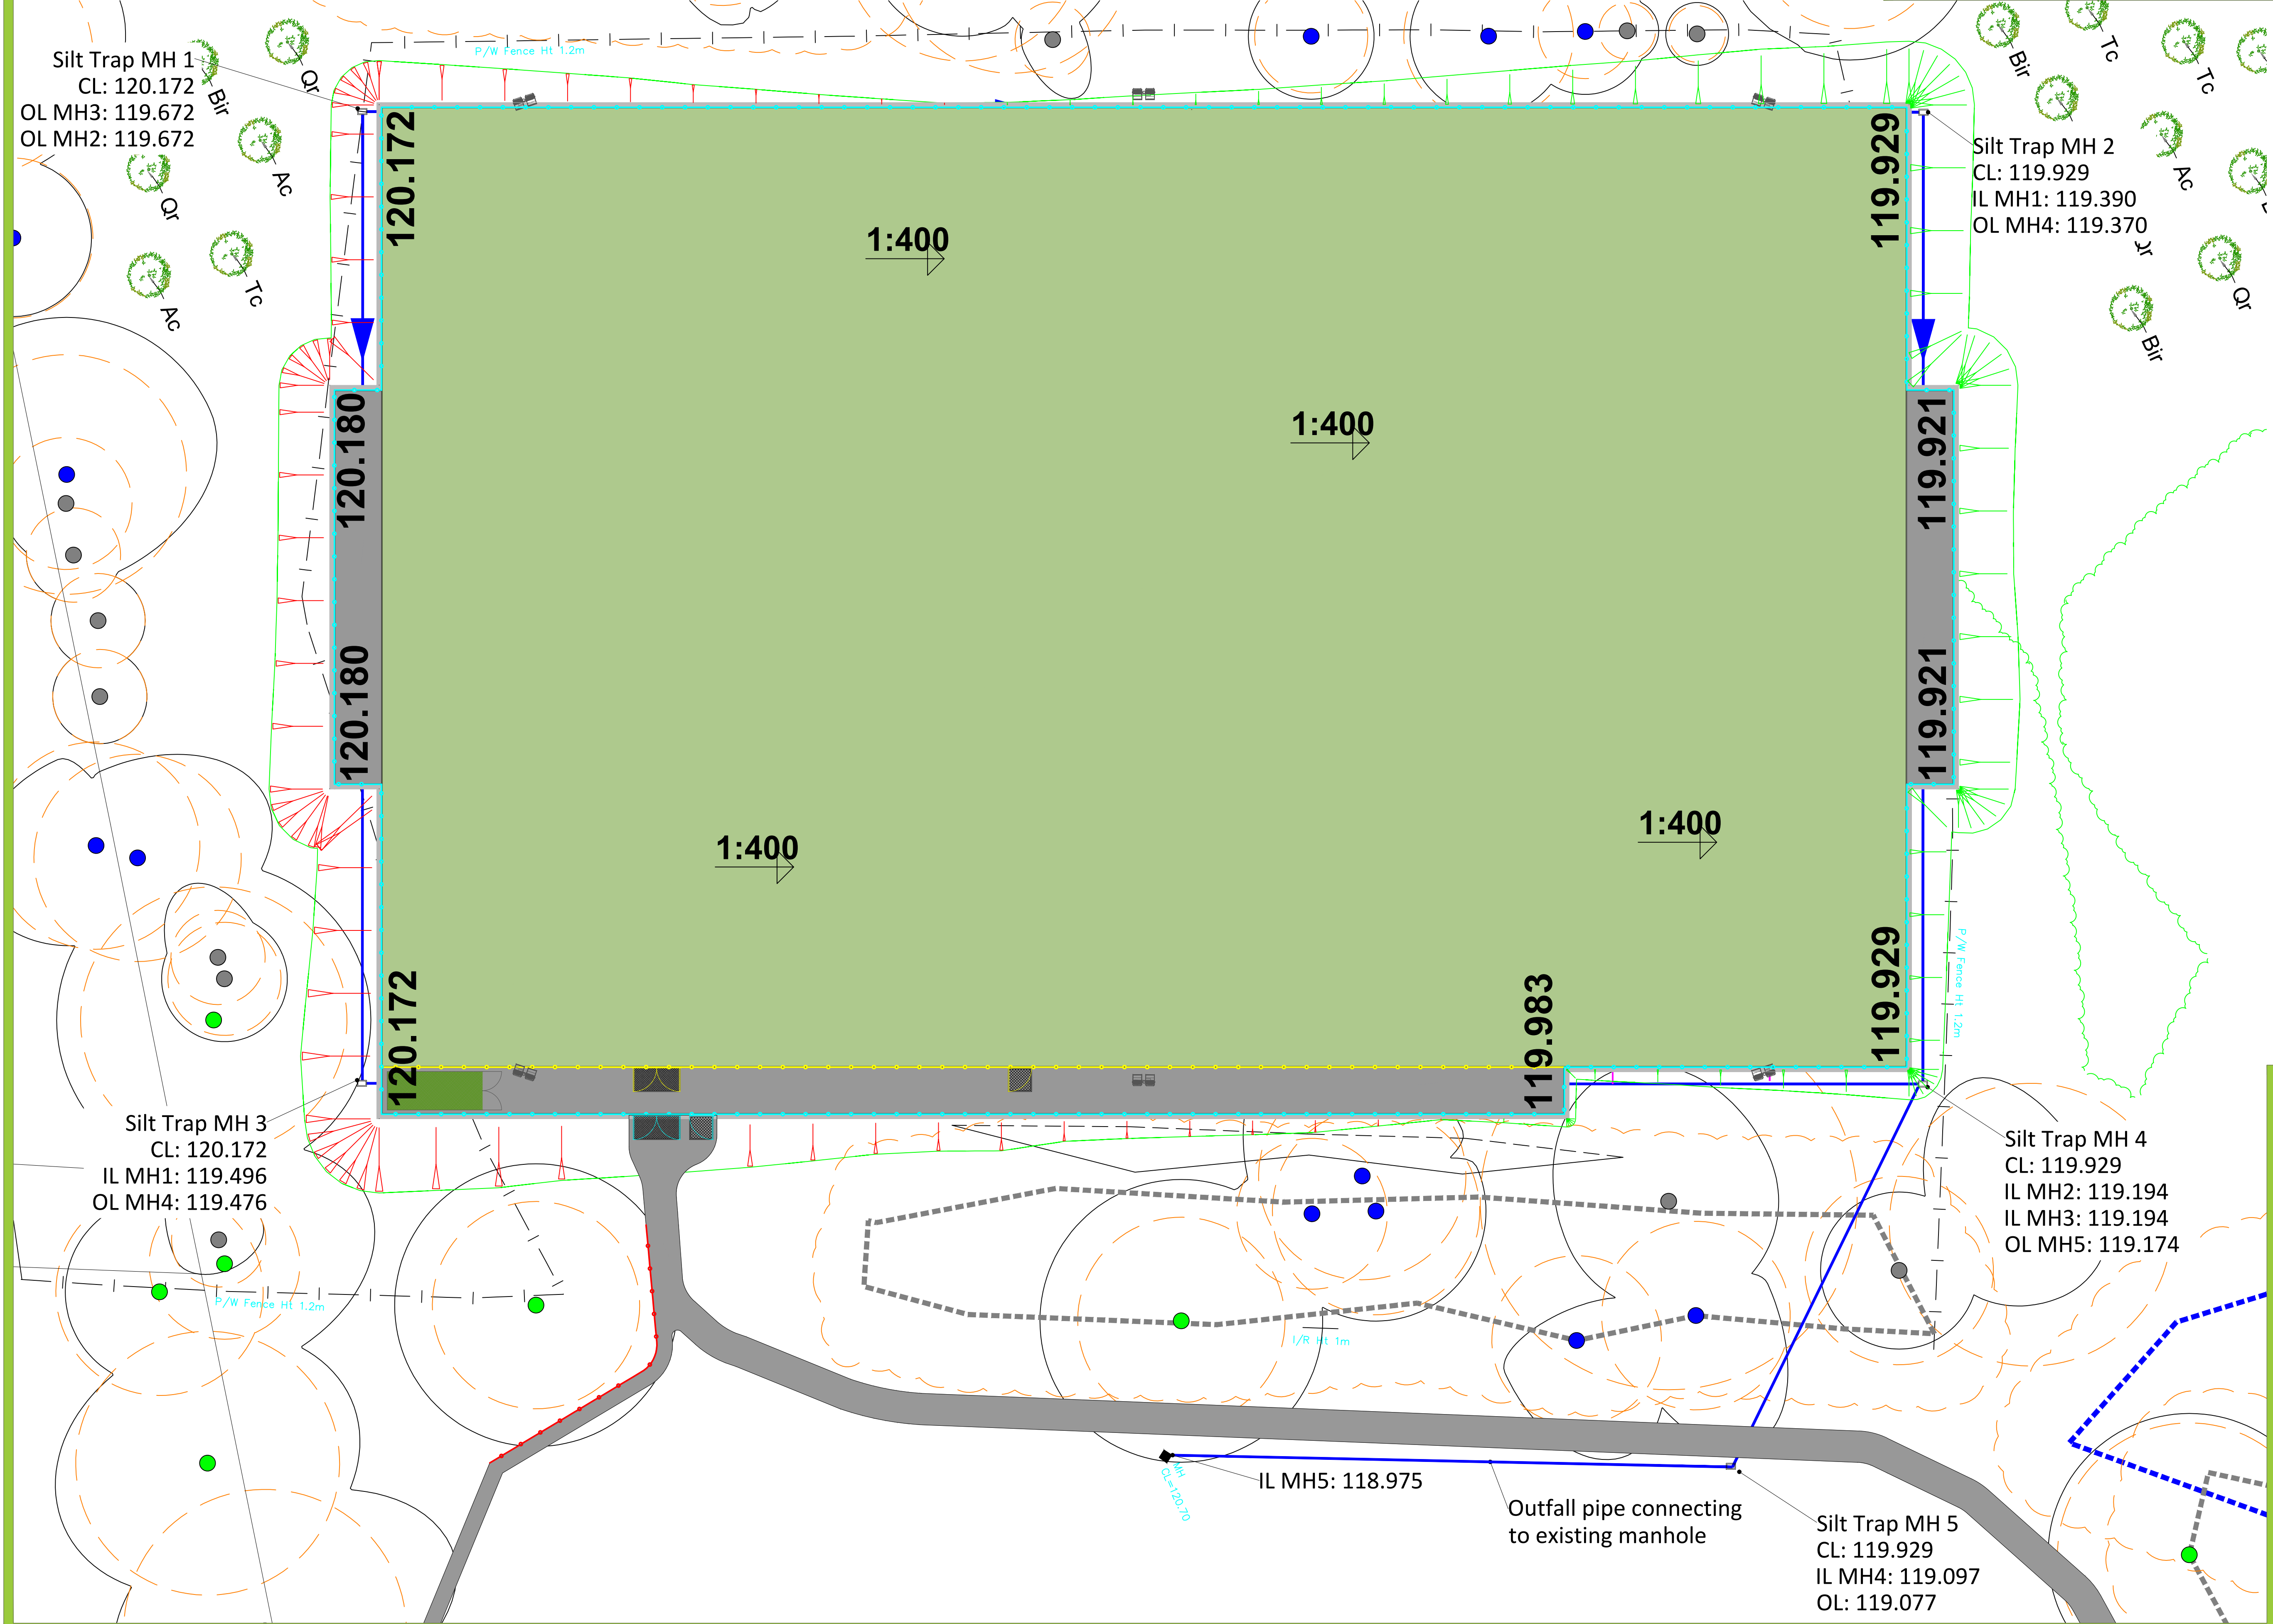

Silt Trap MH 1
CL: 120.172
OL MH3: 119.672
OL MH2: 119.672


Silt Trap MH 2
CL: 119.929
IL MH1: 119.390
OL MH4: 119.370

Silt Trap MH 3
CL: 120.172
IL MH1: 119.496
OL MH4: 119.476

Silt Trap MH 4
CL: 119.929
IL MH2: 119.194
IL MH3: 119.194
OL MH5: 119.174

Silt Trap MH 5
CL: 119.929
IL MH4: 119.097
OL: 119.077

Outfall pipe connecting to existing manhole

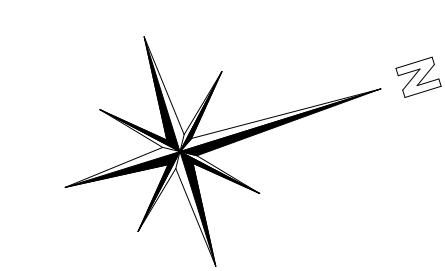

00	PLANNING ISSUE	ME	WB	04.04.23
REV	DESCRIPTION	REV	CK	DATE

SSU
Surfacing Standards Limited
SPORTS PITCH CONSULTANTS

AUTHOR: ME

TITLE: Langton Green Community Sports Association
Creation of an Artificial Grass Pitch
Proposed AGP Drainage Layout

PROJECT	SCALE	SIZE
LANO-CLS030	1:200	A1

DRAWING No	REVISION
07	00