
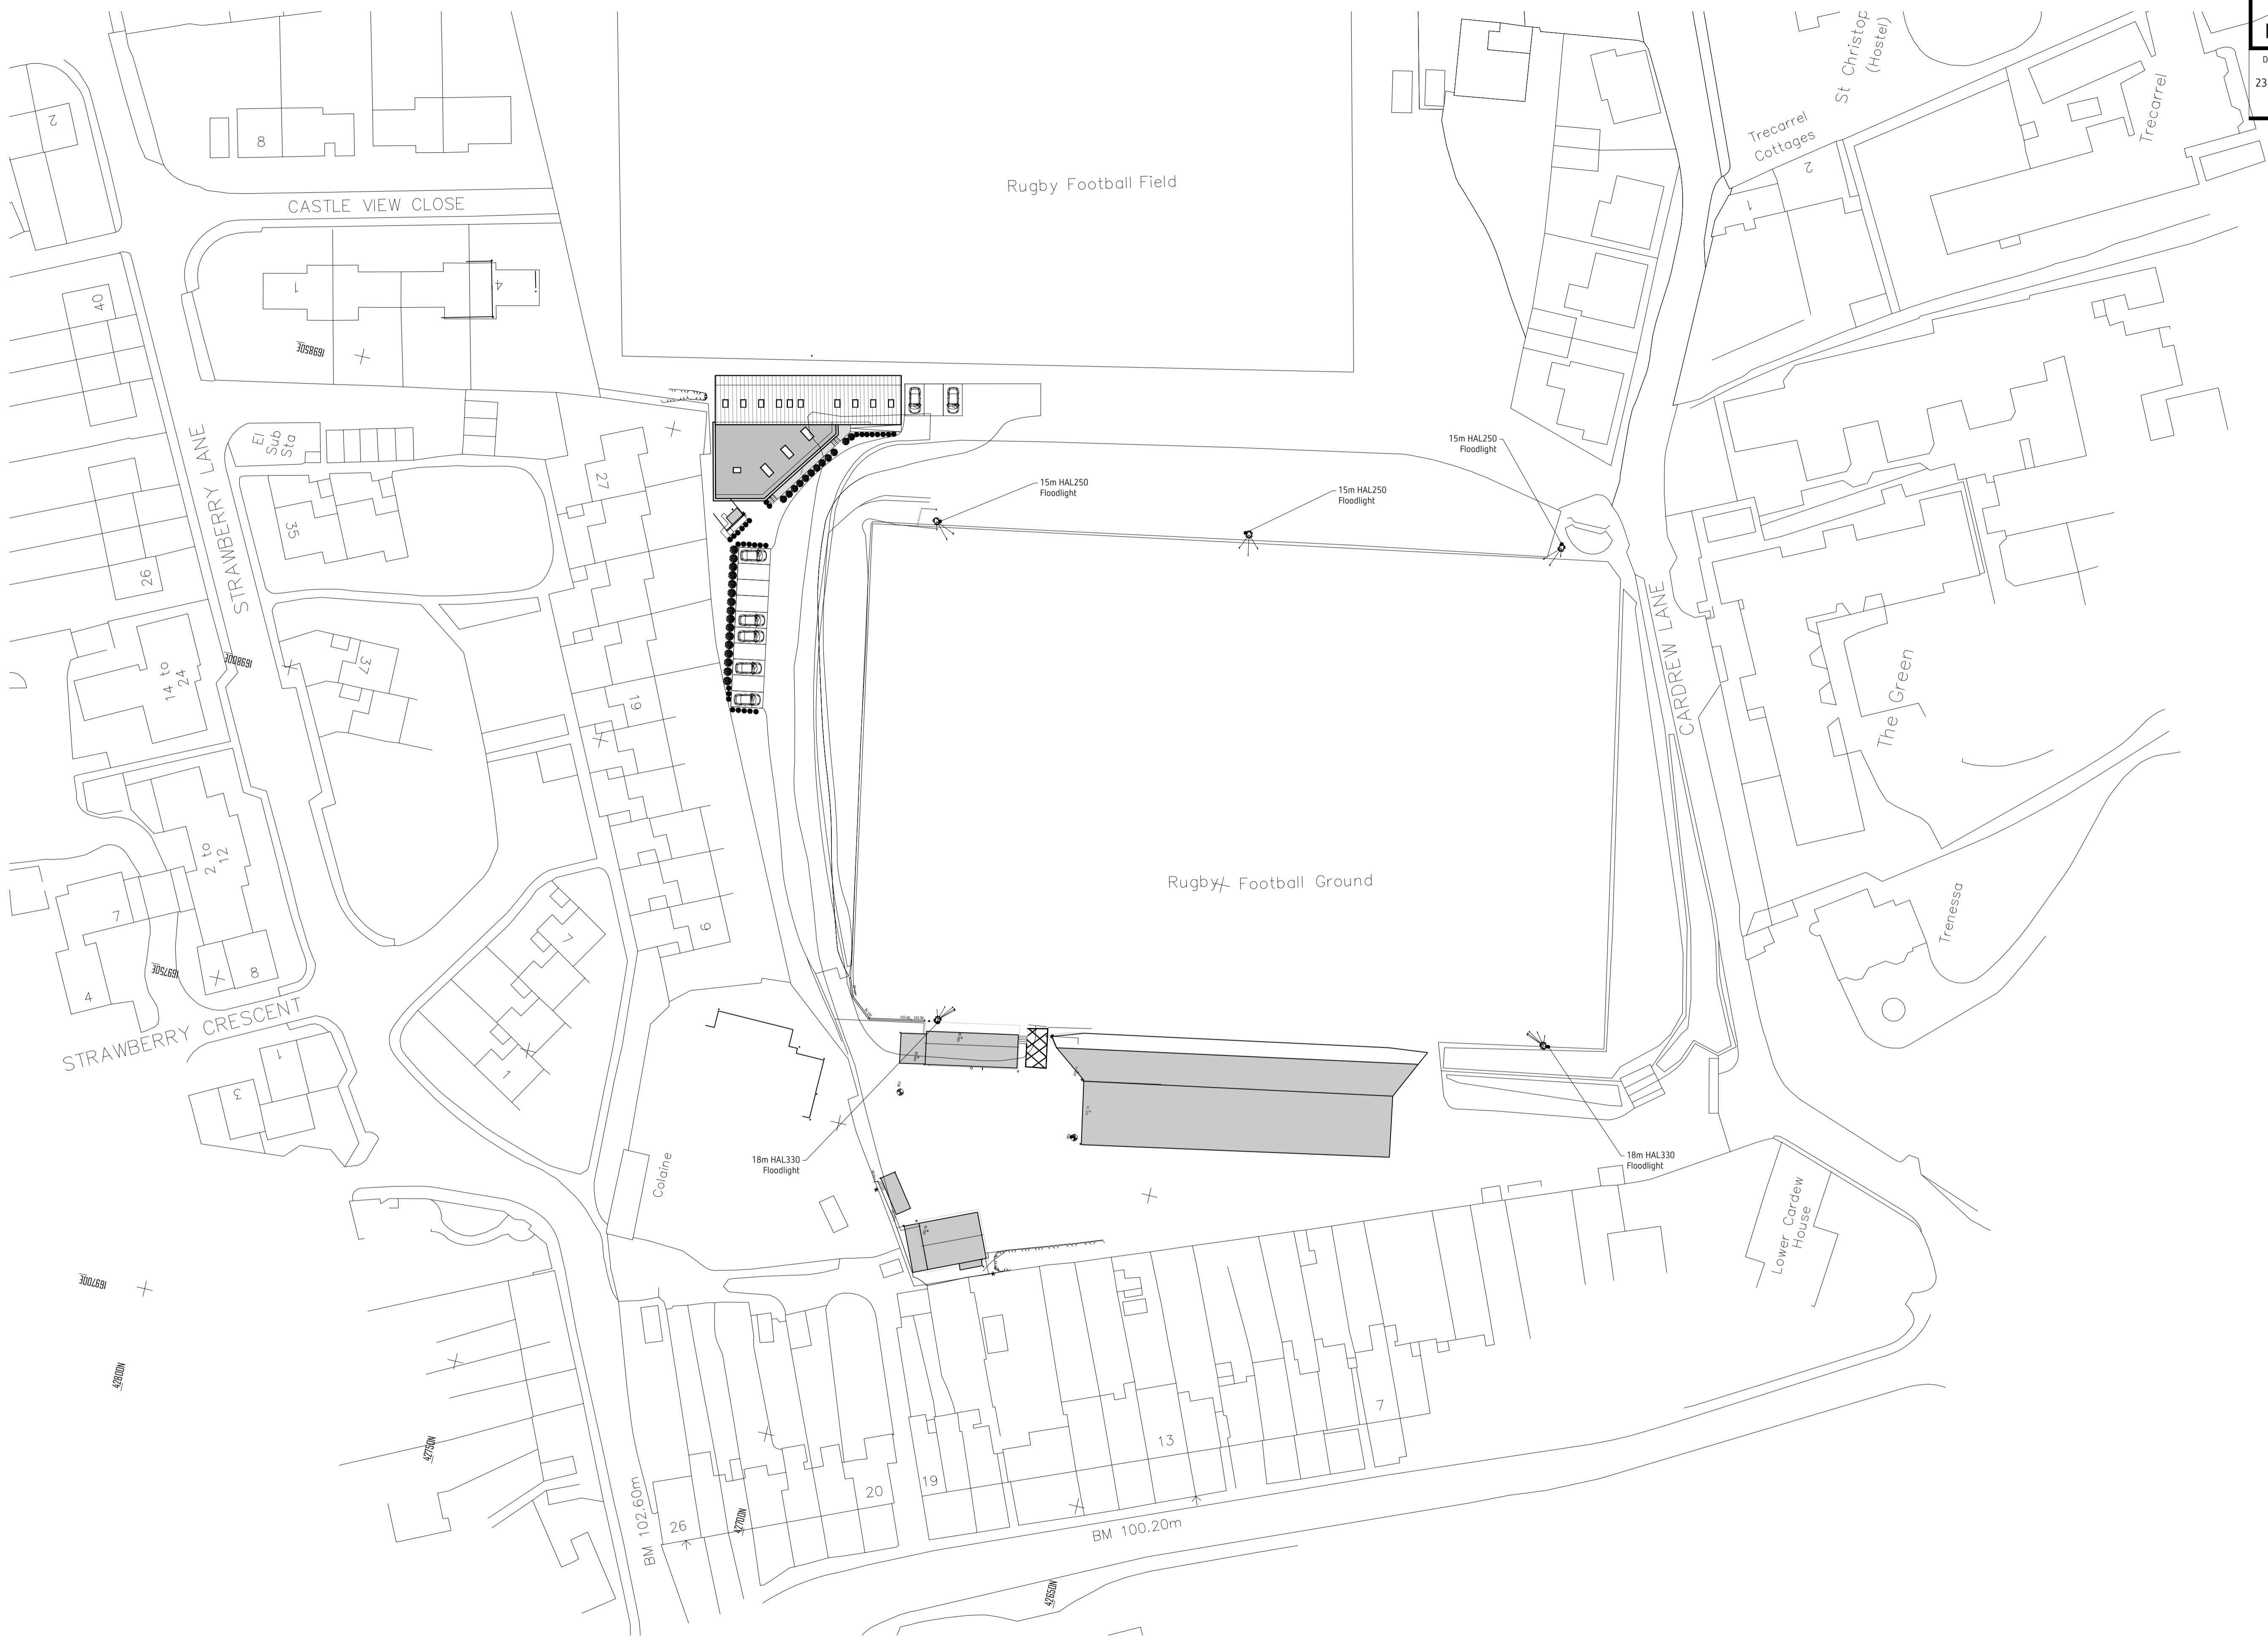


CONTRACTORS MUST CHECK ALL DIMENSIONS AND ONLY WORK FROM FIGURED DIMENSIONS - DISCREPANCIES MUST BE REPORTED IMMEDIATELY TO THE ARCHITECT TO AWAIT INSTRUCTIONS BEFORE PROCEEDING

IF IN DOUBT - ASK

DATE: 23.01.2024 REVISION: **A** - FLOODLIGHTING ADDED TO SITE PLAN

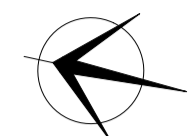

0 10 20 30 40 50 60 70 80 90 100
 1:500 @ A1 - SCALE IN METRES (SCALE 1:1000 @ A3)

PROPOSED SITE PLAN

 **BEN WHITE ARCHITECTURE LIMITED**
 T: 01872 858865 E: info@benwhitearchitecture.co.uk
 www.benwhitearchitecture.co.uk

PROJECT TITLE:
 NEW FACILITIES
 REDRUTH RUGBY CLUB
 REDRUTH

DRAWING STATUS:
PLANNING
 SCALE: @ A1

DATE:
 OCT 2022
 DRAWN: BW/AP

PROJECT NO.: **21124.3.0003** A
 STAGE: DRAWING NO.: REVISION: