




Ground Floor

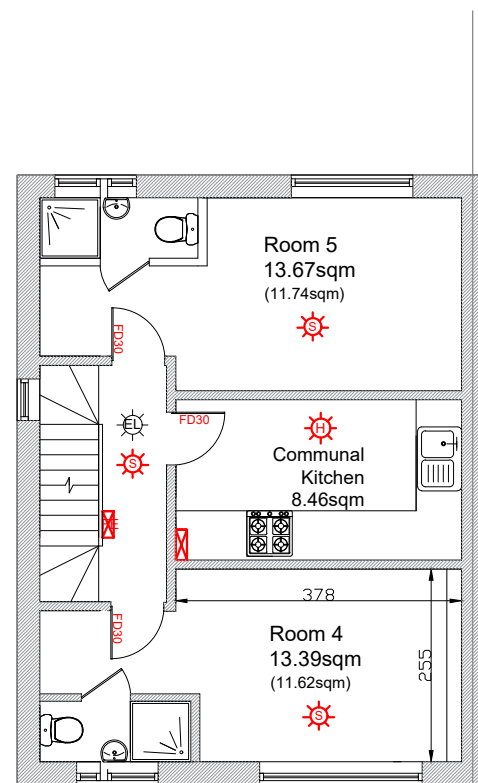

First Floor

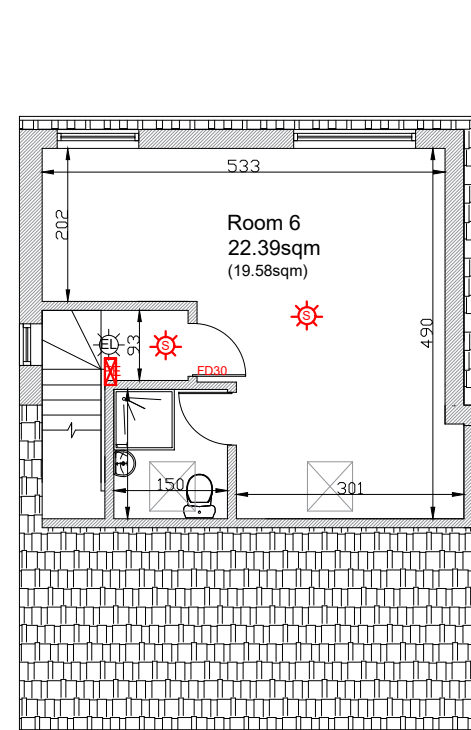

Loft

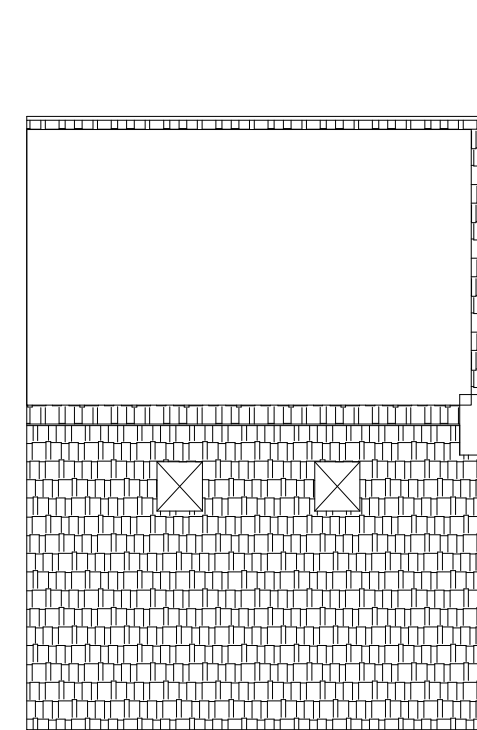

Roof

- FIRE ALARM SMOKE DETECTOR
- FIRE ALARM HEAT DETECTOR
- EMERGENCY LIGHT
- FIRE BLANKET
- FIRE EXTINGUISHER
- FIRE ALARM SWITCH BOARD



OCC, Building A
105 Eade Road
London, N4 1TJ

Tel: (020) 8150 1820
email: info@ajplans.co.uk
web: www.ajplans.co.uk

Project: 110 North Road Dartford DA1 3NB	Drawing type: PROPOSED Floor Plans		
<small>NOTES</small> The contractors are to check all the dimensions, levels, drain runs and general condition of the site before works commence a. immediately of any error omissions or discrepancies.	Date: Jan '24	Scale: 1:100 @ A3	Rev.
<small>All works are to be carried out in accordance with current Building Regulations, British Standards, Code of Practice and Local Authority Requirements. Do not scale of from this drawing.</small>	Dwg. No. NRD.110.PR.101	Drawn by. B.W	