




Ground Floor

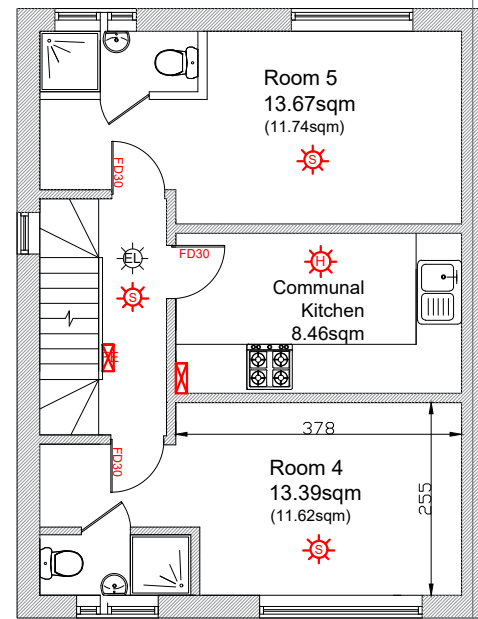

First Floor

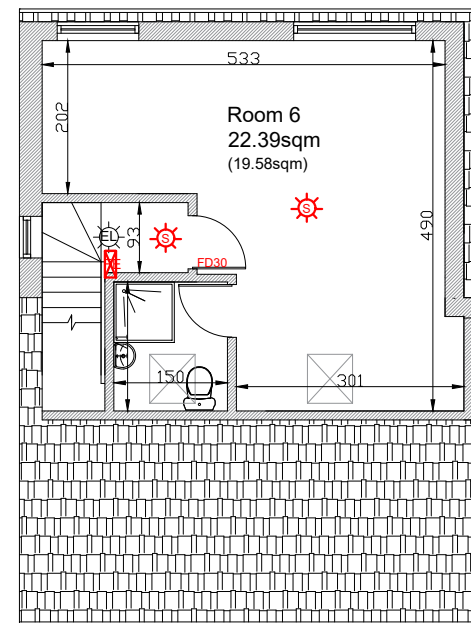

Loft

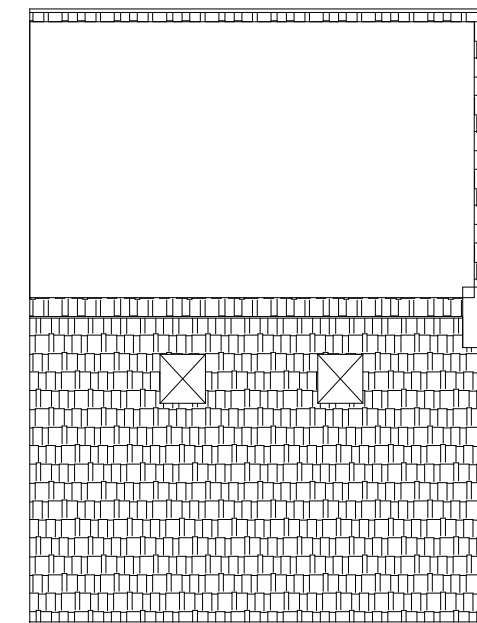

Roof

- FIRE ALARM SMOKE DETECTOR
- FIRE ALARM HEAT DETECTOR
- EMERGENCY LIGHT
- FIRE BLANKET
- FIRE EXTINGUISHER
- FIRE ALARM SWITCH BOARD



OCC, Building A
105 Eade Road
London, N4 1TJ

Tel: (020) 8150 1820
email: info@ajplans.co.uk
web: www.ajplans.co.uk

Project: 110 North Road Dartford DA1 3NB		Drawing type: EXISTING Floor Plans	
NOTES The contractors are to check all the dimensions, levels, drain runs and general condition of the site before works commence a. immediately of any error omissions or discrepancies.	Date: Jan '24	Scale: 1:100 @ A3	Rev.
All works are to be carried out in accordance with current Building Regulations, British Standards, Code of Practice and Local Authority Requirements. Do not scale of from this drawing.		Dwg. No. NRD.110.EX.101	Drawn by. B.W