


Matching materials to be used for the proposed Extension.




Proposed Front Elevations

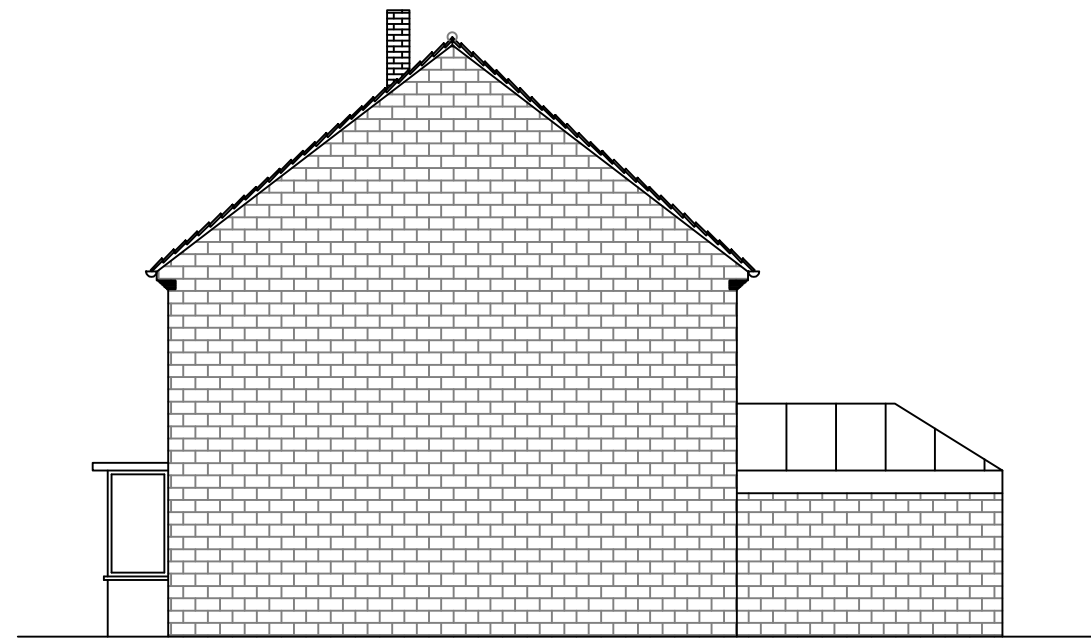

Proposed Right Elevations




Proposed Rear Elevations

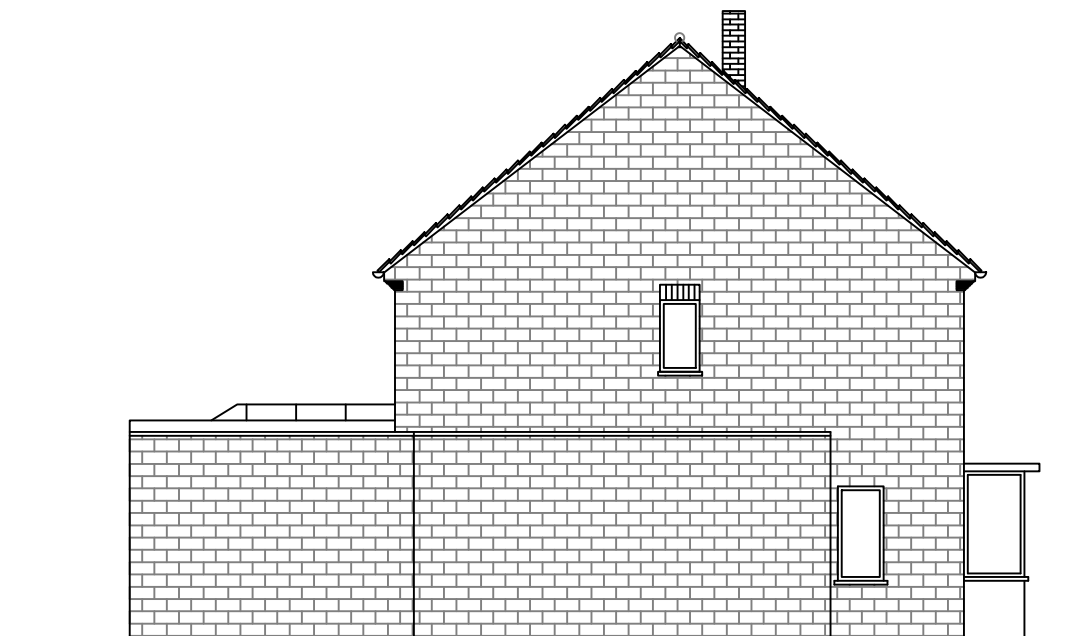

Proposed Left Elevations

 PURPOSE OF ISSUE:
Planning



DISCLAIMER

All the written dimensions to be checked on site before work commences. Discrepancies, where identified, must be reported to the designer. This drawing must not be reproduced or used in conjunction with any unauthorized person either wholly or in part without valid consent.

Notes to Contractor

Contractor to check and Verify all levels, dimensions etc before construction commences.

Notes to Building Owner

Building owner is advised to ensure that the position of the boundary (line of junction) is confirmed /agreed with the adjoining owner/s before constructing any structure

Notes on Drainage

Existing drainage layout to be exposed and confirmed on site by the contractor before commencing any foundation work. Connect all new drainage to existing mains sewer, in accordance with Part H of Building Regulations, Thames water guidelines and to comply with BS 5572.

PROJECT ADDRESS

62 Bridge Road, DA8 2DQ

PROJECT DESCRIPTION

Side Extension

DRAWING TITLE

Proposed Elevations



DRAWN BY: AYR

CHECKED BY:

SCALE: 1:100 @ A3

DRAWING NO: XLN04

DATE: 10/01/2024

REVISION NO: 0