



SITE PLAN
SCALE 1:500

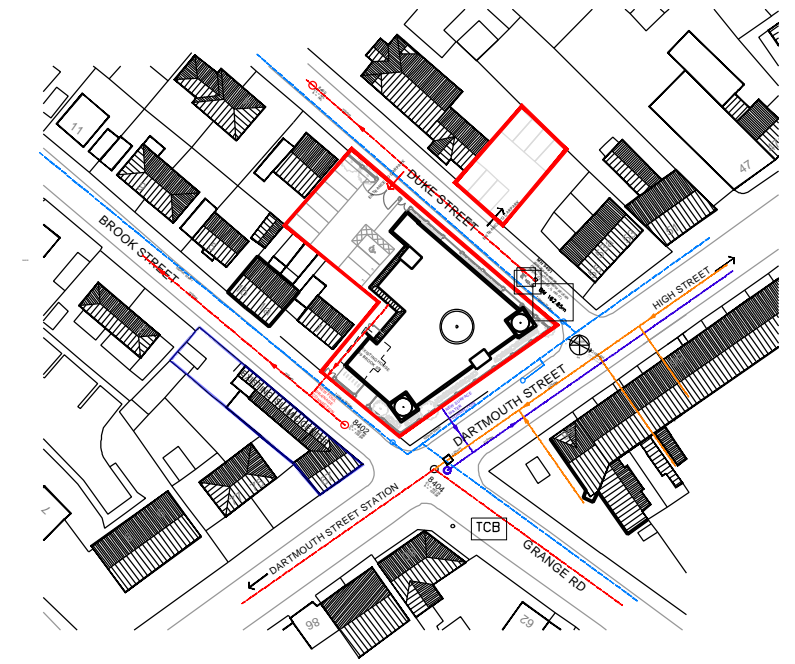

LOCATION PLAN
SCALE 1:1250

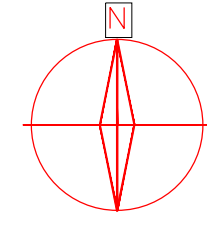

DRAINAGE NOTES

- PUBLIC SURFACE WATER GRAVITY SEWER
- PUBLIC FOUL GRAVITY SEWER
- PUBLIC COMBINED GRAVITY SEWER

REFER TO SEVERN TRENT WATER SEWER RECORD DWG ISSUED 04.09.12

WATER NOTES

- MAIN - EXISTING


REFER TO SOUTH STAFFS WATER DWG ISSUED 11.09.12

REVISIONS:

A	19-12-2023	DRAWING UPDATED TO INCLUDE ADJACENT LAND IN OWNERSHIP BOUNDARY, VACANT SITE AND EXISTING MOSQUE, DRAINAGE AND WATER INFORMATION ADDED	UH
---	------------	---	----

PROJECT PHASE

RIBA STAGE 3: DEVELOPED DESIGN

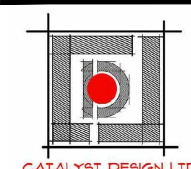

CATALYST DESIGN LTD
ARCHITECTURAL SERVICES
BRANSTON COURT, BRANSTON STREET
JEWELLERY QUARTER, BIRMINGHAM B18 6BA
Tel: 0121 523 0895
www.catalystdesignltd.co.uk

CLIENT

WEST BROMWICH BANGLADESHI MUSLIM ASSOCIATION AND ISLAMIC CENTRE

PROJECT

[REDACTED] & COMMUNITY CENTRE

DRAWING No.	REVISION	DRAWING TITLE
1717 - 210	-	PROPOSED SITE DRAINAGE PLAN
SCALE 1: 500 @ A3	CHECKED MAB	DATE DEC23 DRAWN UH