



Tanks

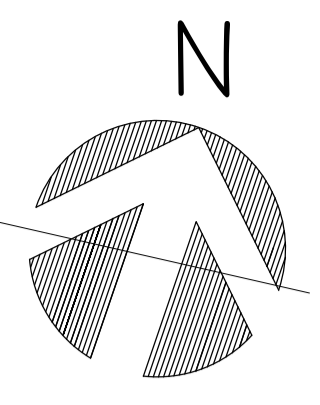

© 2013 PPL (Northampton) LTD

**Notes:**

1. If this drawing has been received electronically it is the recipient's responsibility to print the document to the correct scale.
2. All dimensions are in millimeters unless stated otherwise. It is recommended that information is not scaled off this drawing.
3. This drawing should be read in conjunction with all other relevant drawings and specifications.
4. All boundaries, dimensions and levels are to be checked on site before construction and any discrepancies are to be reported to the Architect.
5. For the purpose of coordination, all relevant parties must check this information prior to implementation and report any discrepancies to the Architect.

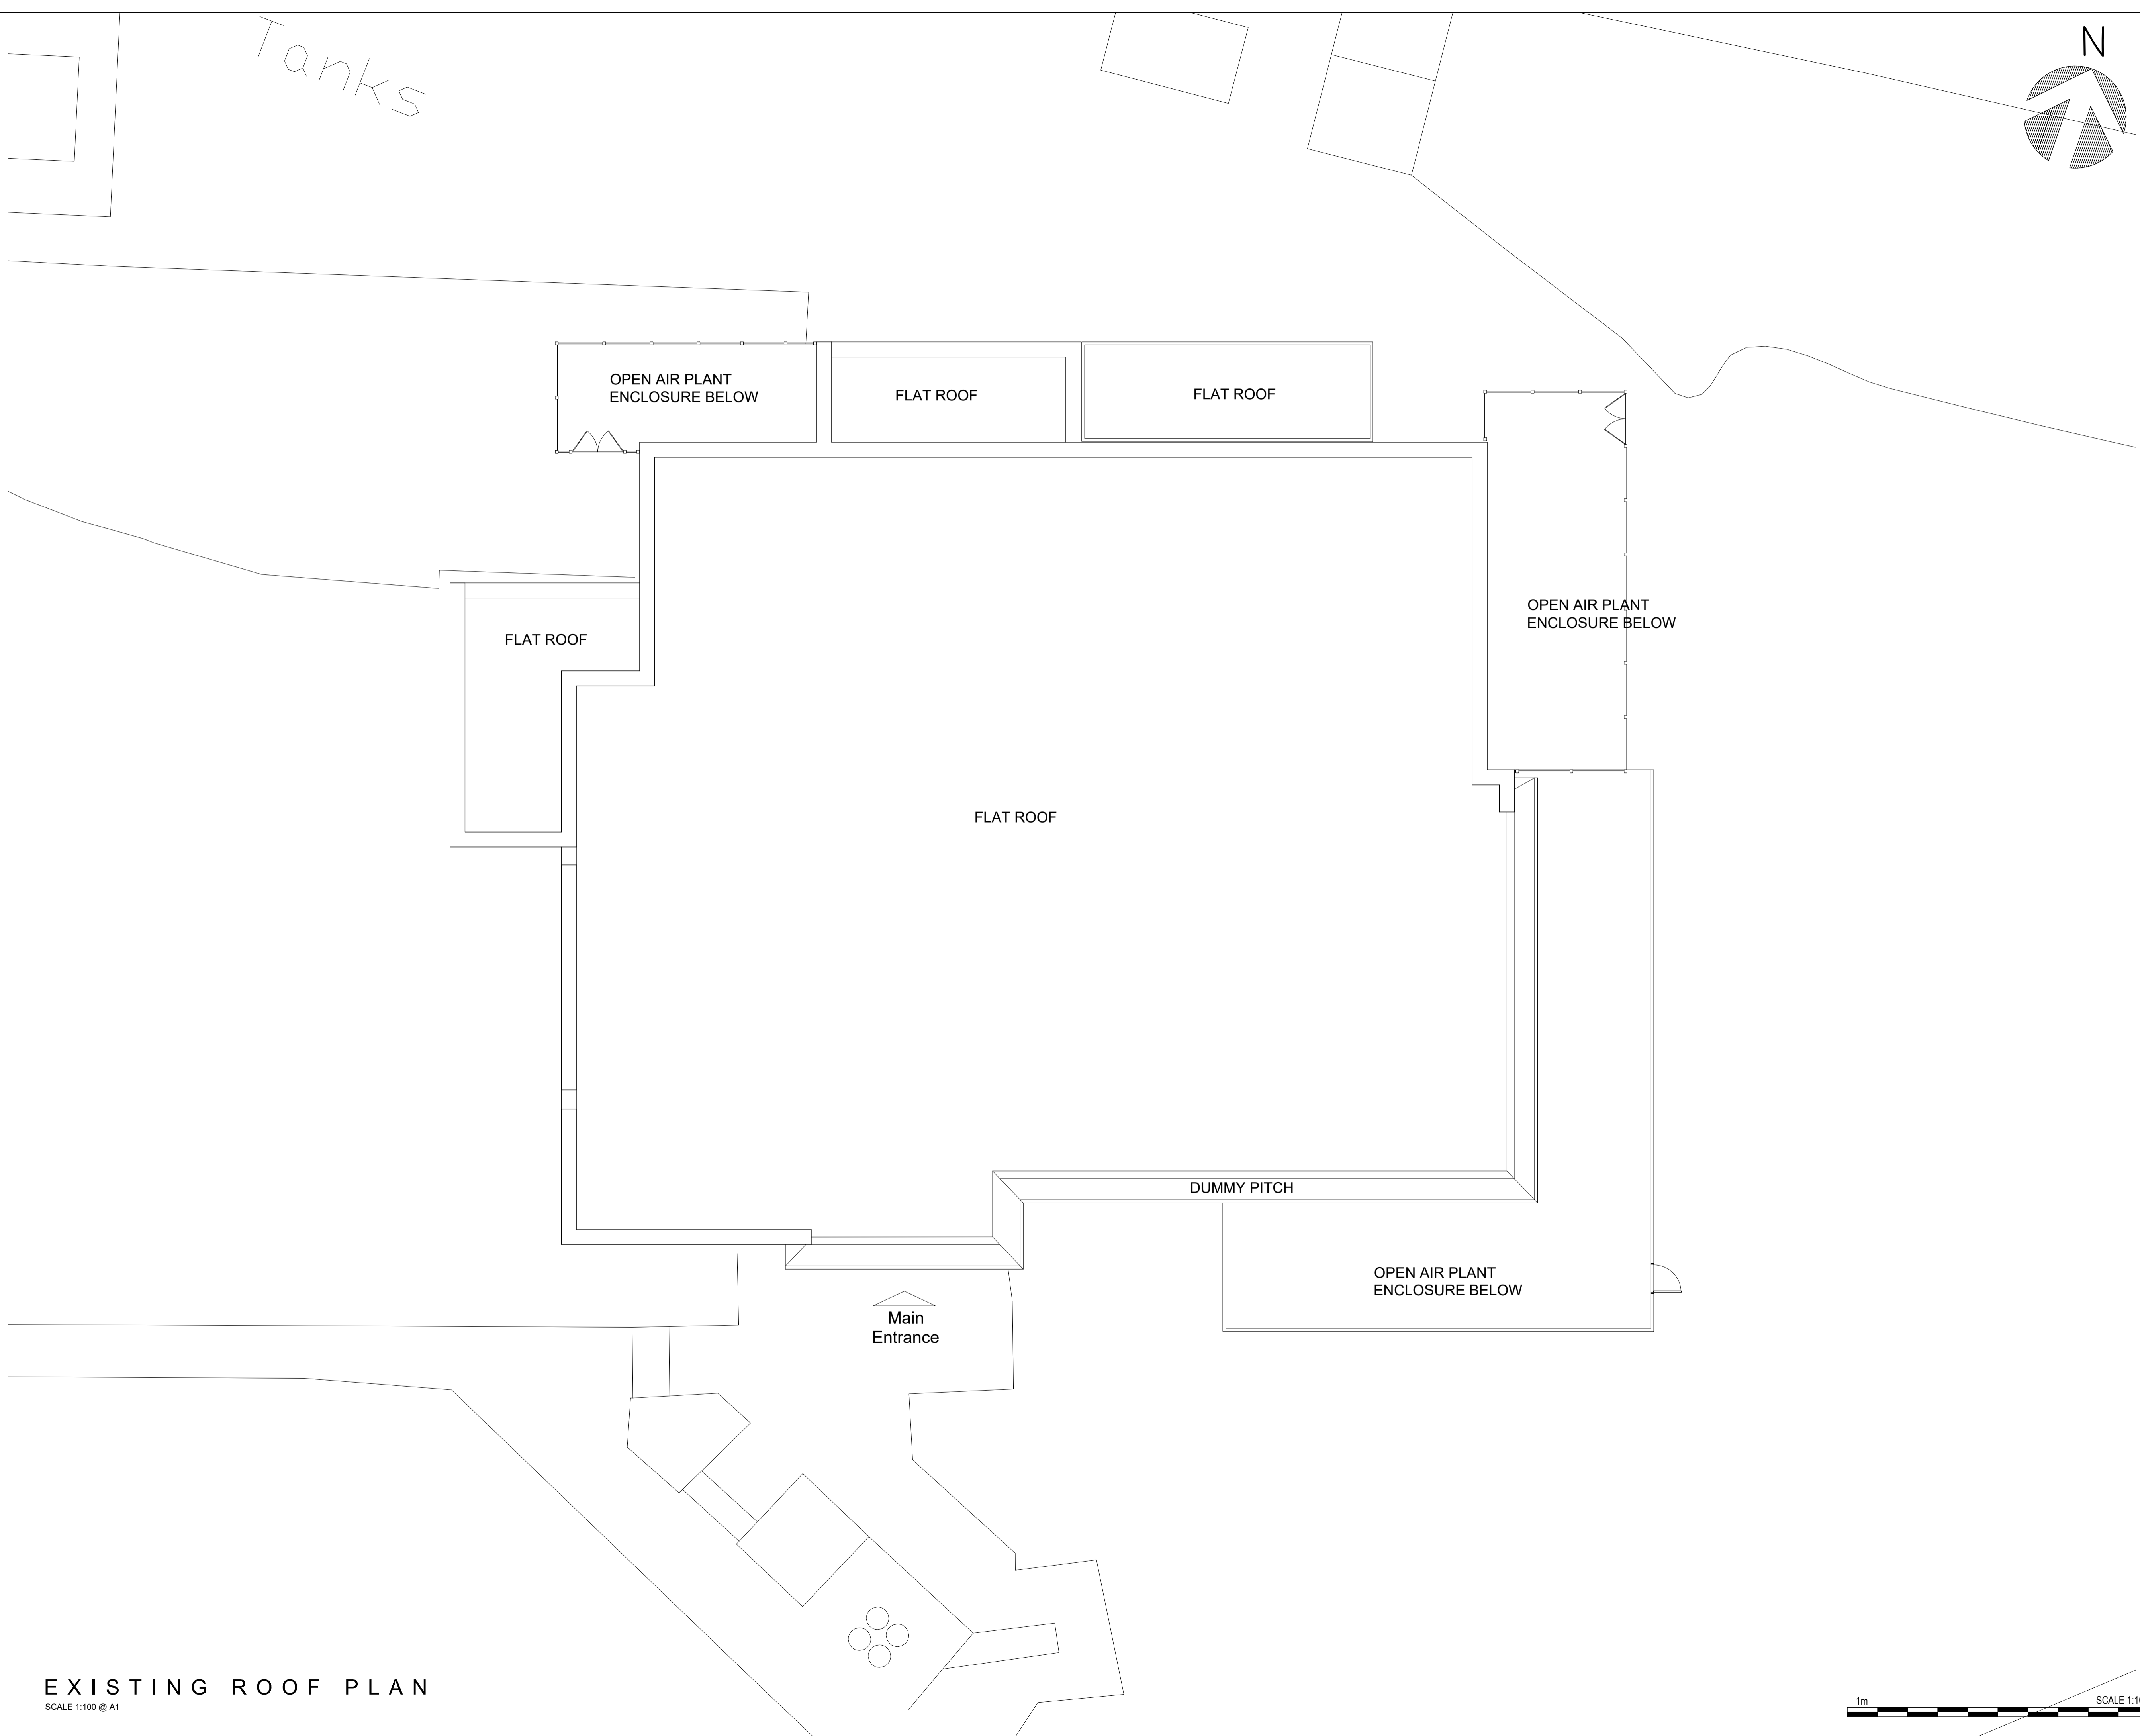

**EXISTING ROOF PLAN**  
SCALE 1:100 @ A1

Rev. No	Date	Revision	Drawn by	Checked

Client



Project  
 ROWNHAMS NORTH MOTORWAY SERVICE AREA  
 M27 Northbound  
 Southampton SO16 8AP

Drawing

**EXISTING ROOF PLAN**

ARCHITECTURE DESIGN DEVELOPMENT 	Studio 3 The Drive ~ Kettering NN15 7EX T: 01536 430499
	Scale: 1:100@A1 Date: 06.09.23 Drawn by: JCA Job No: RC578 Drg No: 202 Rev No:

