

Abbreviations (Where Applicable)


ACO	ACO Channel	IL	Invert Level
AH	Arch Height	LH	Loft Hatch
BL	Bollard	LP	Lamp Post
BWK	Brickwork	MH	Manhole
C	Cill Height	MW	Mat Well
CCU	Consumer Control Unit	OV	Oven
C-H	Cill to Head Height	PC	Pre-Cast
CHL	Chainlink	RAD	Radiator
CL	Cover Level	RE	Rodding Eye
CLG	Ceiling	RL	Roof Light
CL	Centre-Line	RWP	Rainwater Pipe
CONC	Concrete	SC	Stopcock
CTV	Cable Television	SPH	Arch Springer Height
EM	Electricity Meter	SS	Stub Stack
EXT	Extract Fan	SVP	Soil & Vent Pipe
FAI	Fresh Air Inlet	TB	Telecoms Box
FF	Fridge/Freezer	TBR	Timber
G	Gully	TL	Traffic Light
GM	Gas Meter	TP	Telephone Pole
HT	Height	UTL	Unable To Lift
HTR	Heater	WM	Washing Machine
HY	Hydrant	WP	Waste Pipe
IC	Inspection Chamber	WTM	Water Meter

(2.40)	Floor to Ceiling Height	(2.40) SC	Floor to Suspended Ceiling Height	↔	Jolist direction
--------	-------------------------	-----------	-----------------------------------	---	------------------

Notes

1. This drawing is copyright © and should not be reproduced either in whole or in part without prior approval. Read in conjunction where applicable with all relevant consultant and sub-contractor drawings.
2. Do not scale unless issued for Town Planning approval. Work to figured dimensions only. All dimensions and levels are in metres unless otherwise indicated.
3. Drawing based on survey dated 16.12.23. All levels relate to TBM, arbitrary value 50.000m, located on verge opposite site.

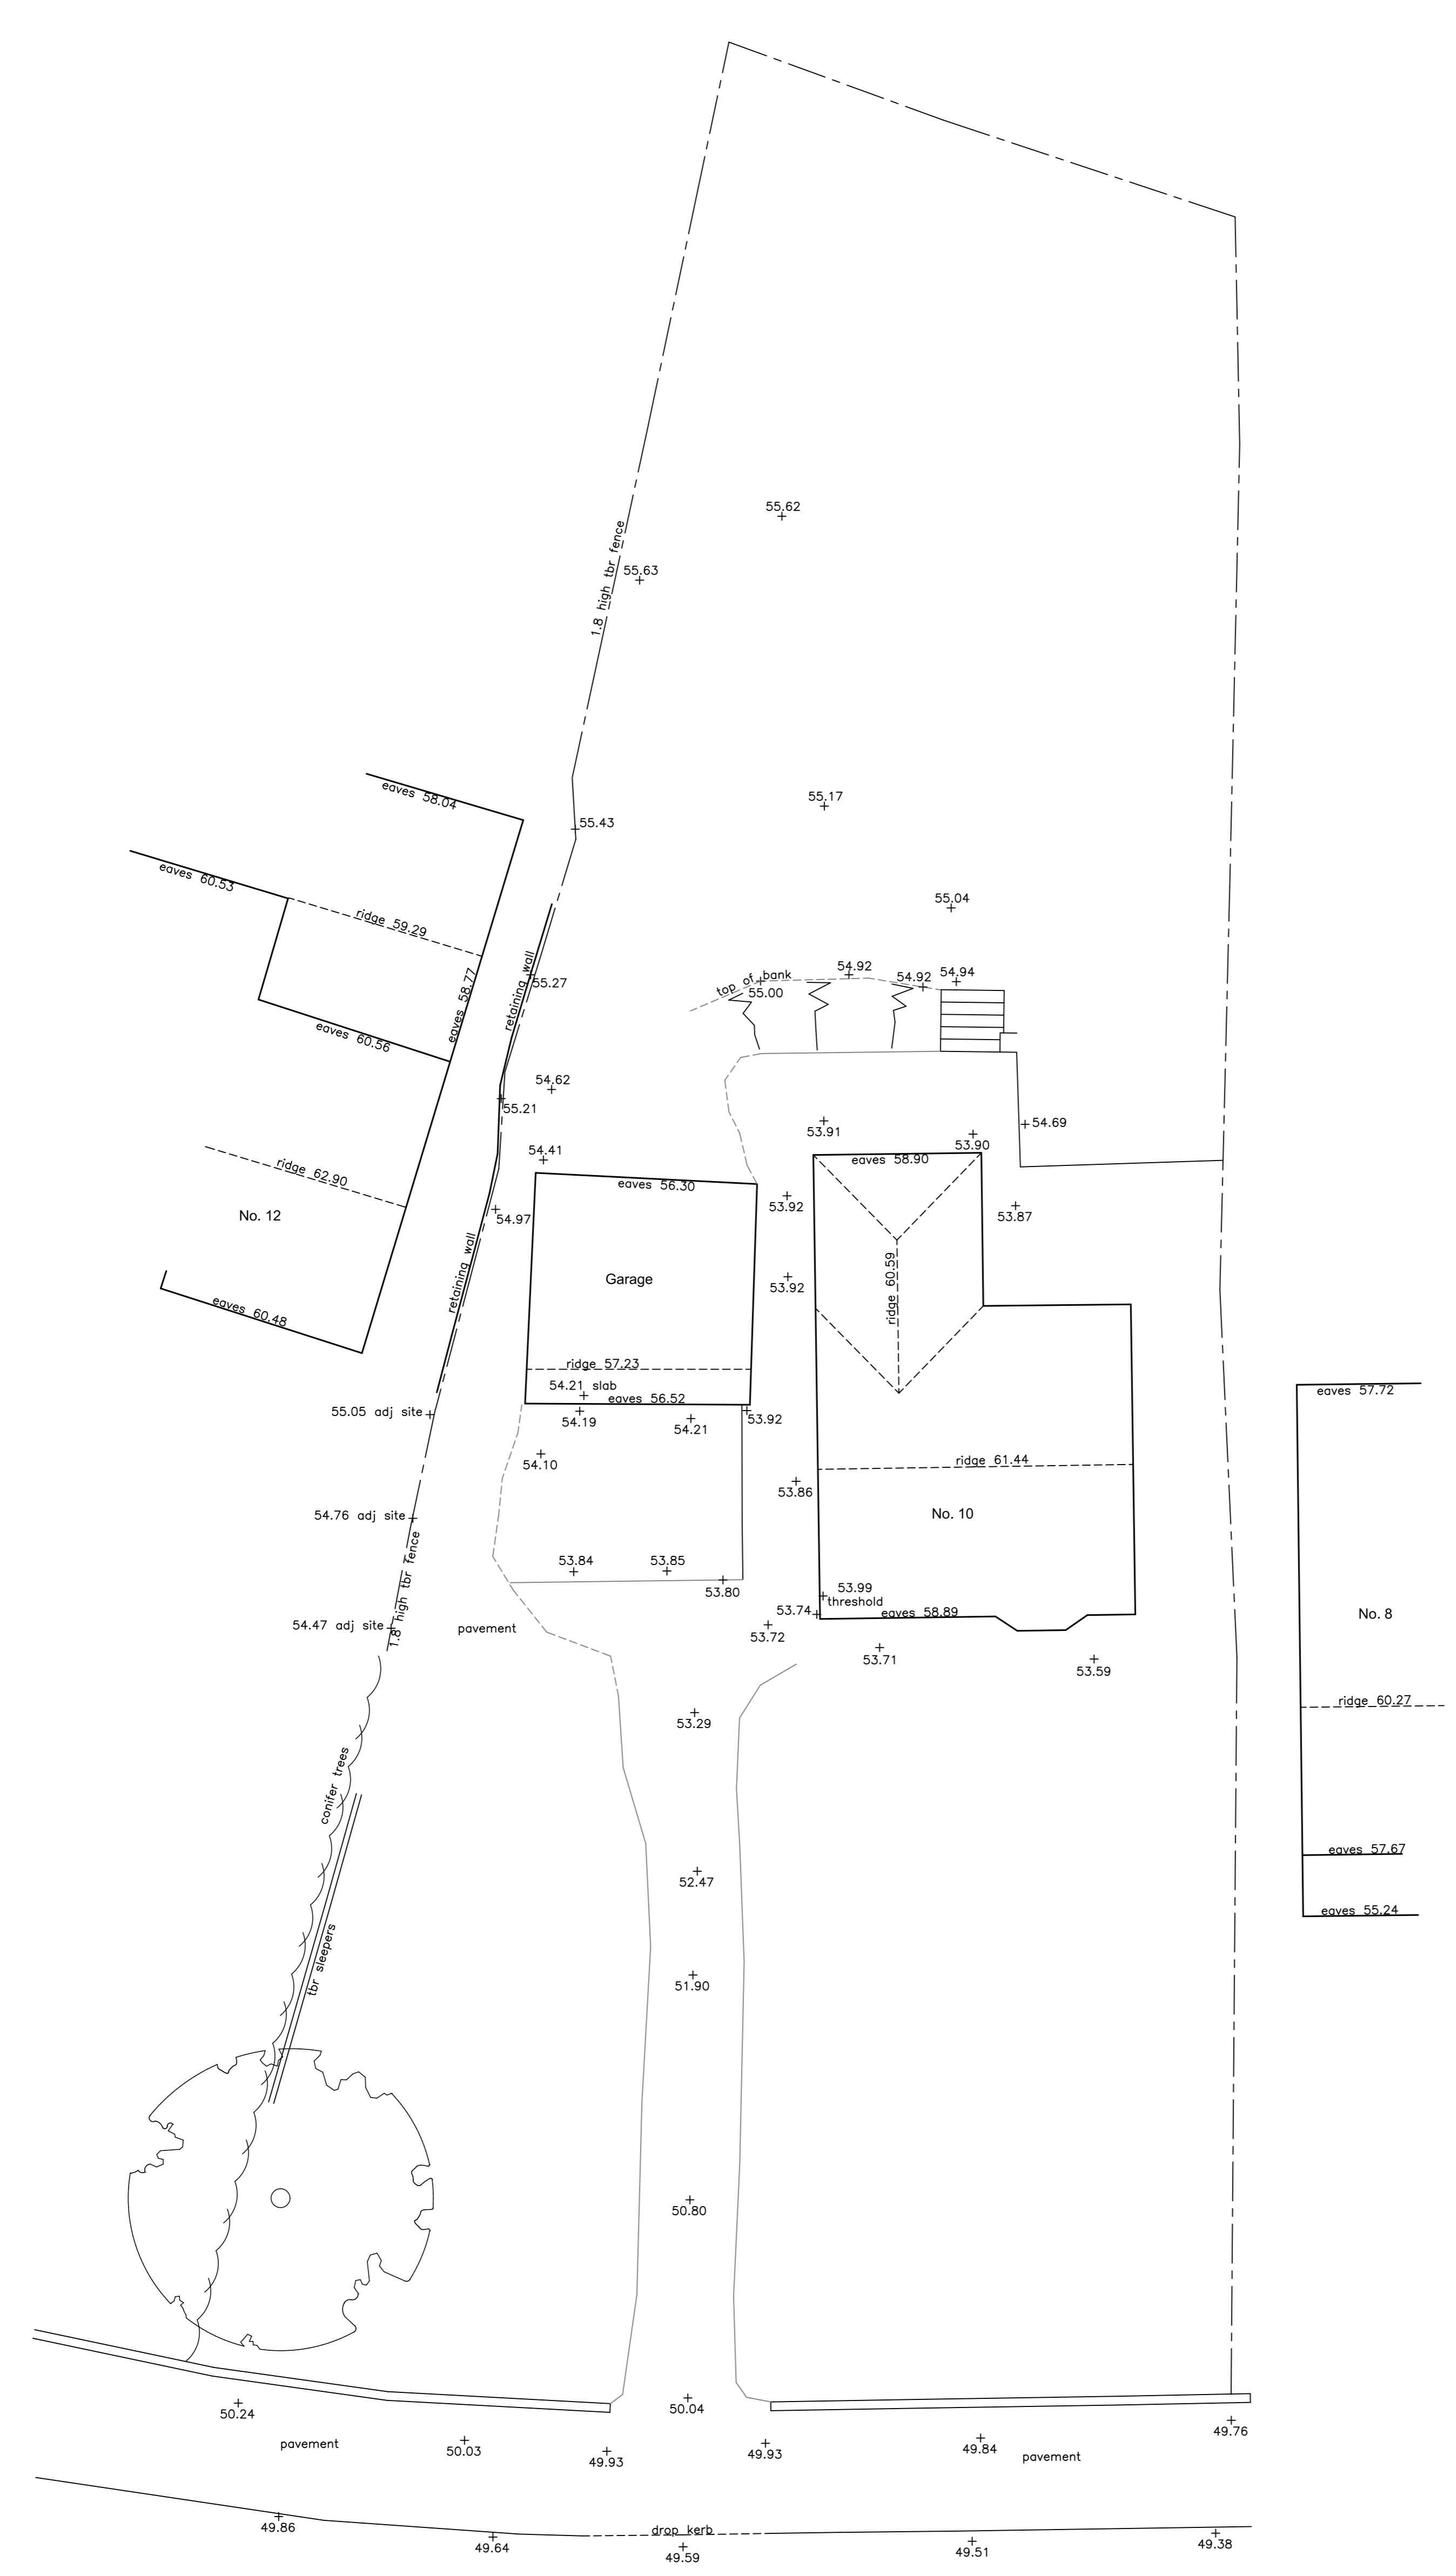

KINDERSLEY WAY

Rev.	Date	Revisions
<b>PAUL ADAMS</b> MEASURED BUILDING SURVEYS & FLOOR PLANS "THE HIVES", 43 NEVILLE ROAD LIMBURY, LUTON, BEDFORDSHIRE, LU3 2JG Tel. 07792 252884 info@pasurveys.co.uk		
Client		ARCHITECTURAL DRAWING SERVICES
Address		10 KINDERSLEY WAY ABBOTTS LANGLEY HERTFORDSHIRE WD5 0DQ
Drawing Title		SITE PLAN AS EXISTING
Scale		1:100 @ A1
Date	Dec 2023	Drawn PA
Drawing No.		PA446-01
		Rev.