


EXTERNAL LIGHTING PLAN

TAYLORS FARM, LONG LANE, SCORTON

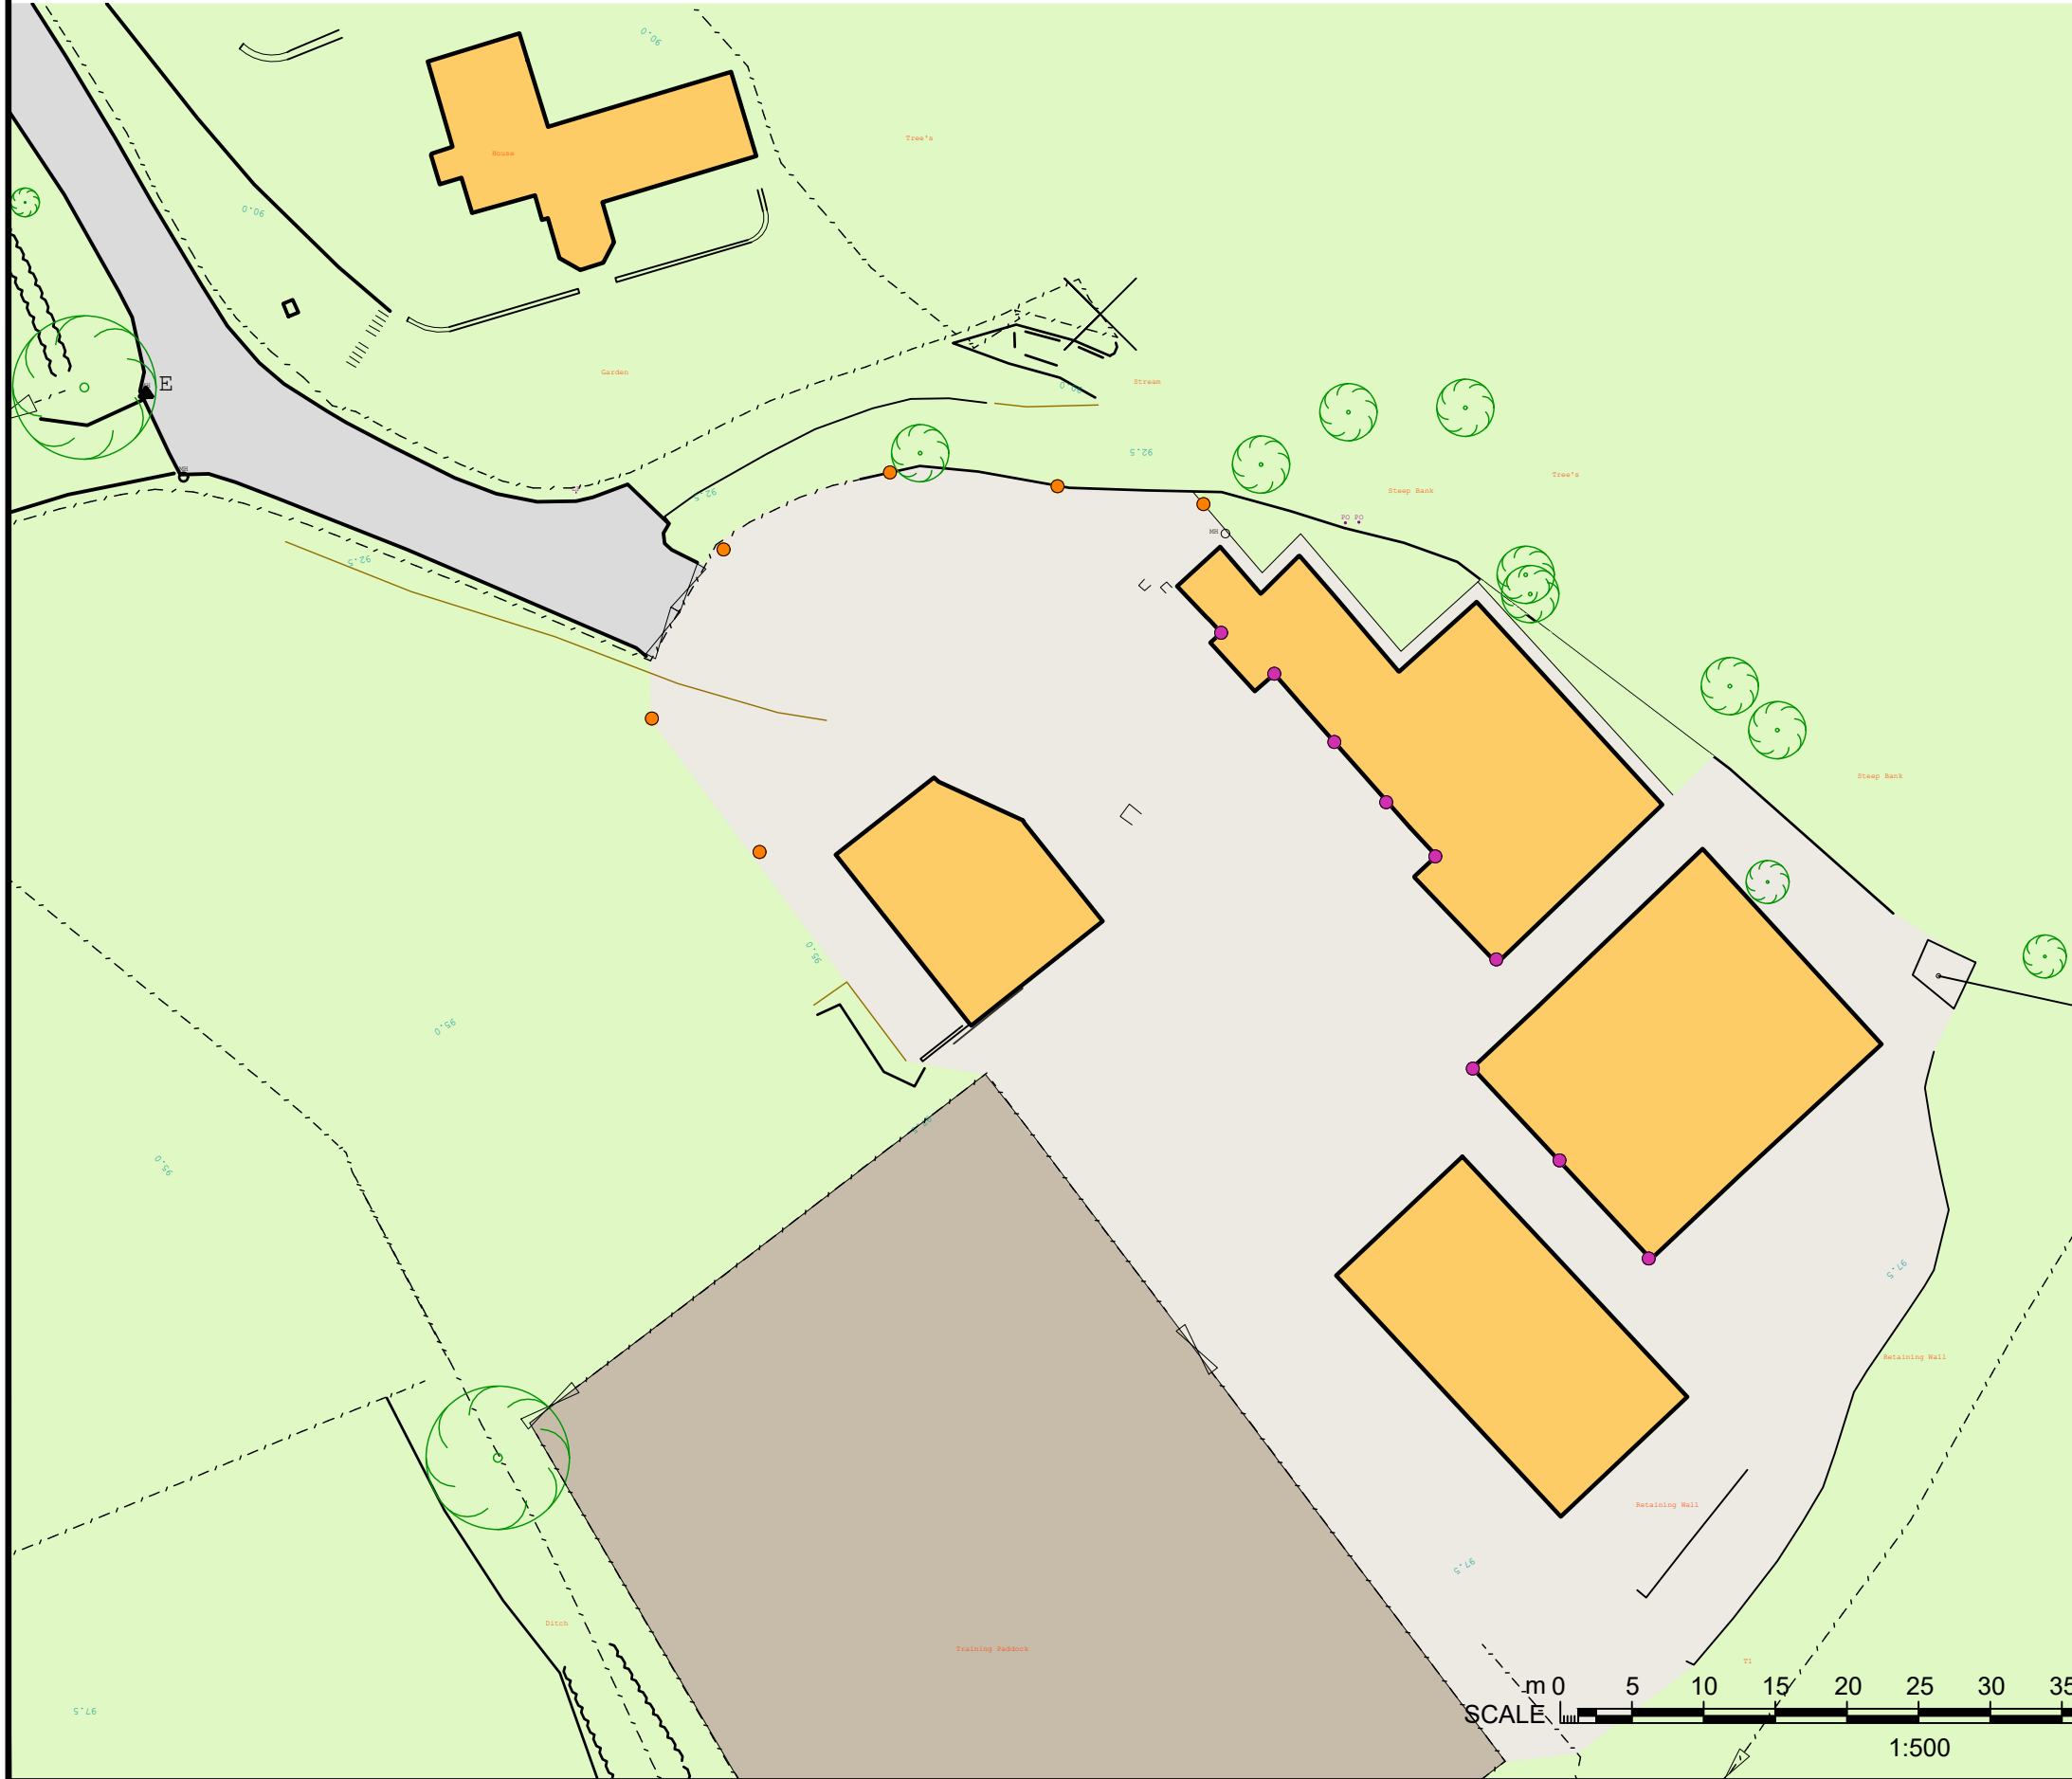

KEY



○ LIGHTING BOLLARDS
(refer to the attached specifications)



● WILD LIFE SENSITIVE LIGHTING
(refer to the attached specifications)



	
2 CROSTON VILLA HIGH STREET GARSTANG PRESTON PR3 1EA	
T: 01995 604514 E: Info@GrahamAnthonyAssociates.com W: www.GrahamAnthonyAssociates.com	DWG STATUS PLANNING PURPOSES ONLY
CLIENT MR HINDE	DRAWING TITLE / PROJECT EXTERNAL LIGHTING PLAN : TAYLORS FARM, LONG LANE, SCORTON
DRAWING No. GA3180-COND21-01	SCALES: 1:500 (A3)
DATE JAN 24	ALL DIMENSIONS TO BE CHECKED ON SITE AND ANY DISCREPANCIES TO BE REPORTED TO GRAHAM ANTHONY ASSOCIATES PRIOR TO PROCEEDING WITH ANY WORKS. DO NOT SCALE OFF DRAWING AND REFER TO WRITTEN DIMENSIONS. THIS DRAWING IS SUBJECT TO COPYRIGHT ©

