

PLANNING



GENERAL NOTES

1. No dimensions to be scaled from this drawing
2. Any discrepancies found between this drawing and other documents should be referred immediately to the consultants
3. This drawing should be removed from currency immediately a revised version is issued
4. This drawing is copyright.
5. All dimensions in mm's.


Dimensioning -

1. **IMPORTANT** - All dimensions taken from finished face unless otherwise stated, if in doubt confirm before proceeding.
2. Dimensions followed by [ref] indicates reference dim, these should be used as check dims only and not as the primary source for setting out.
3. Dimensions followed by [s/o] indicates dim of structural opening.
4. Dimensions followed by [site] indicates dims subject to site conditions.


- LEGEND**
- SD Smoke detector (mains fed)
 - HD Heat detector (mains fed)
 - E Escape route
 - TH Top-hung Velux-type rooflights
 - A Assembly points in case of emergency
 - F30 fire compartmentation

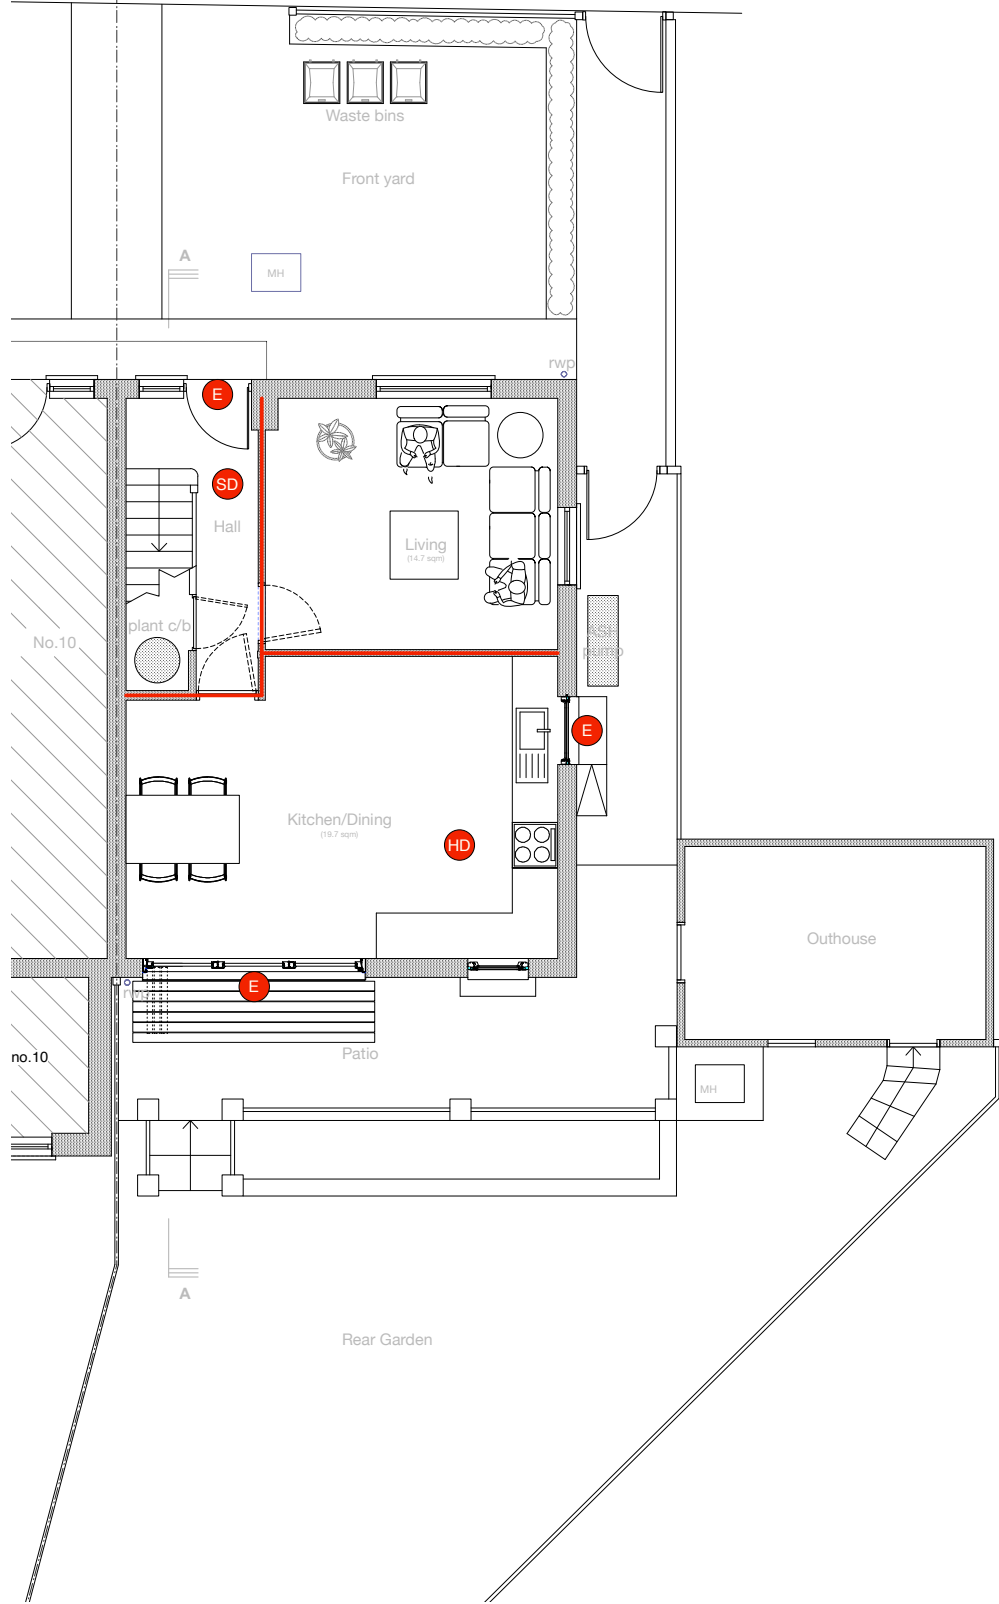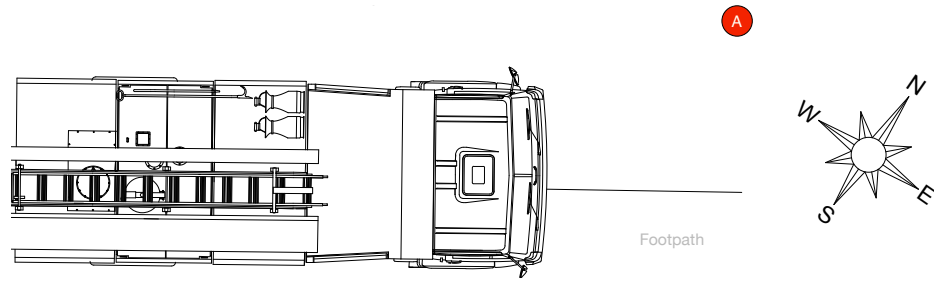


GROUND FLOOR PLAN
Scale 1:100 @ A3

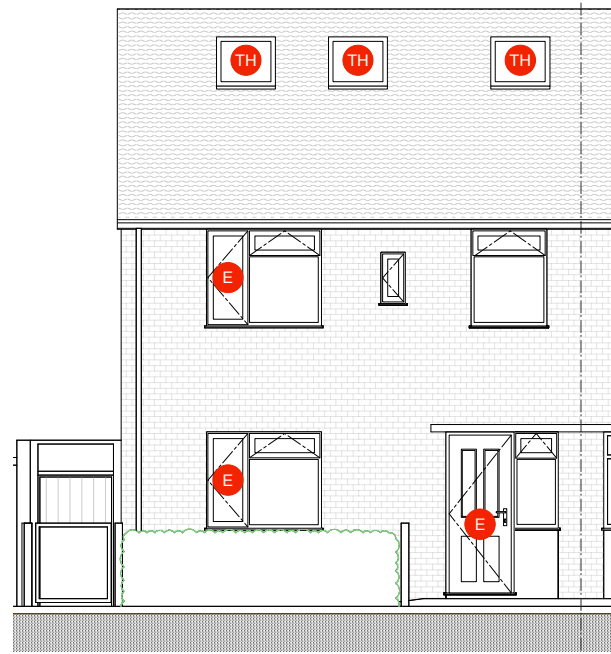


FRONT ELEVATION
Scale 1:100 @ A3

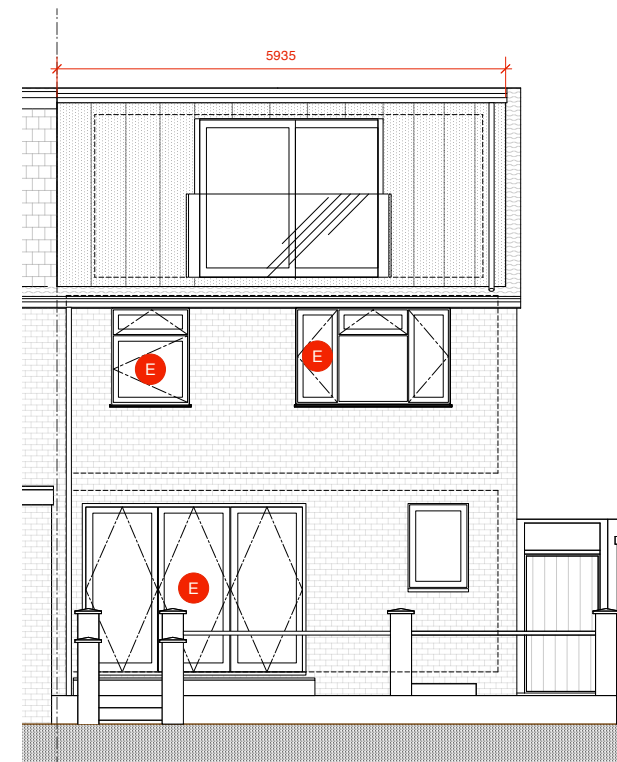


REAR ELEVATION
Scale 1:100 @ A3

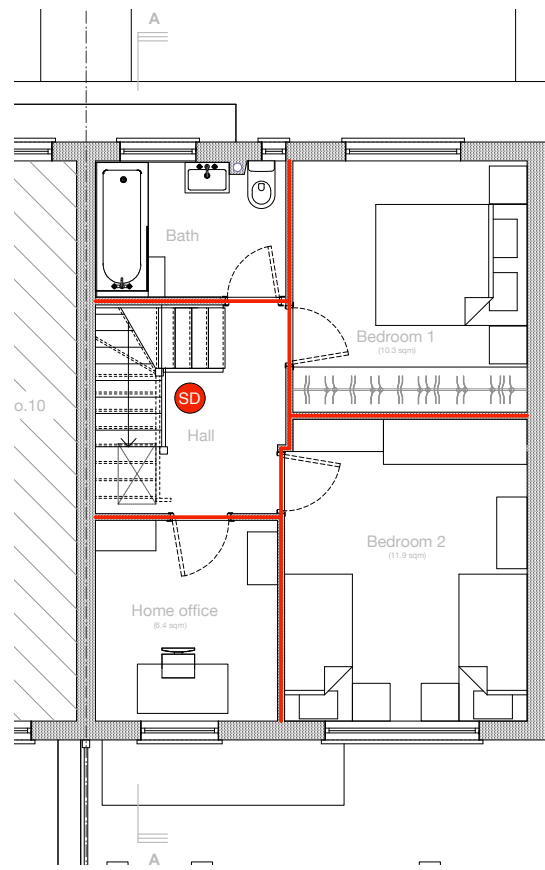

FIRST FLOOR PLAN
Scale 1:100 @ A3

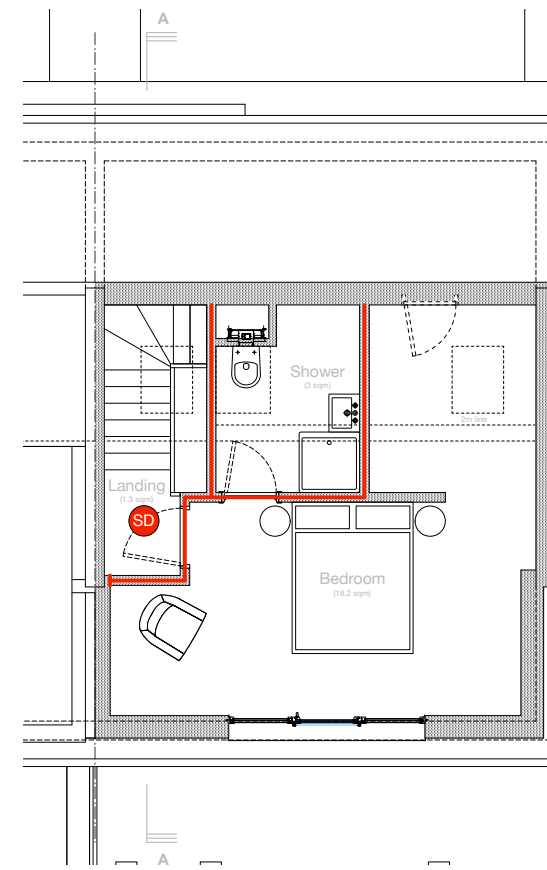

SECOND FLOOR PLAN
Scale 1:100 @ A3

 

REV	DESCRIPTION	DATE	NAME
PL1	ISSUED FOR PLANNING	23/02/24	TD

denhofdesign
Architectural services | Passivhaus Design
Garden flat 153 Norwood High Street
London SE27 9TB
m - 077 8899 3396
e - info@denhof-design.com

PROJECT TITLE

9 WANLEY ROAD
LONDON
SE5 8AT

DRAWN	TD	SCALE	1:100 @ A3 1:50 @ A1
DATE	07/06/23		

DRAWING TITLE
FIRE SAFETY STRATEGY DRAWING

JOB NO	DRAWING NO	REV
2307	01.010	PL1

Scale bar in mm