
 


PROPOSED GROUND FLOOR PLAN

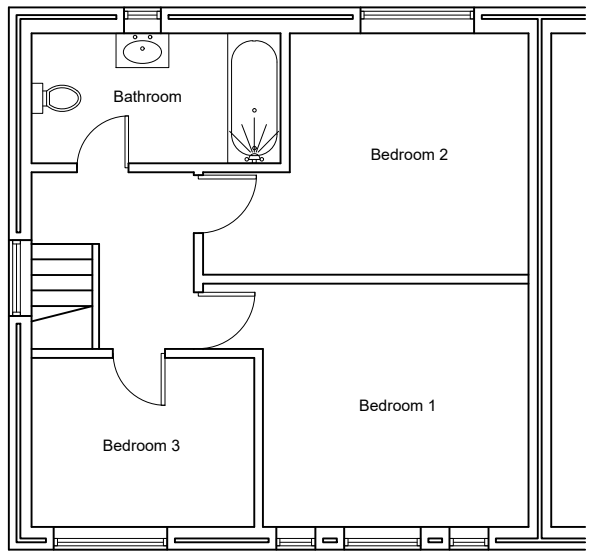

PROPOSED 1st FLOOR PLAN



**NOTES :-**  
 These drawings are solely for the purpose of seeking planning and building regulation approvals, they are not a specification of work and DAK draughting Ltd accepts no liability should they be used for any other purpose  
 All drawings are to be read in conjunction with specialist design elements and structural engineers notes. Any works carried out prior to approval is done at the clients / builders risk  
 The contractor is responsible for checking all scaled and stated dimensions prior to any activity commencing or orders being placed  
 Any boundaries shown on the plans are assumed location and the client / contractor must check the precise location of any boundaries prior to commencement and ensure work does not take place across boundaries or outside of any given approval  
 The client is responsible for ensuring all required approvals have been granted and all matters relating to Party walls have been resolved in accordance with the Party Wall act 1996 prior to commencing building works  
 All drainage layouts shown on the plans are indicative only  
 DAK Draughting Ltd will not be liable for the accuracy of any hidden details such as wall construction, lintels, existing beams, foundations, drainage etc. It is the responsibility of the client and the contractor to expose all hidden features prior to commencement of any building works  
 This drawing is the copyright of DAK Draughting Ltd and must not be copied, reproduced or replicated in any way without prior consent

REV A 05 / 01 / 2023  
 Amended roof over proposed sitting area and over pond

**DAK Building Design**  
 tele :- 01590 615139

CLIENT  
 SITE 25 TEDDER WAY  
 TOTTON  
 SO40 3FZ

DRAWING  
 PROPOSED FLOOR PLANS

DRAWING No. DAK / TW / 06  
 SCALE 1 : 100 @ A3 (printed to scale)  
 DATE :- 27 / 09 / 2023 DRAWN BY:- DAK