





EXISTING FRONT ELEVATION
(scale 1:100)

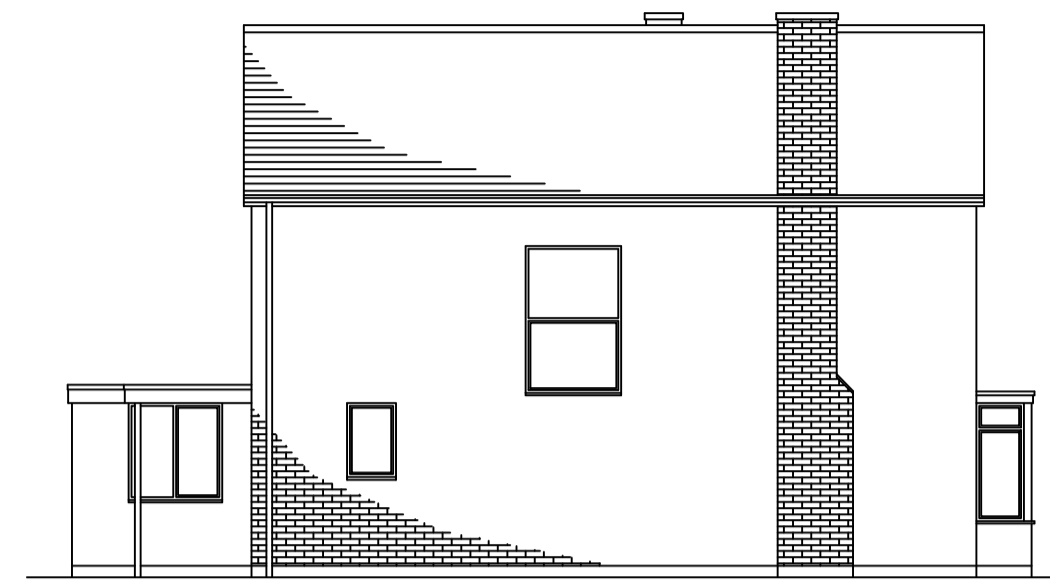


EXISTING SIDE ELEVATION
(scale 1:100)




EXISTING REAR ELEVATION
(scale 1:100)

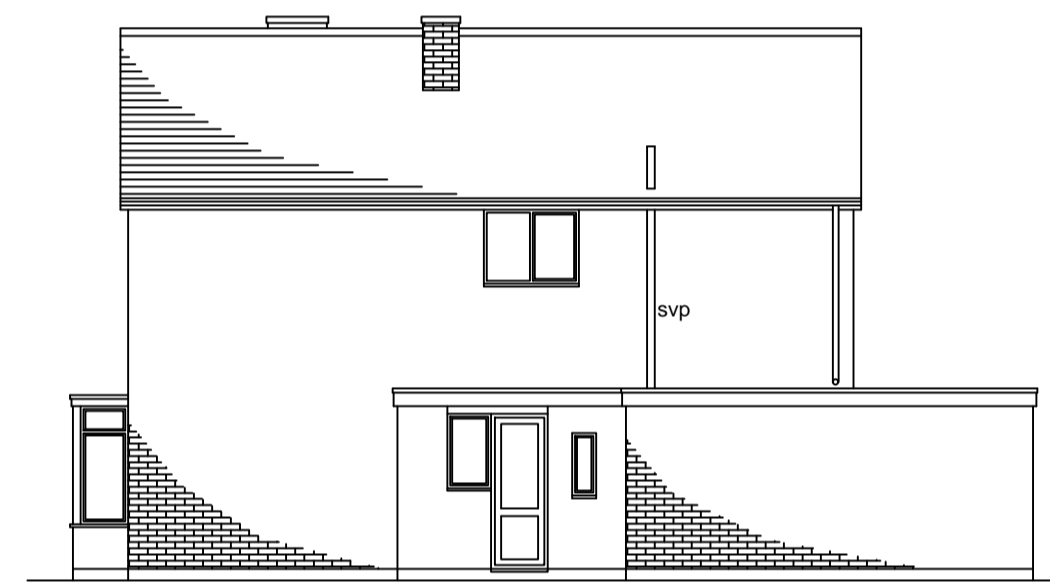


EXISTING ADJ. SIDE ELEVATION
(scale 1:100)

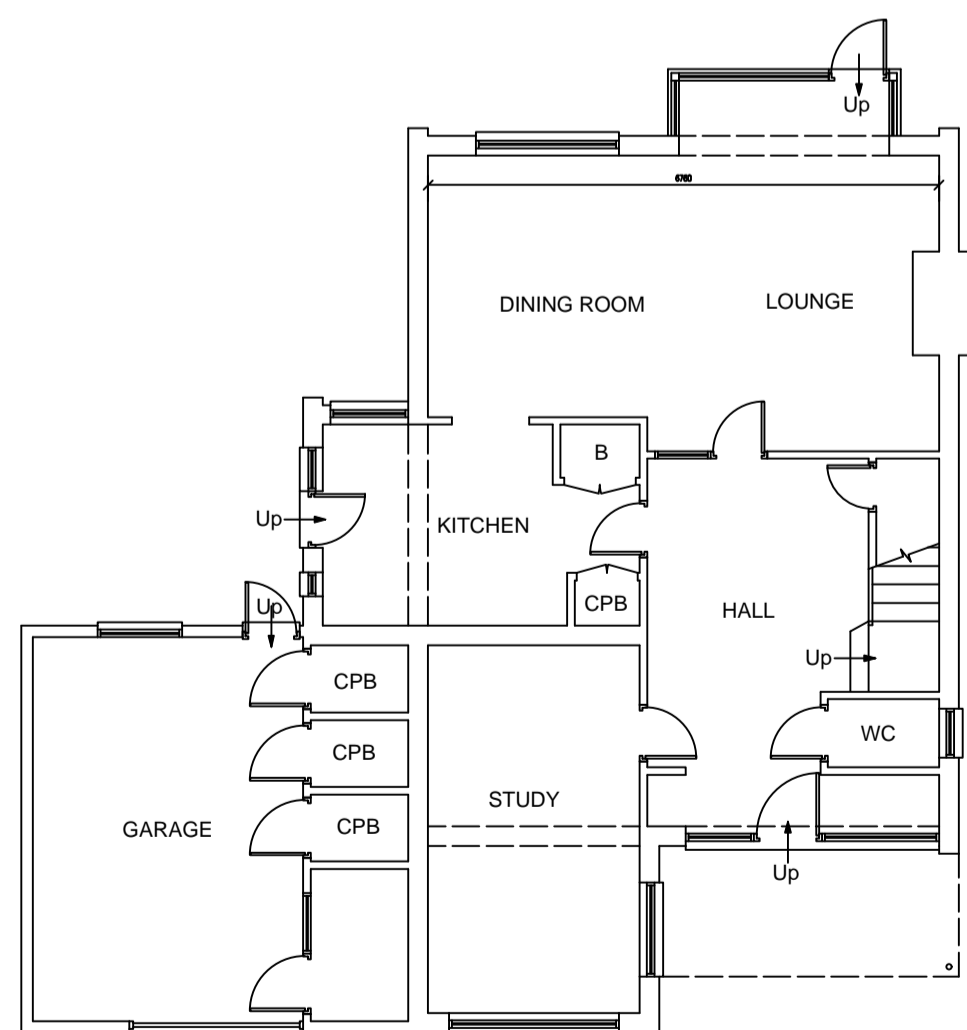


EXISTING GROUND FLOOR PLAN
(scale 1:100)

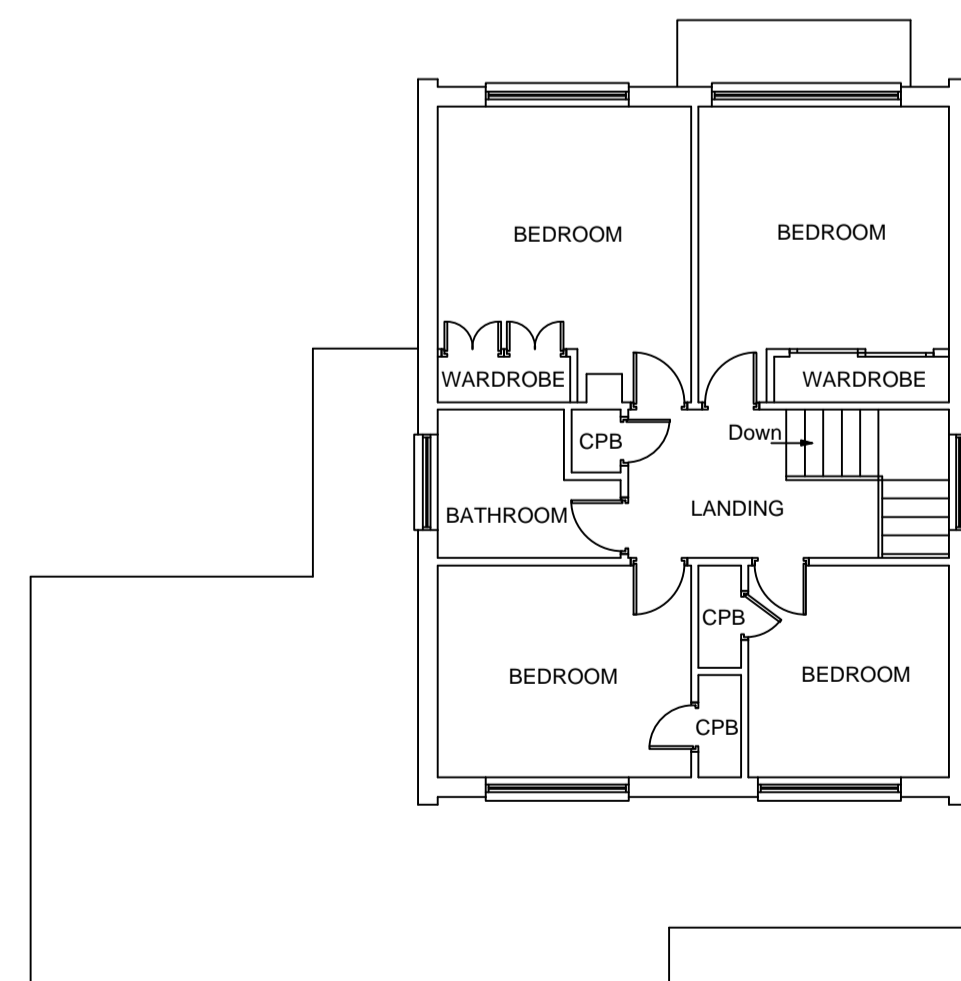


EXISTING FIRST FLOOR PLAN
(scale 1:100)

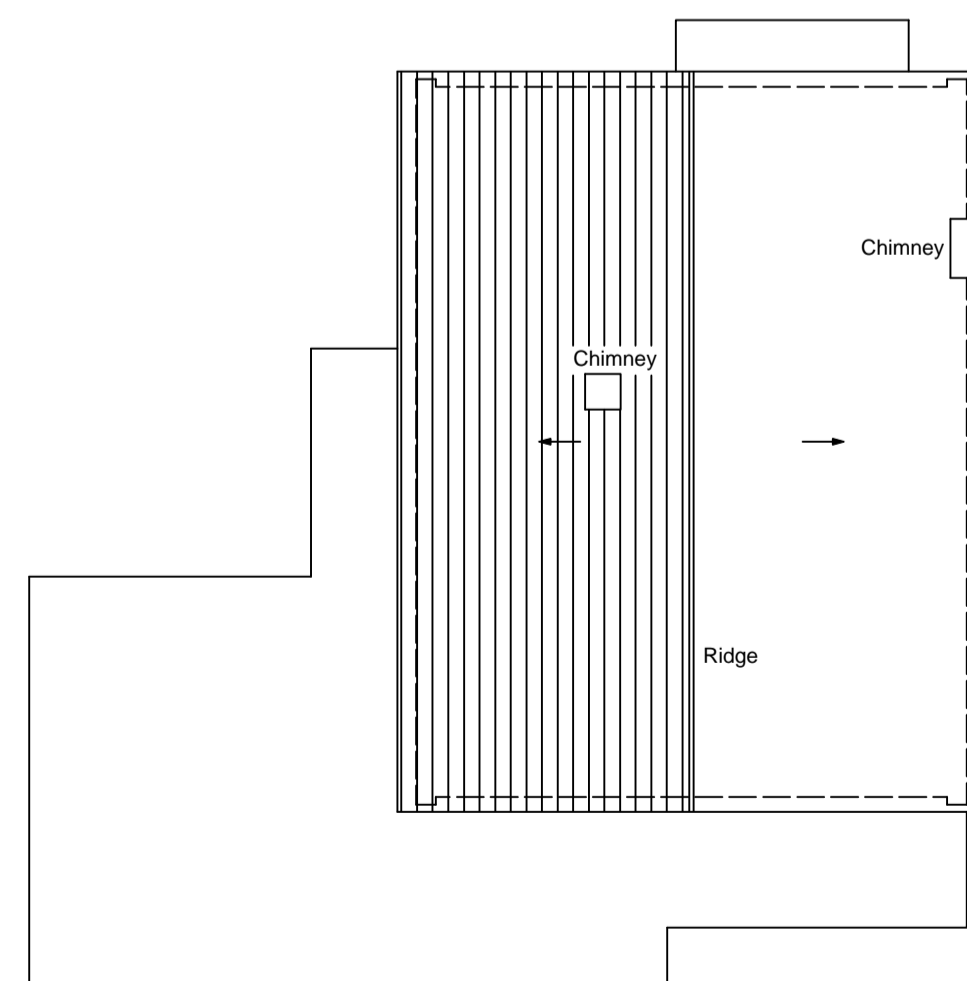

EXISTING ROOF PLAN
(scale 1:100)

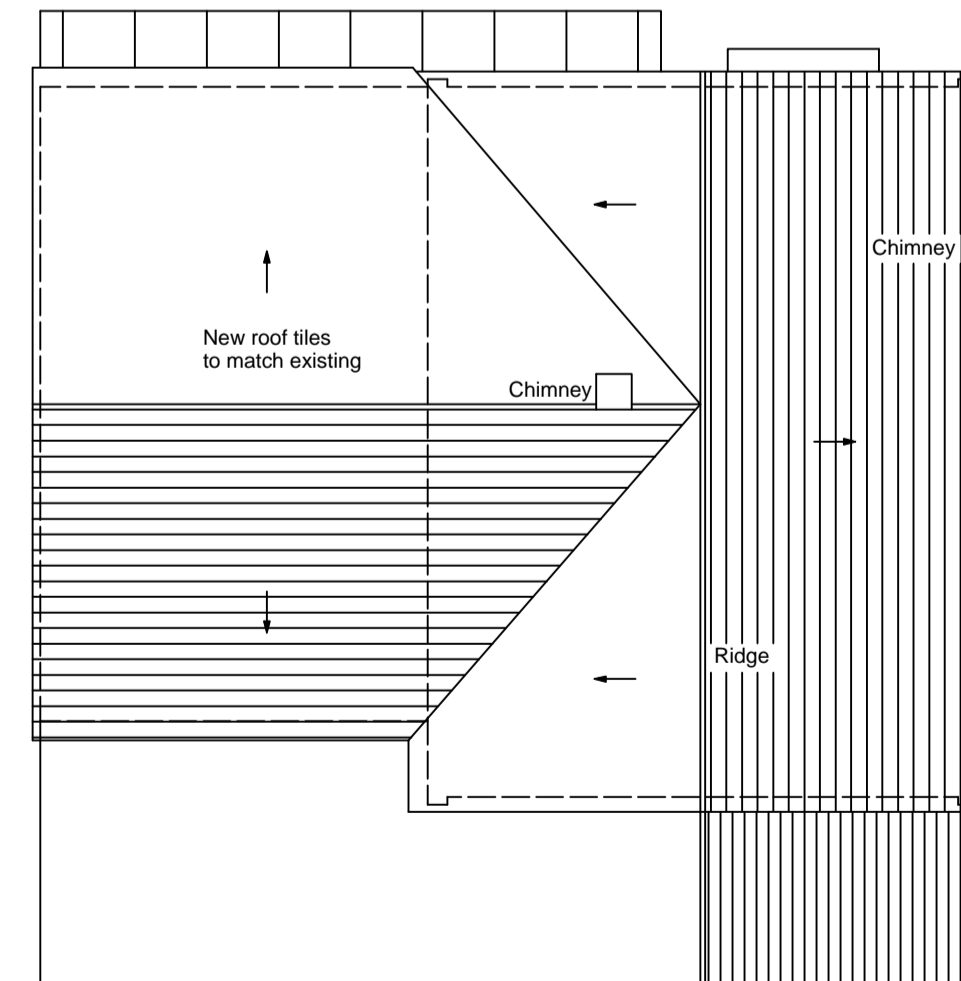


PROPOSED ROOF PLAN
(scale 1:100)

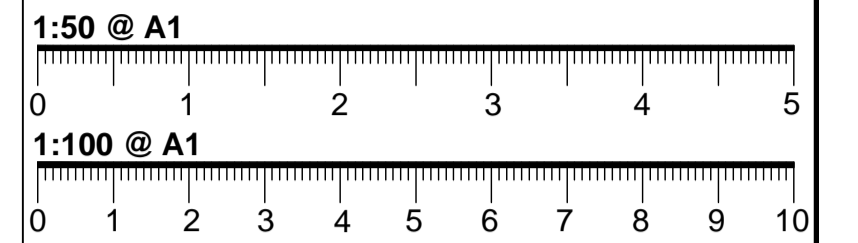

- NOTES:**
- THESE DRAWINGS ARE FOR BUILDING ILLUSTRATION PURPOSES ONLY
 - (REFER TO BUILDING SPEC FOR FURTHER INFORMATION)
 - DIMENSIONS ARE TO BE CHECKED ON SITE PRIOR TO ANY CONSTRUCTION
 - REFER TO STRUCTURAL ENGINEER REPORT FOR STEEL WORKS, THESE DRAWINGS ARE FOR ILLUSTRATION PURPOSES ONLY
 - ELECTRICAL LAYOUT TO BE CONFIRMED BY CLIENT ON SITE WITH BUILDER
 - PLUMBING TO CONNECT TO EXISTING

- KEY:**
- SITE BOUNDARY
 - - - DEMOLITION
 - DRAINAGE
 - LIGHT LAYOUT TBC

 - KEY:**
- (DS) MAINS CONNECTED SMOKE DETECTOR
 - (HD) MAINS CONNECTED HEAT DETECTOR
 - (XX-X) (REFER TO BUILDING SPEC NOTES)
 - FFL+XXX FINISHED FLOOR LEVEL
 - FE/RL FIRE ESCAPE ROPE LOCATION
 - FR/ER FIRE ESCAPE ROUTE WINDOW
 - FD-30 FIRE RATED DOOR UP TO 30min
 - FS-30 FIRE RATED STUD WALL UP TO 30min
 - FR-30 FIRE RATED GLASS UP TO 30min



REVISION DATE/DRAWN

phormwork

PROJECT	1 Coniston Close	
	London	
DRAWING TITLE	PLANNING	
	EXISTING PLANS & ELEVATIONS	
DATE	FEB 24	SCALE @ A1
DRAWN	MC	CHECK SS
STATUS		
JOB NUMBER		
DRAWING NUMBER	DR-A-01	REV C