



**GENERAL NOTES**

This drawing has been prepared for planning purposes only by Jennings Design Limited on behalf of Rontec Service Stations 1A Limited taken from MHLS Utility Survey 60997 dated 15-12-23.


- This drawing to be read in conjunction with ;
- 230866 EVC PLNG-01 Existing Site Layout
- 230866 EVC PLNG-02 Existing Site Elevations
- 230866 EVC PLNG-03 Proposed Site Layout
- 230866 EVC PLNG-04 Proposed Site Elevations
- 230866 EVC PLNG-05 Block Plan
- 230866 EVC PLNG-06 Site Location Plan
- 230866 EVC PLNG-07 Tracking Plan

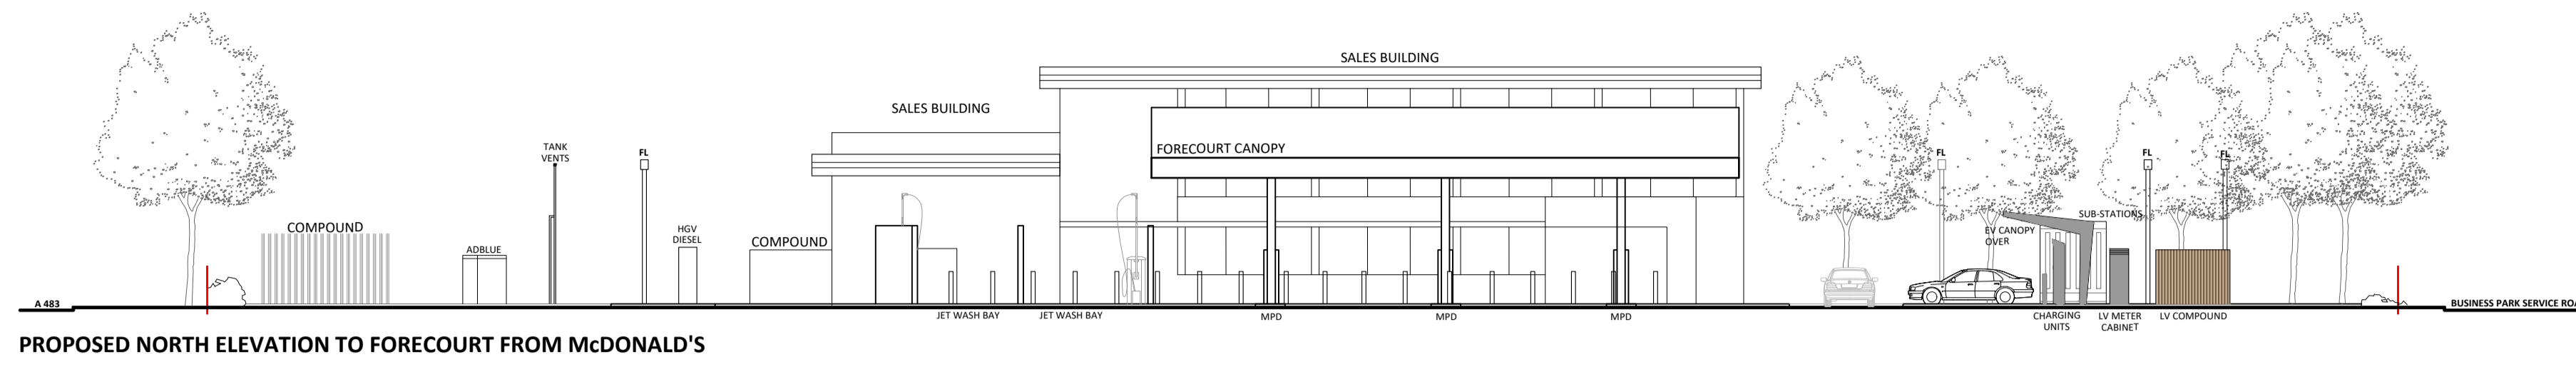

PROPOSED NORTH ELEVATION TO FORECOURT FROM McDONALD'S

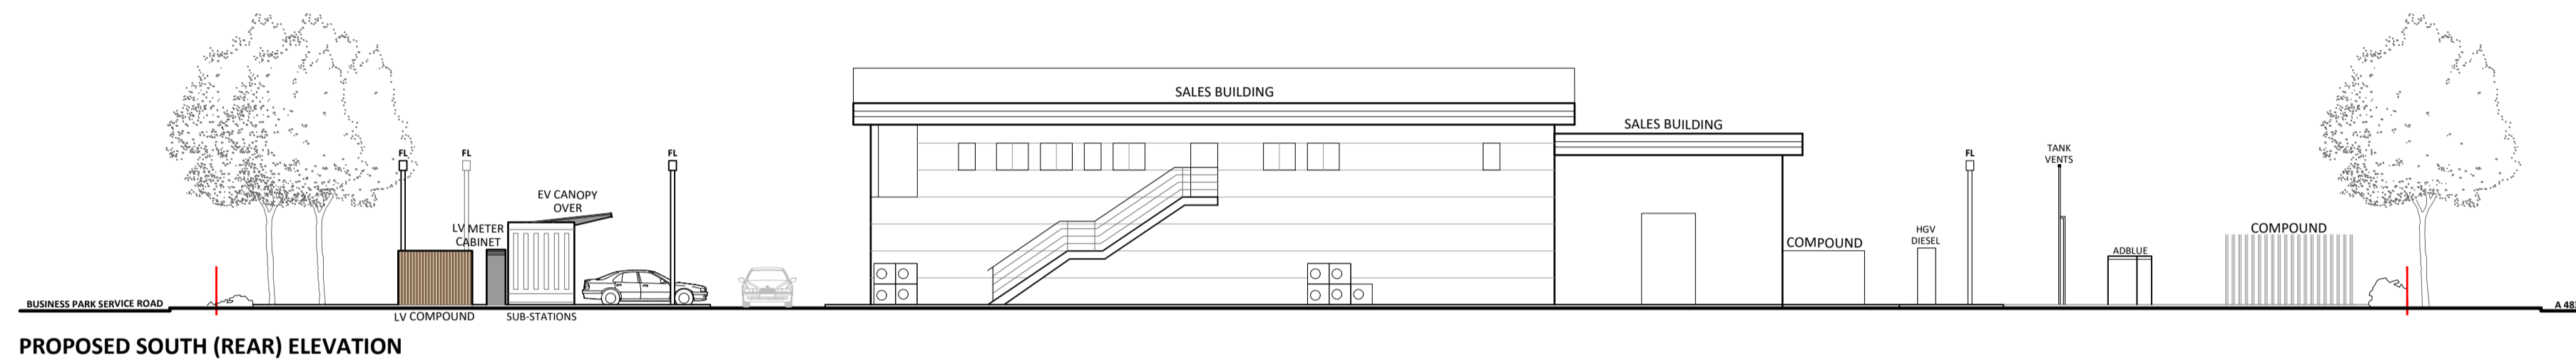


PROPOSED SOUTH (REAR) ELEVATION

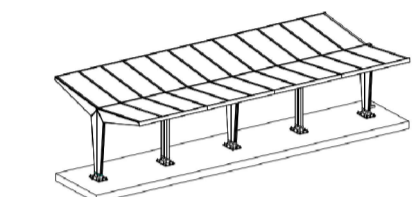



CANOPY ISOMETRIC VIEW - nts

NOTE TYPICAL VIEW SHOWN IS FOR A DOUBLE SIDED CHARGING BAY. REAR CANOPY OMITTED TO THIS PROPOSAL.

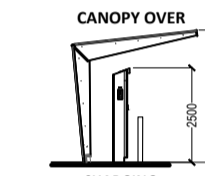


END ELEVATION

TYPICAL CHARGING UNITS / CANOPY

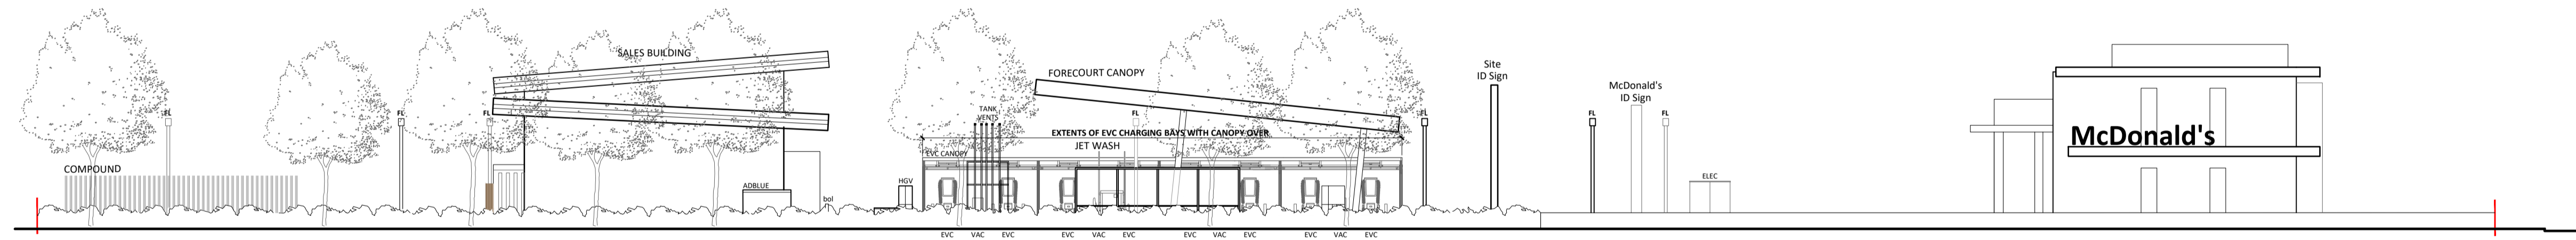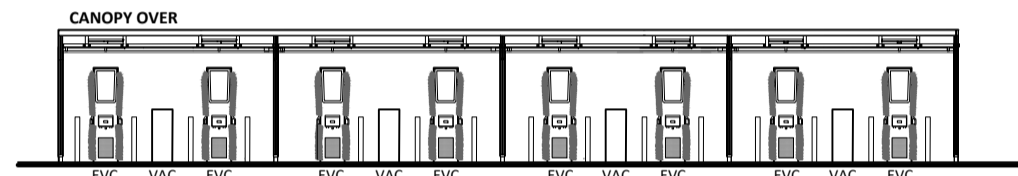

PROPOSED EAST ELEVATION TO A 483

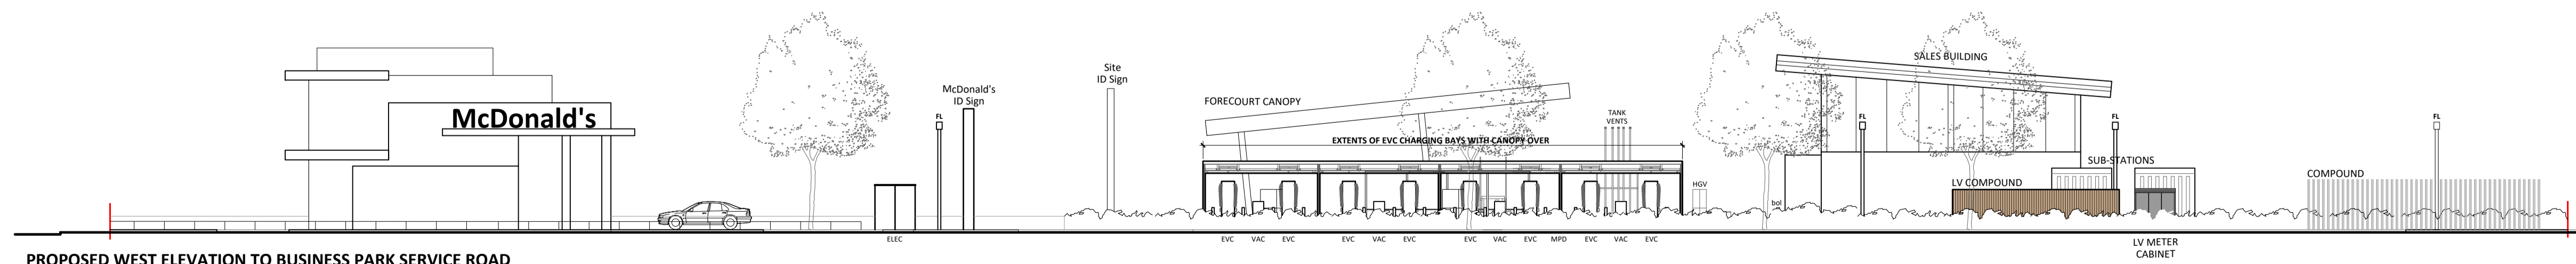

PROPOSED WEST ELEVATION TO BUSINESS PARK SERVICE ROAD


Rev	Date	Comments
STATUS		PLANNING
PROPOSAL		ELECTRIC VEHICLE CHARGE POINTS
SITE LOCATION		WELSHPOOL SERVICE STATION BUTTING CROSS ENTERPRISE PARK WELSHPOOL, SY21 8SL
TITLE		PROPOSED SITE ELEVATIONS
CLIENT		Rontec Service Stations 1A Ltd



8 East Field, Horsforth, Leeds, West Yorkshire, LS18 4TJ  
www.jennings-design.com 01274 395422 office@jennings-design.com

Drawn by: DS	Checked by: NJJ
Date: January 2024	Scales: 1:200 @ A1

 PLAN NO. 230866\_PLNG-04



SCALE - METRES - 1:200 @ A1

A1  
ORIGINAL  
PLOT SIZE