



Do not scale from this drawing, except for planning purposes. Any discrepancies are to be reported to WS Planning & Architecture. Refer to Structural Engineers details for structural design criteria. This drawing remains the copyright of WS Planning & Architecture.

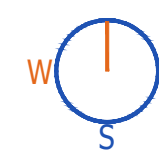

As Proposed Site Plan with Drainage Layout

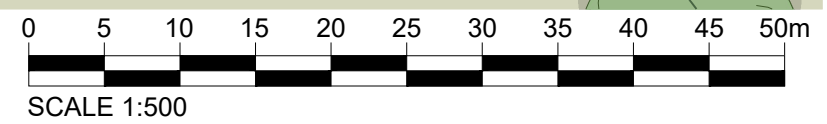

Rev	Date	Description
Surrey Office 5 Pool House Bancroft Rd Reigate RH2 7RP		London Office No.1 Croydon 12-16 Addiscombe Rd Croydon CR0 0XT
Date March 2024		Drawn By MR
Scale 1:500@A3		Checked PB
Client Hemp Construction		
Project Moors Barn, Marsh Road, Standerwick, BA11 2PZ		
Title As Proposed Site Plan with Drainage Layout		
Drawing No. J004239-TD-02		Rev.