




COPYRIGHT ©
 FIGURED DIMENSIONS ONLY ARE TO BE USED. FOR OTHER DIMENSIONS REFER TO CA. ALL DIMENSIONS TO BE CHECKED ON SITE PRIOR TO THE COMMENCEMENT OF WORK. DISCREPANCIES, AMBIGUITIES OR DIFFERENCES BETWEEN DRAWINGS, AND BETWEEN DRAWINGS AND SPECIFICATION OR BILLS OF QUANTITIES TO BE REFERRED TO CA WITHOUT DELAY. DO NOT SCALE THIS DRAWING.

GENERAL NOTES:

THIS DRAWING MUST NOT BE USED FOR CONSTRUCTION PURPOSES OR INSTALLATION PURPOSES UNLESS EXPRESSLY STATED.
 DO NOT SCALE OFF THIS DRAWING. ALWAYS WORK TO NOTED DIMENSIONS.
 ALL DIMENSIONS MUST BE VERIFIED ON SITE BEFORE COMPLETING SHOP DRAWINGS OR SETTING OUT WORKS.
 ALL DRAWINGS MUST BE VERIFIED ON SITE BEFORE COMPLETING SHOP DRAWINGS OR SETTING OUT WORKS.
 THIS DRAWING IS TO BE READ IN CONJUNCTION WITH ALL ARCHITECTURAL & STRUCTURAL ENGINEERS DRAWINGS & ASSOCIATED DESIGN DRAWINGS PRODUCED BY 'KES LTD'. ALL DIMENSIONS IN MILLIMETRES (mm).
 THIS DRAWING IS UNDER COPYRIGHT AND AT NO TIME MUST ANY PORTION OF THIS DRAWING BE REPRODUCED OR COPIED IN ANY WAY WITHOUT THE PERMISSION OF 'KES LTD'.
 ALL WORKS ON SITE ARE TO COMPLY WITH THE RELEVANT BRITISH STANDARDS, CODES OF PRACTICE AND CURRENT BUILDING REGULATIONS.
 ANY DISCREPANCIES BETWEEN ALL WORKING DRAWINGS, SPECIFICATIONS & SCHEDULES OF ALL DISCIPLINES TO BE NOTIFIED TO KES LTD FOR CLARIFICATION/CORRECTION PRIOR TO CONSTRUCTION.

LEGEND

- AHU
- CONDENSER UNIT
- AC UNIT EXISTING
- AC UNIT NEW
- DIFFUSER
- SUPPLY GRILLE
- SUPPLY DUCT
- RETURN DUCT
- TOILET EX. DUCT
- REF. PIPE
- BC BOX

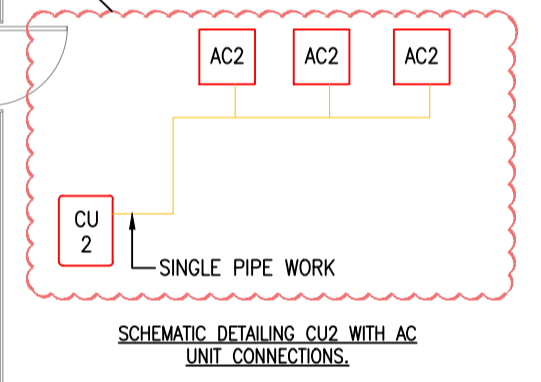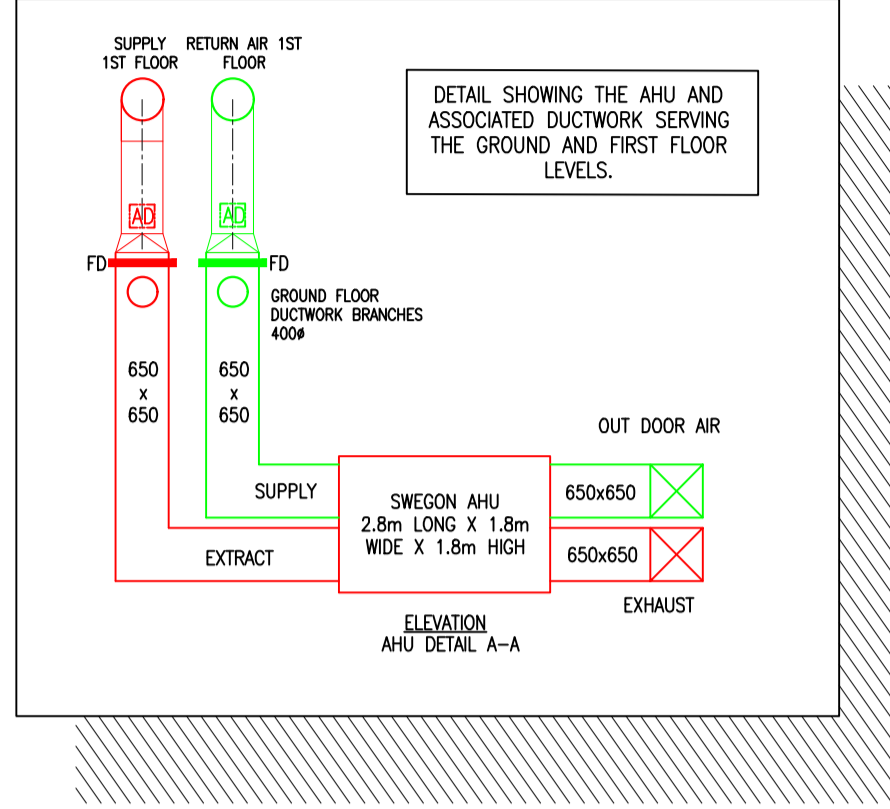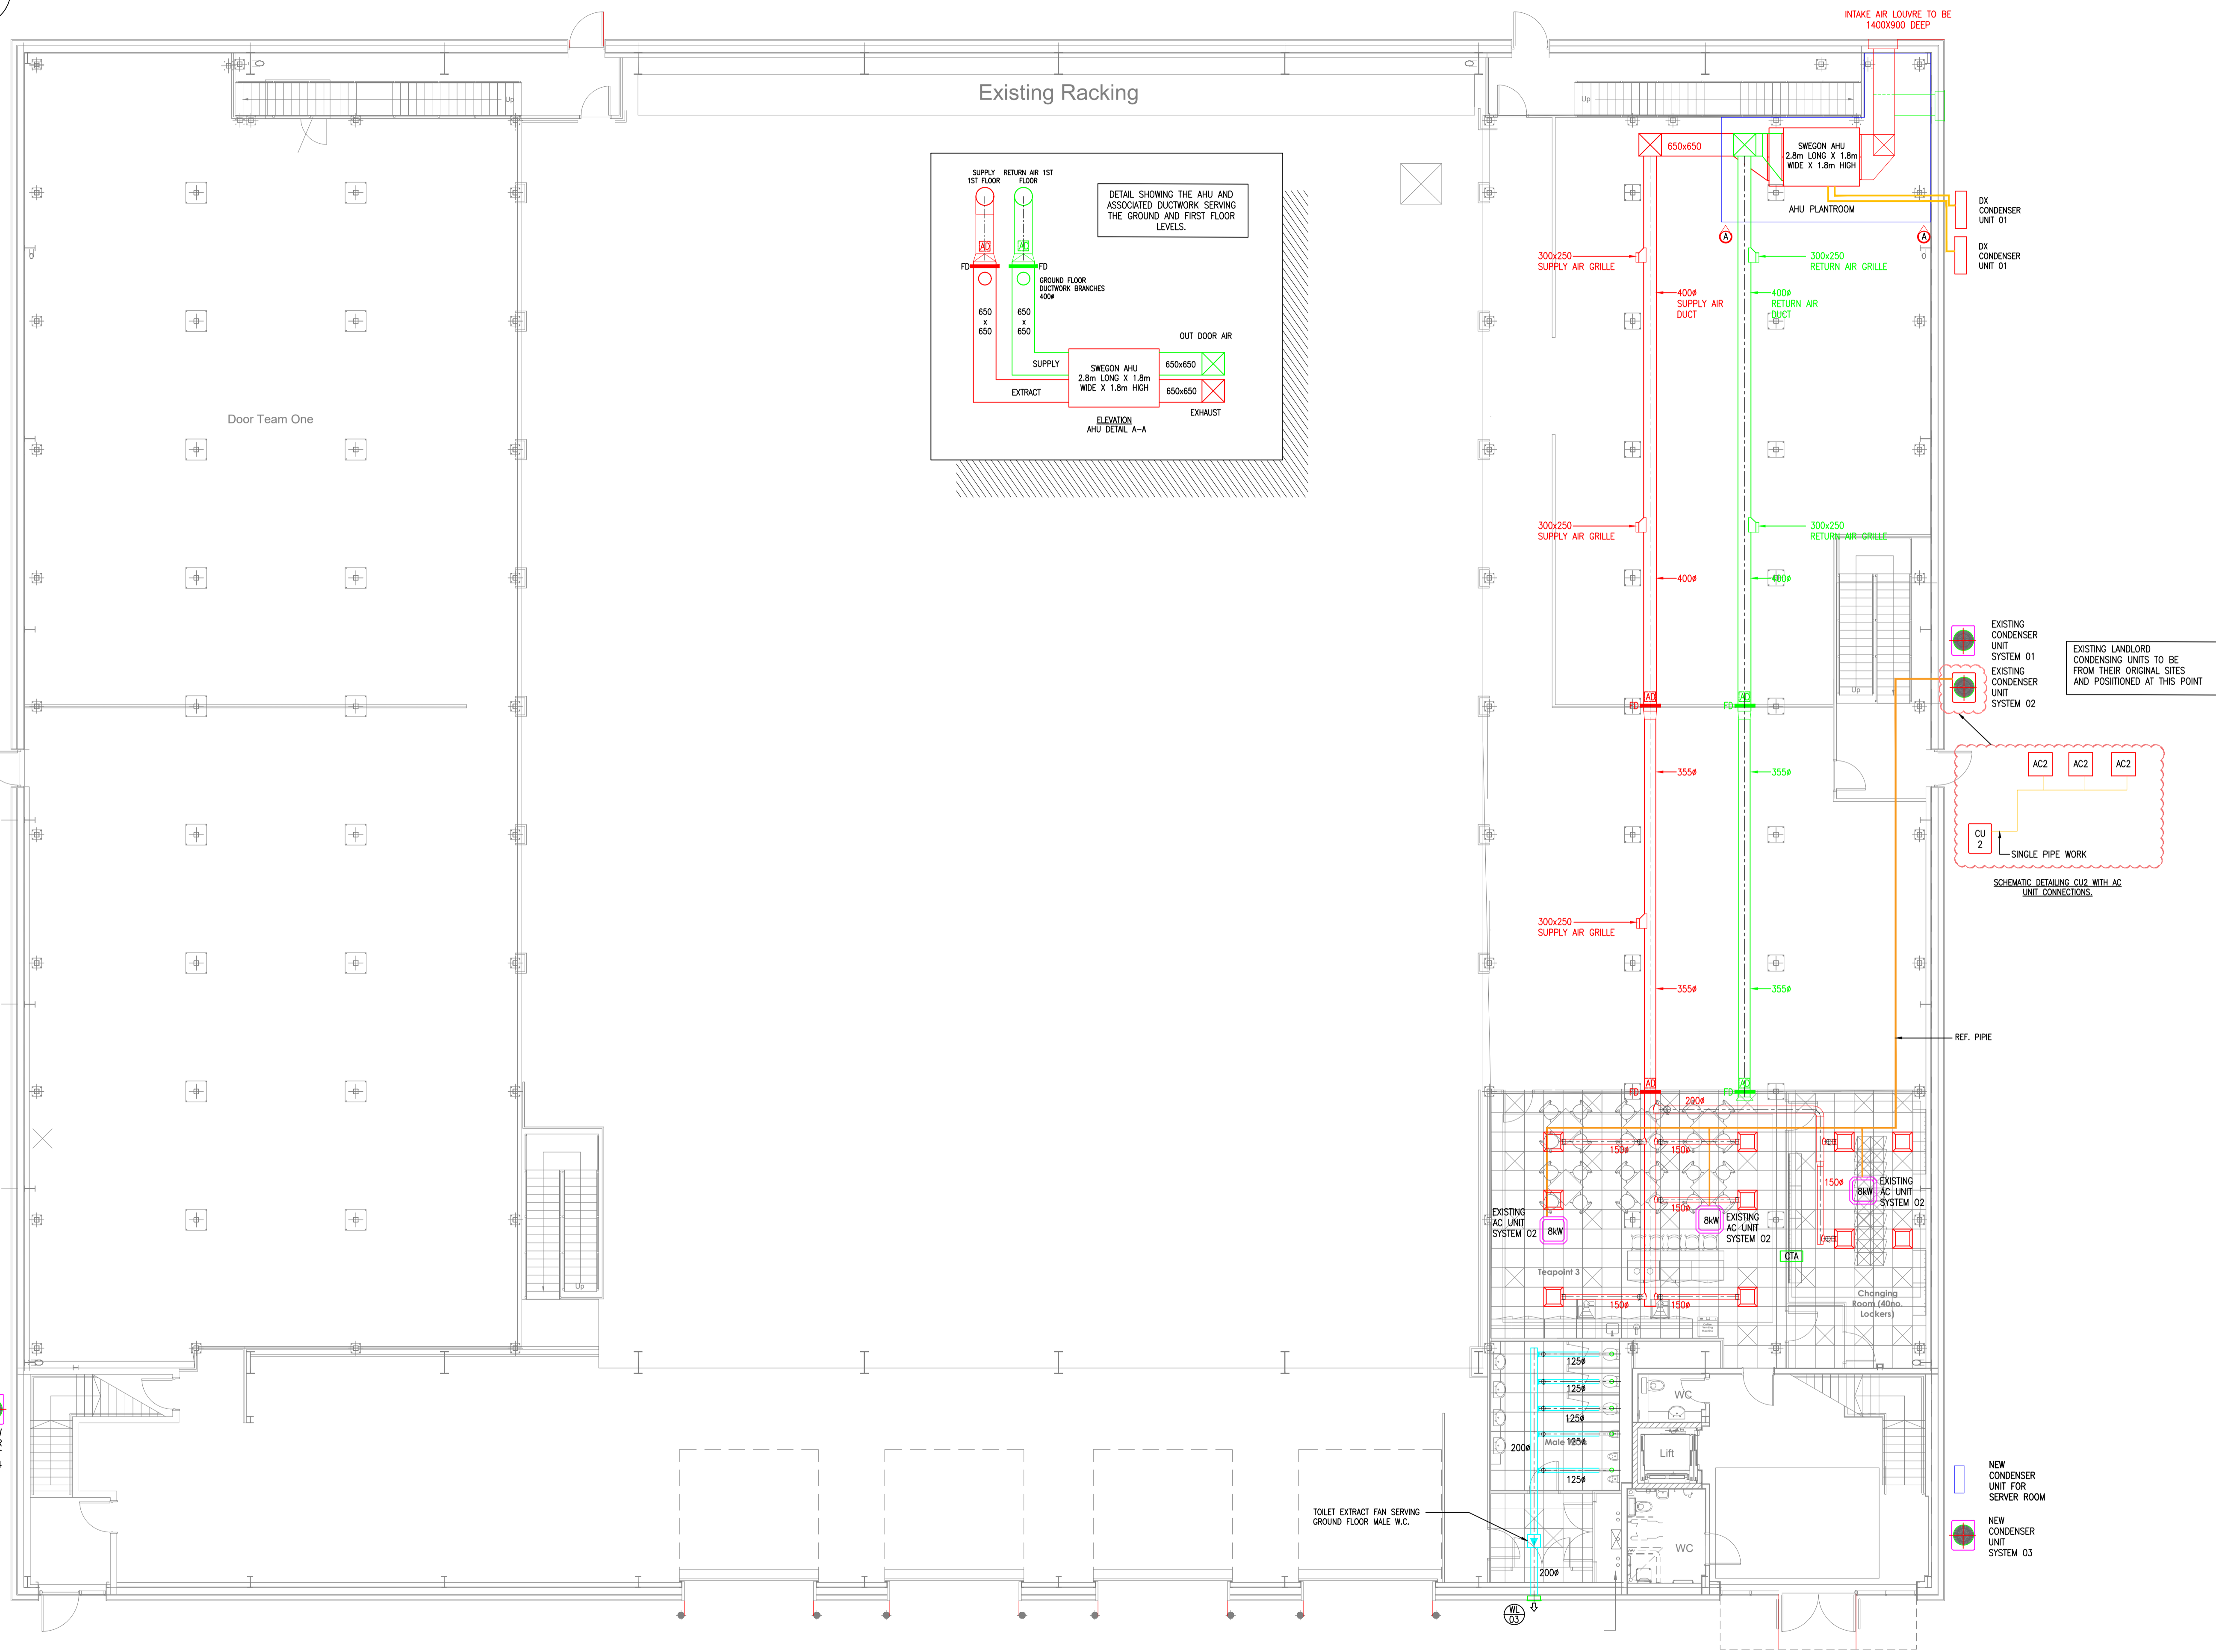


EXISTING LANDLORD CONDENSING UNITS TO BE FROM THEIR ORIGINAL SITES AND POSITIONED AT THIS POINT

EXISTING CONDENSER UNIT SYSTEM 01
 EXISTING CONDENSER UNIT SYSTEM 02

NEW CONDENSER UNIT FOR SERVER ROOM
 NEW CONDENSER UNIT SYSTEM 03

NEW CONDENSER UNIT SYSTEM 04

Proposed Ground Floor Plan

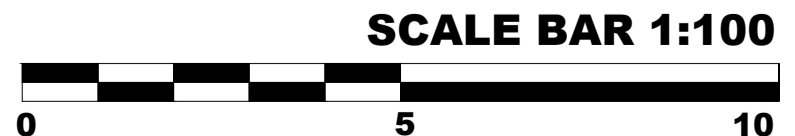

Revision	Date	Description	Drawn/Checked
PROPOSED LAYOUT			

ARUNDELL HVAC
 40 FOBING ROAD
 CARRINGTON
 ESSEX
 SS147 9BN
 TELEPHONE +44 (0) 7921 196660
 MA@ARUNDELLHVAC.CO.UK



PROJECT:
 KINGSWAY GROUP
 UNIT 1, HELIX, EDGINGTON WAY, SICUP

Client:
 BEH / KINGSWAY GROUP

Title:
 GROUND FLOOR PROPOSED MECHANICAL LAYOUT

Scale: 1:100@A1
Drawn: CAD
Date: SEP 2023

Project.No: 1437
Dwg.No.: M200 - 02

REVISION P01