

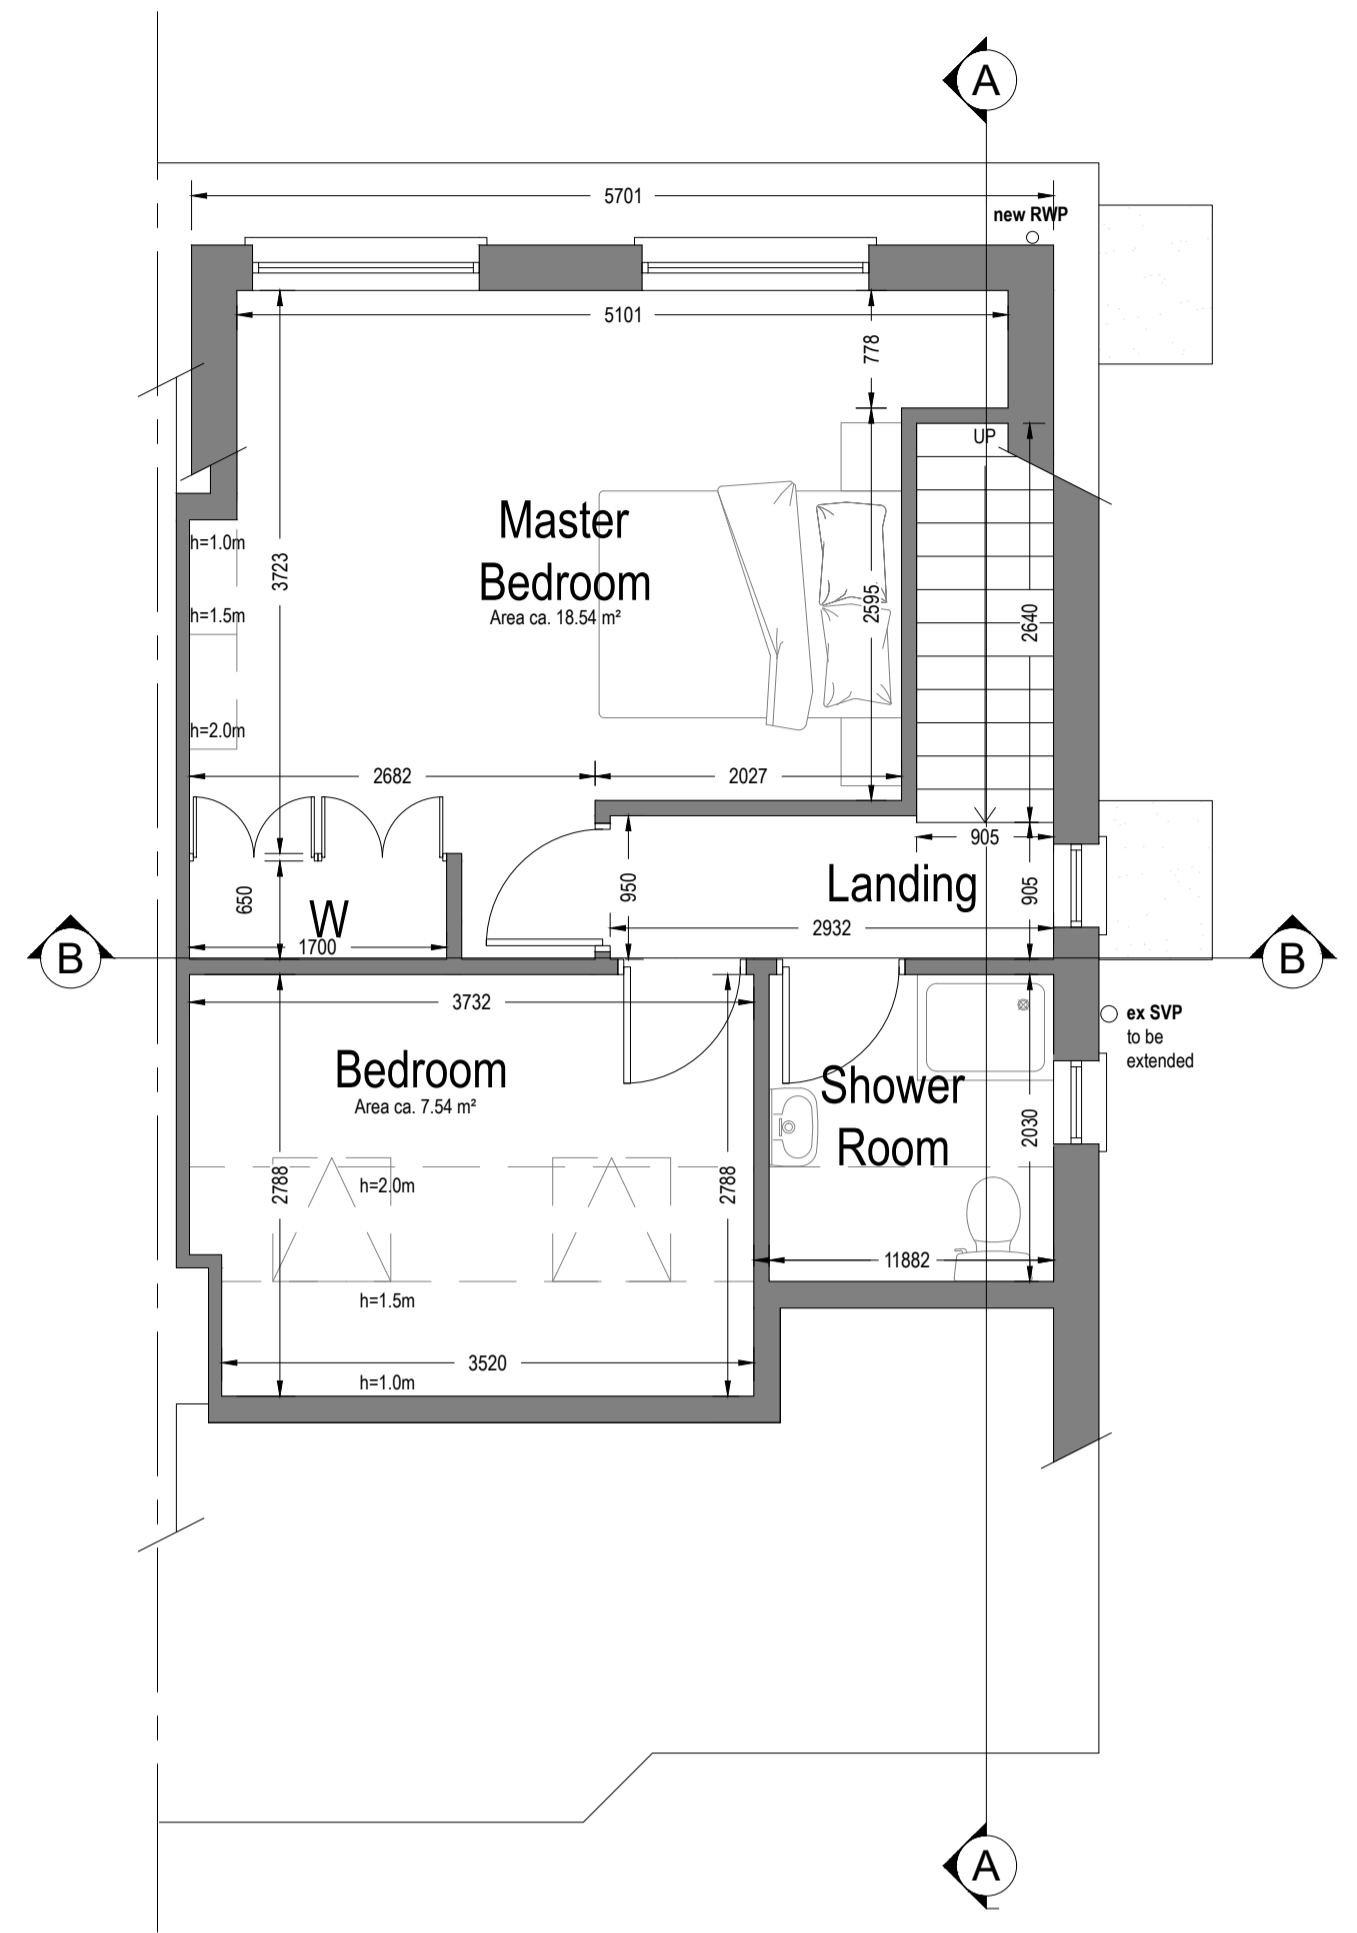


PROPOSED OPTION 1

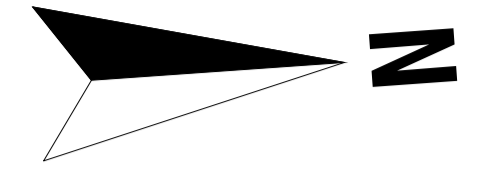

Loft Plan
Area ca. 36.44 m²
Additional Area: 36.44 m²

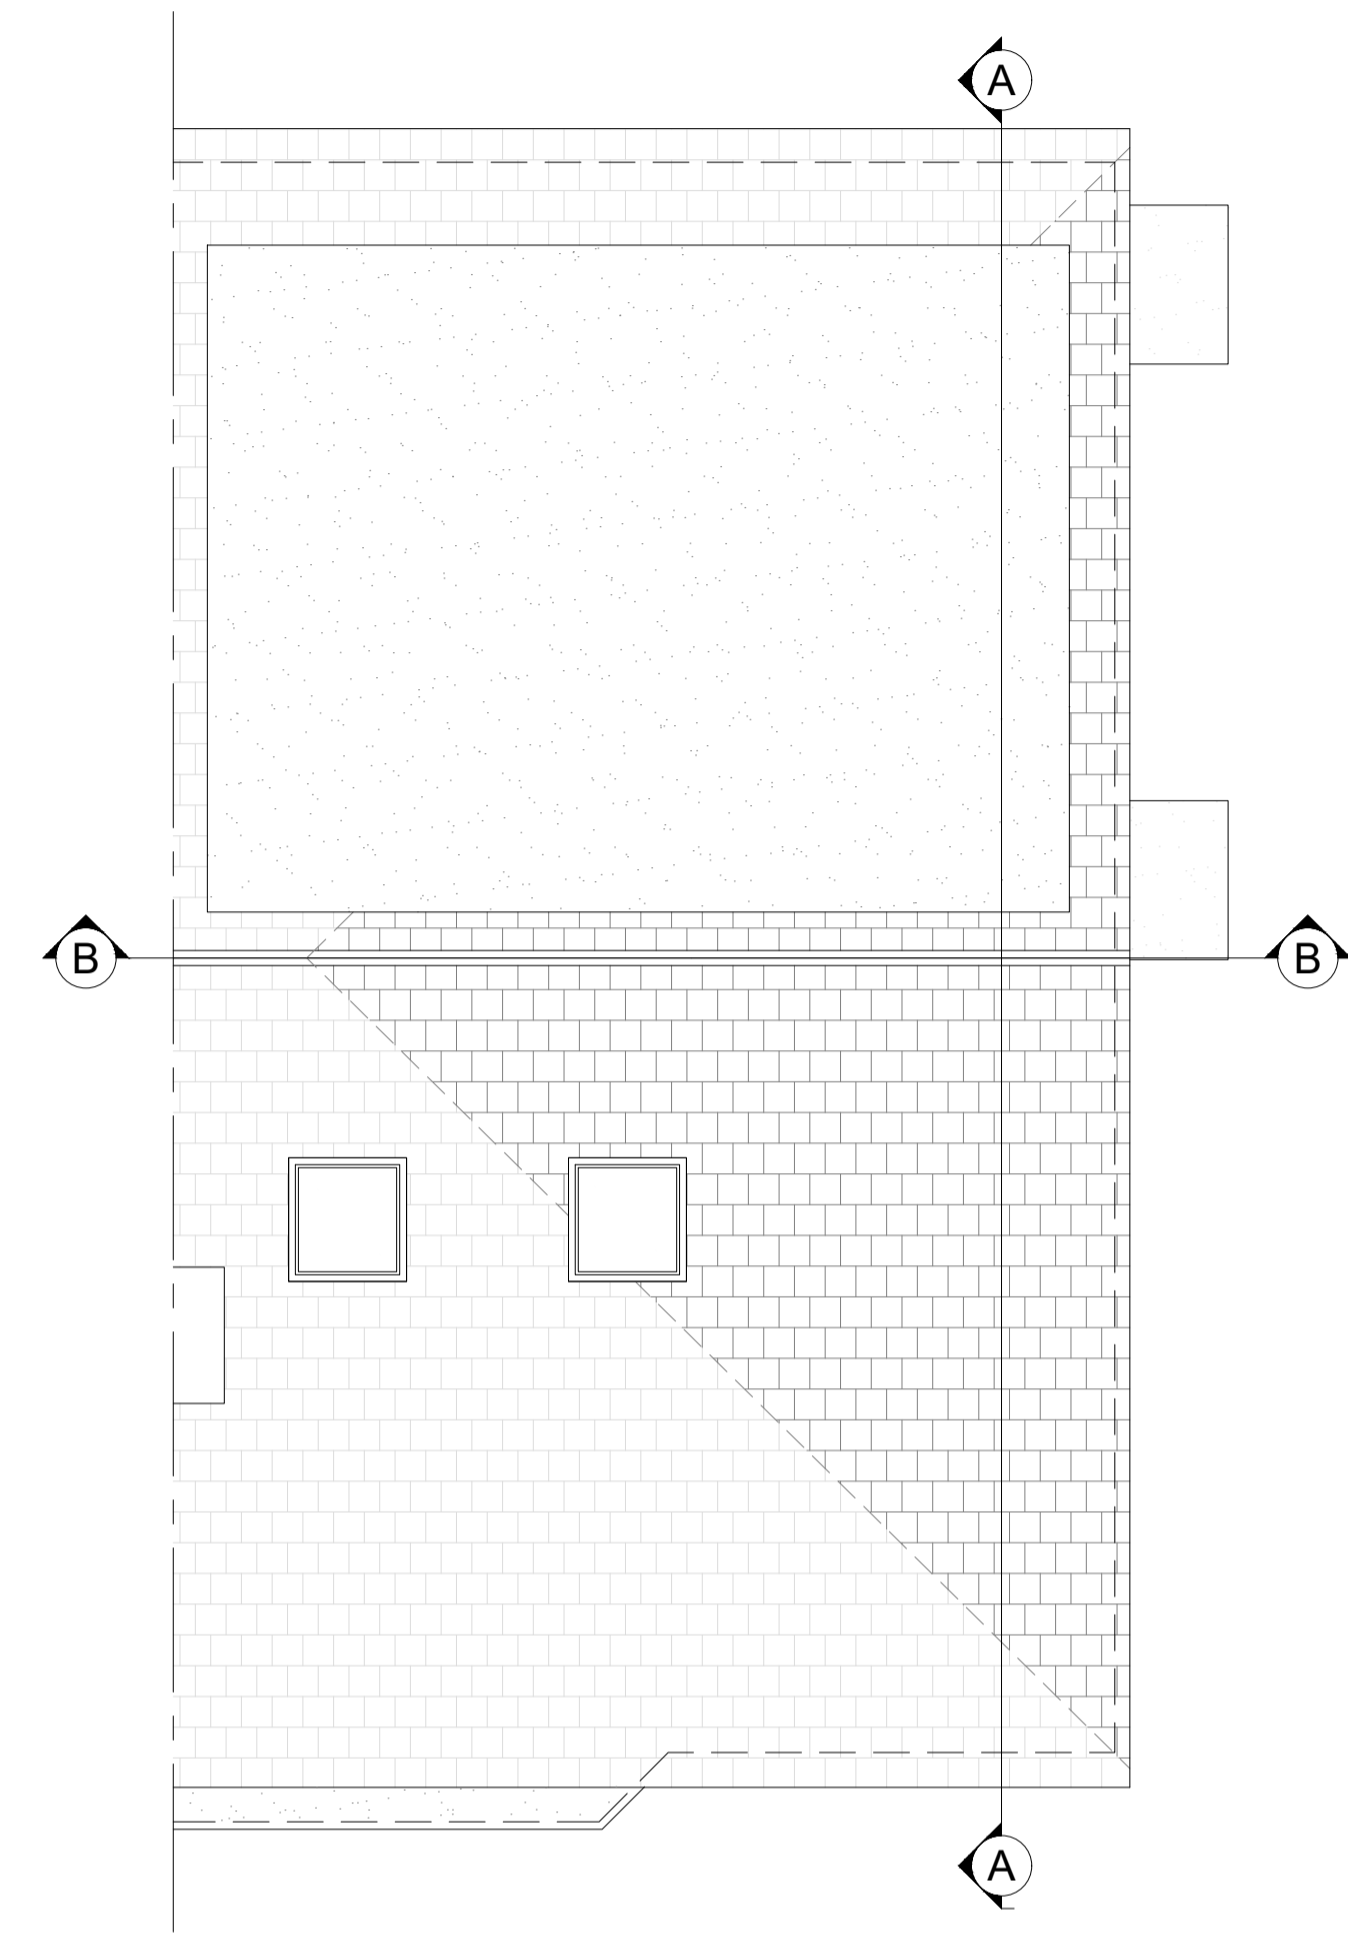

Roof Plan

Symbol Key:

- Proposed wall
- Boundary line
- Details above
- Waste drainage layout
- Demolished
- Rainwater layout



Note to Contractor: Contractor is recommended to carry out an intrusive site investigation prior to commencing works on site to ensure all details designed for this project are appropriate. Contractor to cross reference with Structural Calculations package for suitability, to assess site levels and confirm any design assumptions within the calculations package prior to works commencing on site. If the Contractor requires any additional information, please send a Request For Information to hello@planituk.co.uk before ordering materials and starting the works - requests will be acknowledged and responded to as soon as possible. Please ensure that the drawings have been submitted to Building Control for a Full Plans submission and the compliance report has been discharged before starting works on site.

Drawn by:
FD

Title Number
SGL47316,SGL758034

Project:
10A Rochester Close, Sidcup DA15 9PG

Date:
27.02.2024

No.:
24-0234

Client:
P Castelli

Drawing Title:
PROPOSED PLANS

Scale @A1:
1:50

Rev:
02

Page:
D05