

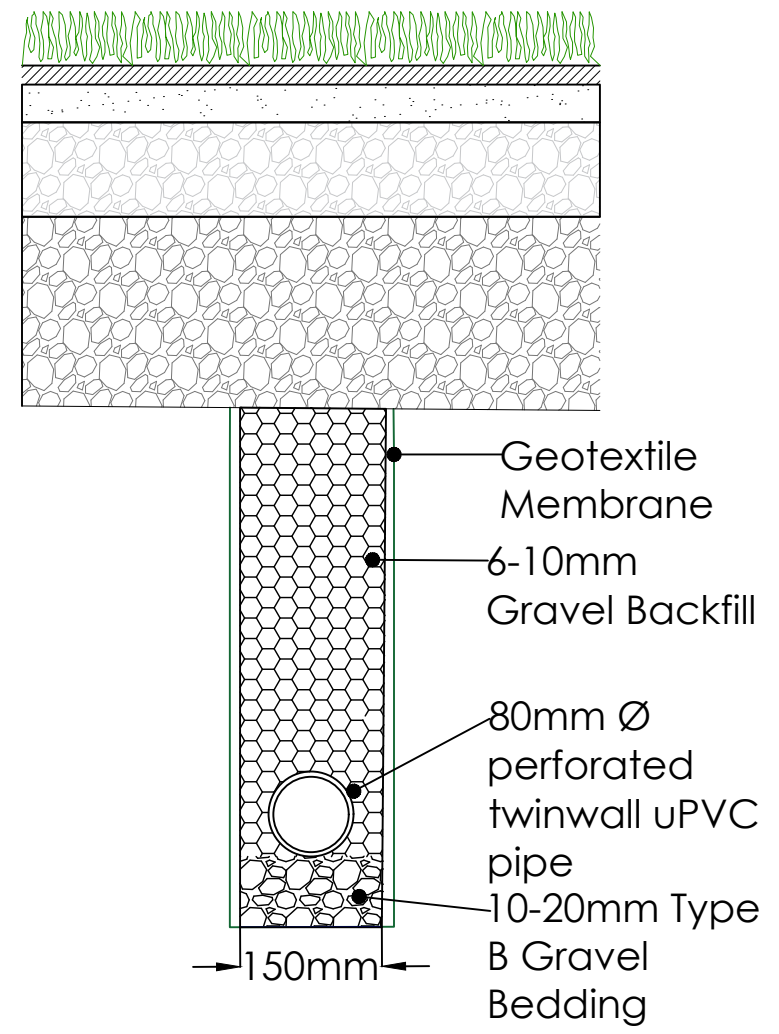
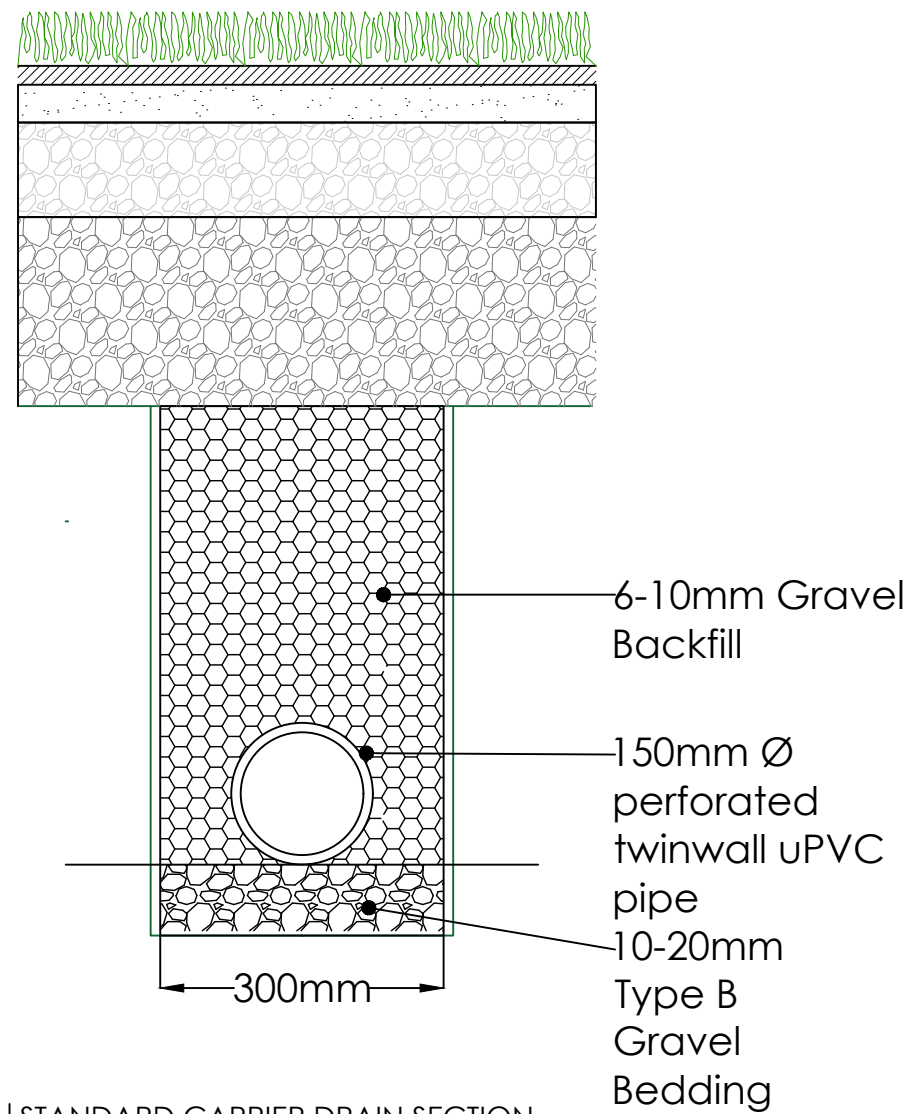


NOTES  
It is the contractors responsibility to check design levels and sizes for compliance. Any discrepancies or errors to be identified to the design team.


Refer to drawing No. 200 for Drainage Layout

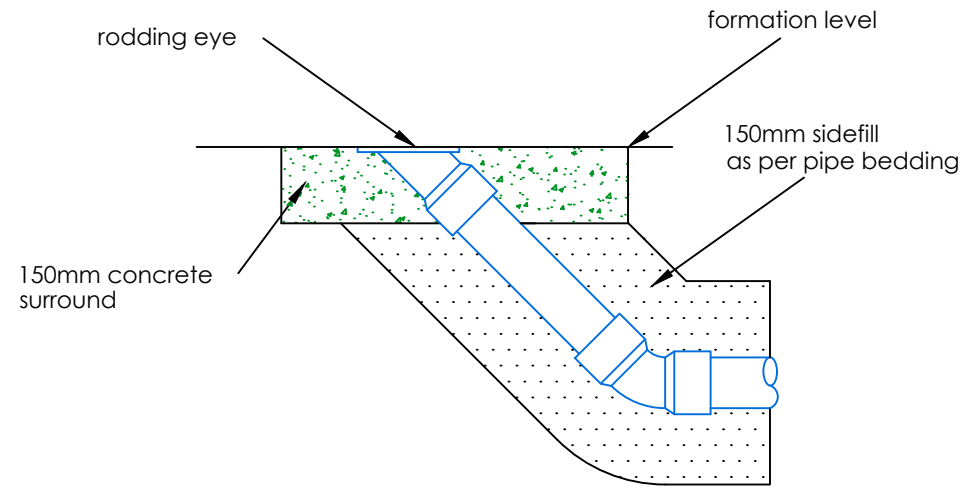

REVISION	DETAILS	BY	DATE	CHECKED

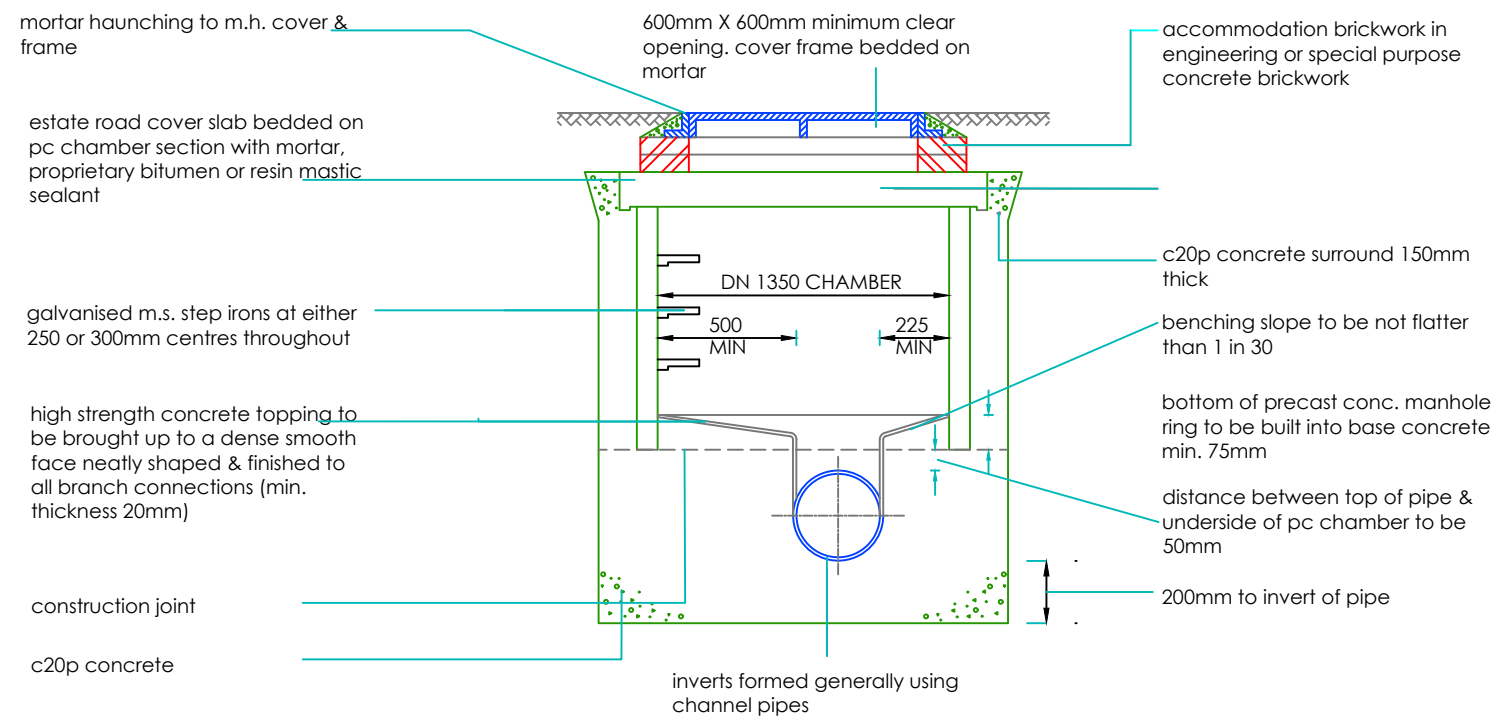

 ARDROSSAN WINTON ROVERS  
NEW BUILD 3G PITCH  
DRAINAGE DETAIL



Date: 08/2023 Scale: 1:500 @ A3	Job No. 3199	Drawn by: GS Checked by: DD
------------------------------------	--------------	--------------------------------