

- Abbreviations**
- Air valve AV
  - Bollard B
  - BT cover BT
  - Cable TV CATV
  - Electricity pole EP
  - Earth rod ER
  - Fire hydrant FH
  - Gas valve GV
  - Gate post GP
  - Gully trap GT
  - Inspection cover IC
  - Lamp electricity pole LEP
  - Lamp post LP
  - Marker post Mkr
  - Manhole MH
  - Cover level CL
  - Invert level IL
  - Post P
  - Rainwater pipe RWP
  - Road sign RS
  - Rodding eye RE
  - Sign post SP
  - Soil vent pipe SVP
  - Stop valve SV
  - Stop cock SC
  - Station STN
  - Tap TAP
  - Telegraph pole TP
  - Water meter WM
  - Waste pipe WP
  - Vent pipe VP


 
- Drainage**
- Combined sewer CS
  - Foul water sewer FWS
  - Storm water sewer SWS

- Internal floor plans**
- Finished floor level FFL
  - Ceiling height Ceil
  - Window cill height Cill
  - Window head height Hd
  - Door head height Hd

- Services**
- Overhead cable O/H
  - Underground unidentified service UG

- Tree**
- Diameter Dia
  - Spread Spr
  - Height Ht

Station	Easting	Northing	Level
STN1	100.000	200.000	50.000
STN2	122.937	200.000	48.456
STN3	103.579	215.023	49.669

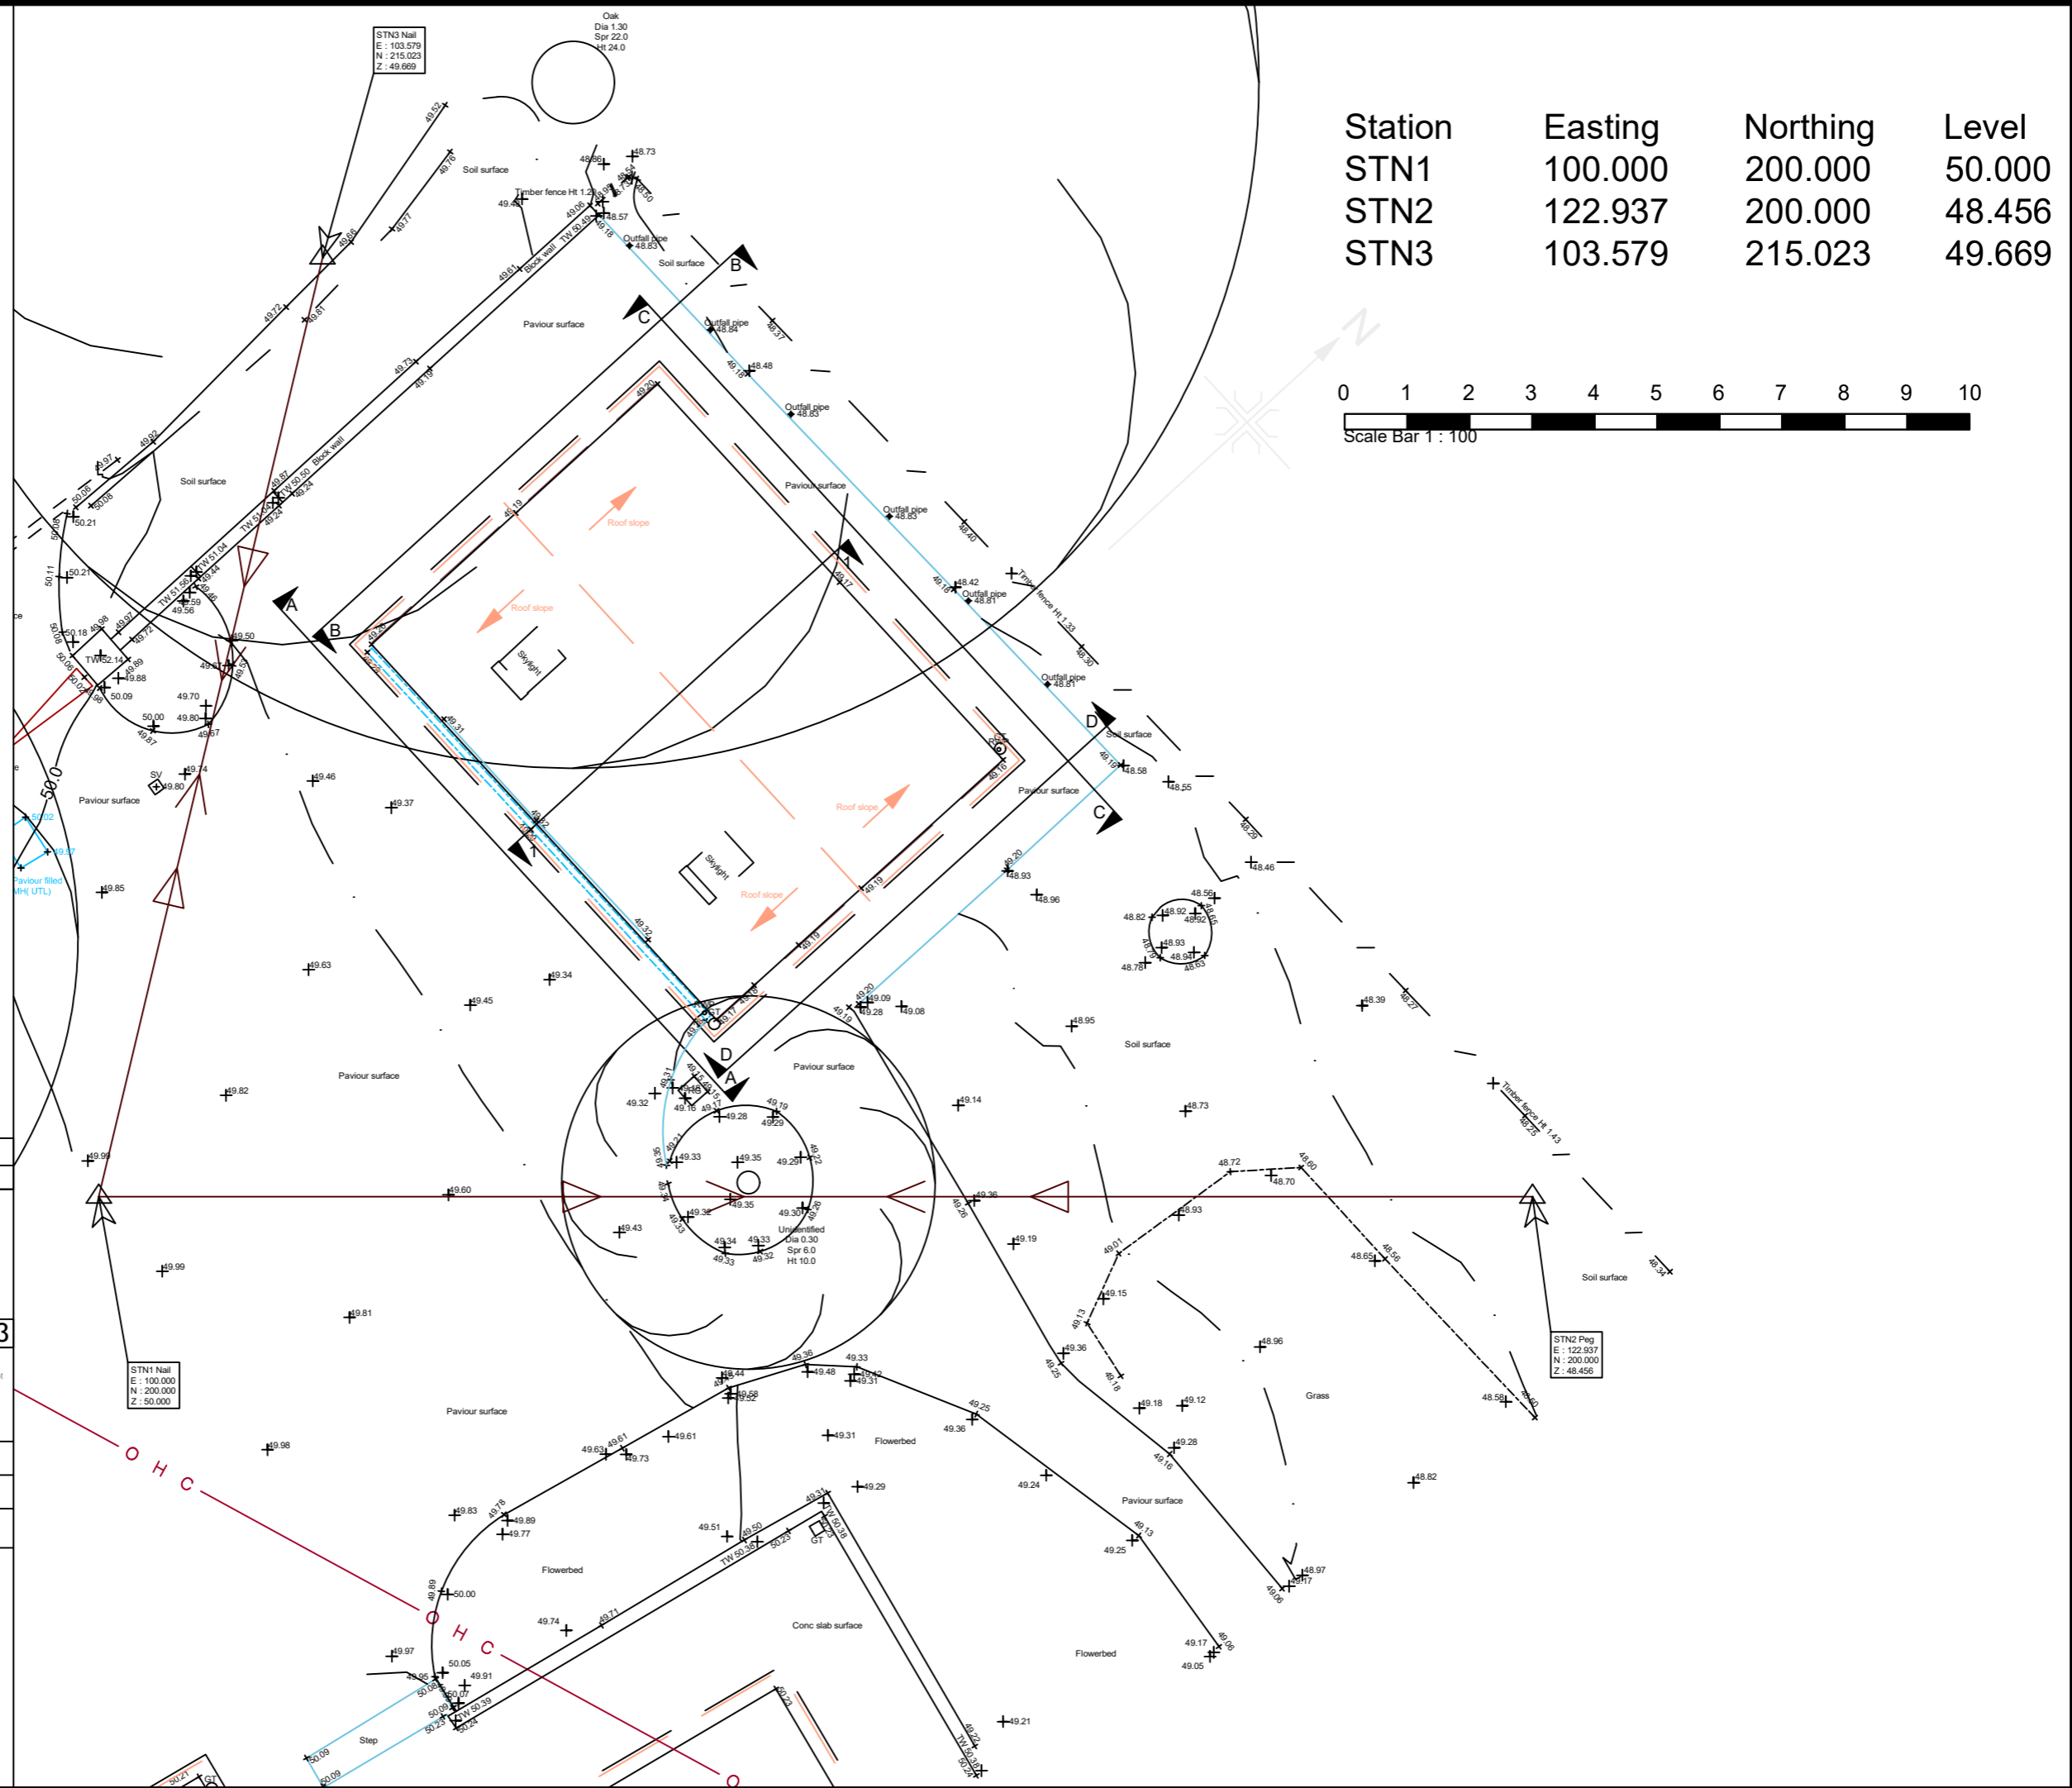

**Forester TPC Limited**  
*Planning and Land Survey*  
 www.forestertpc.co.uk  
 01392 462099

A3

**NOTES:**  
 This drawing is produced for use in this project only and may not be used for any other purpose. Forester TPC Limited accept no liability for the use of this drawing other than the purpose for which it was intended.  
 This drawing may not be reproduced in any form without prior written agreement.  
 Do not scale from the drawing, use written dimensions only.

**Date Oct 2023**

**Scale 1 : 100**

**Drawing No. 23\_49\_SS**

**Existing topographic survey**  
 Fenview (28),  
 Tidcombe Lane,  
 Tiverton,  
 EX16 4DZ.