






<b>Abbreviations</b>	
Air valve	AV
Bollard	B
BT cover	BT
Cable TV	CATV
Electricity pole	EP
Earth rod	ER
Fire hydrant	FH
Gas valve	GV
Gate post	GP
Gully trap	GT
Inspection cover	IC
Lamp electricity pole	LEP
Lamp post	LP
Marker post	Mkr
Manhole	MH
Cover level	CL
Invert level	IL
Post	P
Rainwater pipe	RWP
Road sign	RS
Rodding eye	RE
Sign post	SP
Soil vent pipe	SVP
Stop valve	SV
Stop cock	SC
Station	STN
Tap	TAP
Telegraph pole	TP
Water meter	WM
Waste pipe	WP
Vent pipe	VP

<b>Drainage</b>	
Combined sewer	CS
Foul water sewer	FWS
Storm water sewer	SWS

<b>Internal floor plans</b>	
Finished floor level	FFL
Ceiling height	Ceil
Window cill height	Cill
Window head height	Hd
Door head height	Hd

<b>Services</b>	
Overhead cable	O/H
Underground unidentified service	UG

<b>Tree</b>	
Diameter	Dia
Spread	Spr
Height	Ht

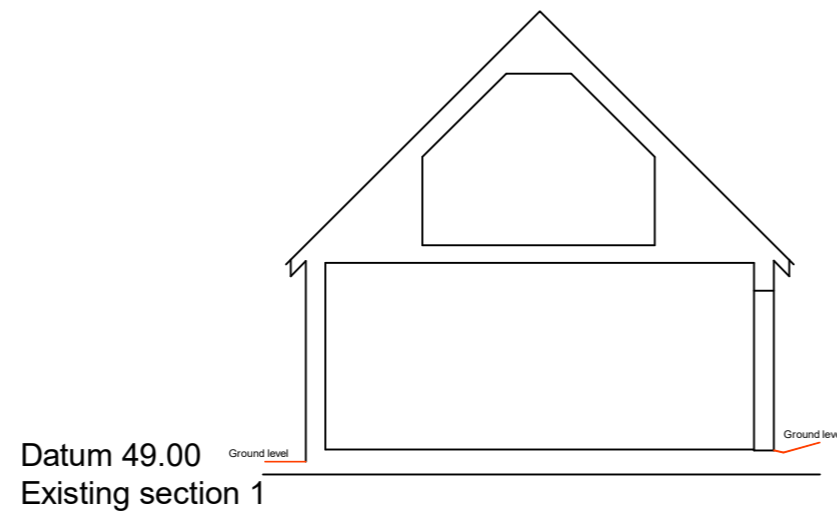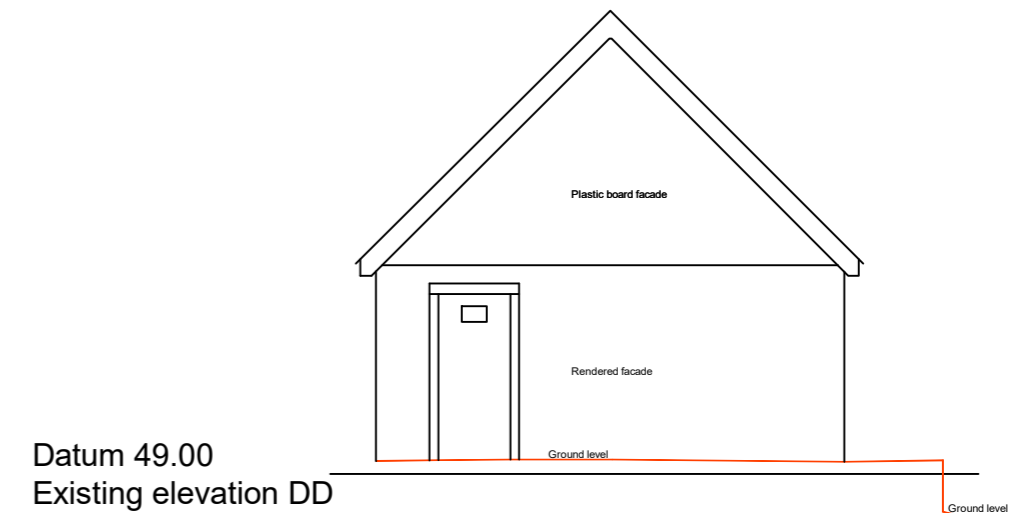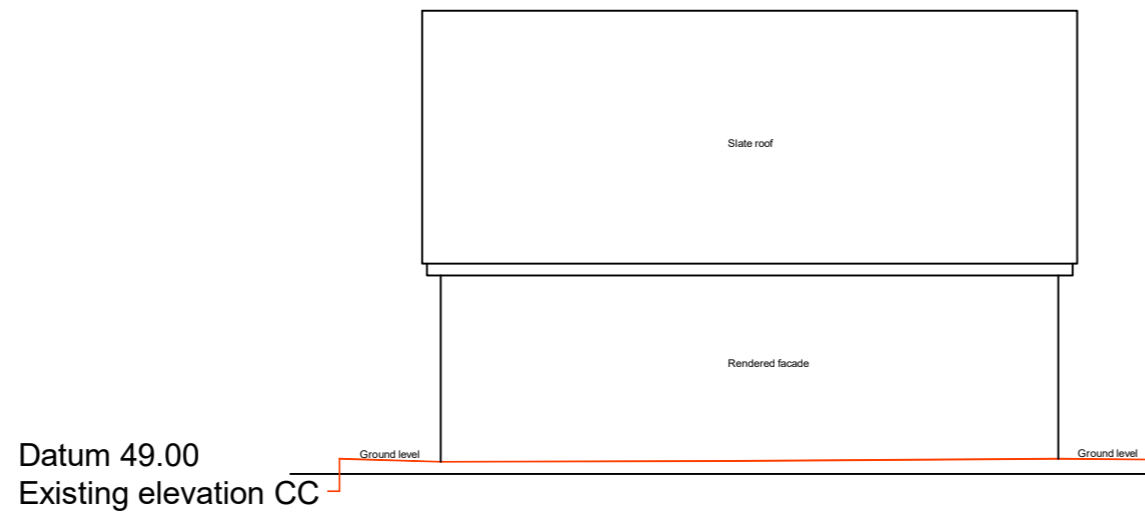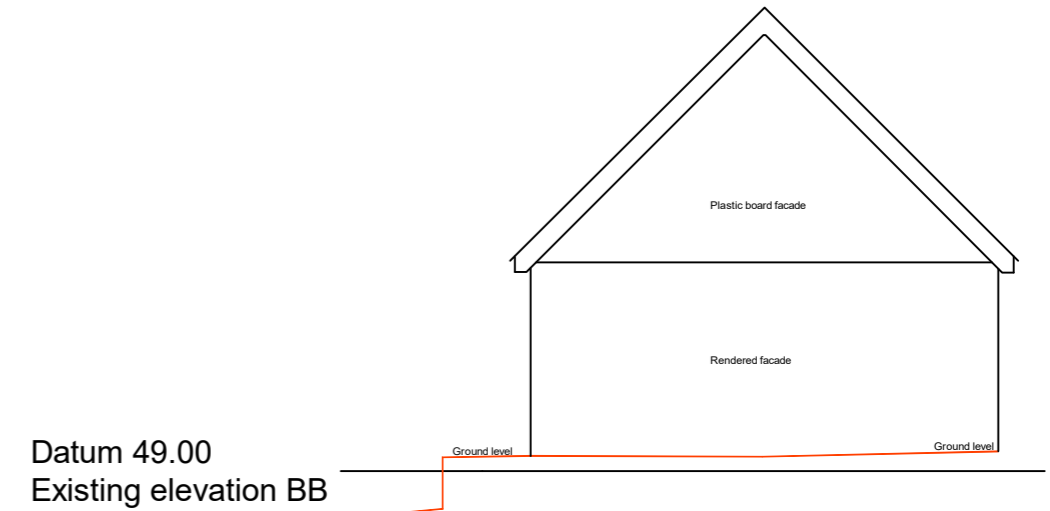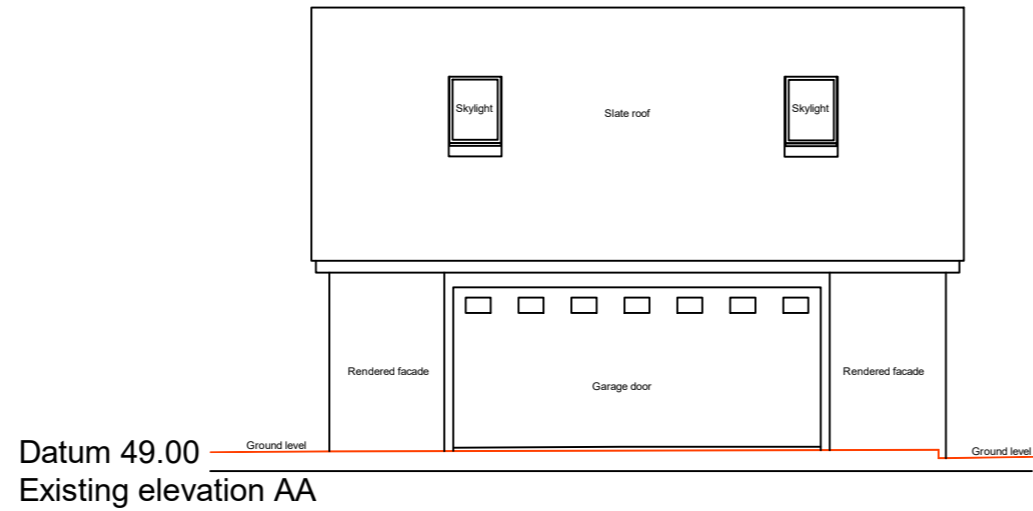

**Forester TPC Limited**  
*Planning and Land Survey*  
 www.forestertpc.co.uk  
 01392 462099

A3

**NOTES:**  
 This drawing is produced for use in this project only and may not be used for any other purpose. Forester TPC Limited accept no liability for the use of this drawing other than the purpose for which it was intended.  
 This drawing may not be reproduced in any form without prior written agreement.  
 Do not scale from the drawing, use written dimensions only.

Date Oct 2023

Scale 1 : 100

Drawing No. 23\_49\_SS

Existing topographic survey  
 Fenview (28),  
 Tidcombe Lane,  
 Tiverton,  
 EX16 4DZ.

