



FINISHES SCHEDULE	
Roof	Coloured metal sheets
Walls	Timber cladding
Windows	UPVC
Fascias & soffits	Timber
Rainwater goods	UPVC

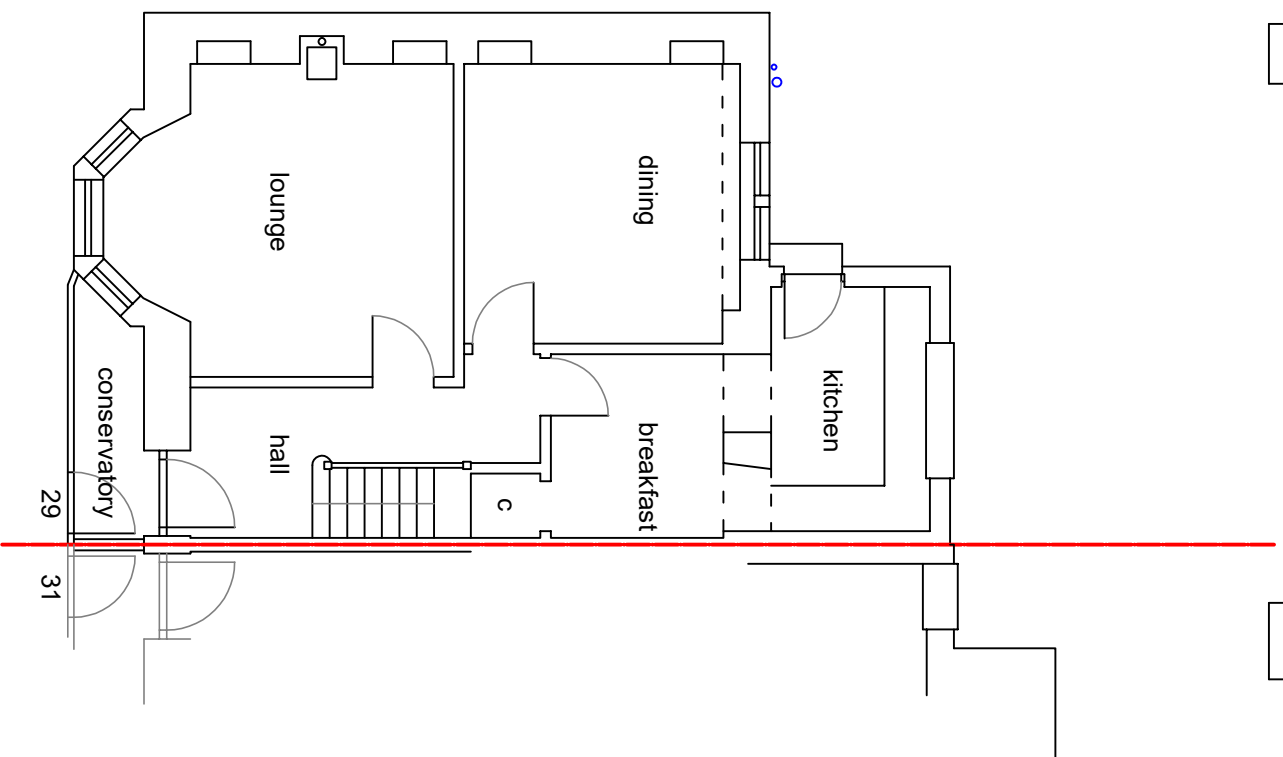

ELECTRICAL LEGEND :

- 13 Amp Switched Double Socket Outlet.
- 13 Amp Fused Switched Outlet.
- Fluorescent Strip Light Fitting.
- Pendant Light Fitting.
- Wall Mounted Light Fitting.
- Recessed Spot Light Fitting.
- Light Switch.
- 2 Way Light Switch.
- Heat Detector Hard Wired.
- Ionisation Smoke Detector Hard Wired.
- Multi sensor Smoke Detector Hard Wired.
- Optical Smoke Detector Hard Wired.
- Carbon Monoxide Detector.
- Carbon Dioxide Detector.
- 30 Amp Cooker control Unit.
- T.V. Aerial Socket.
- British Telecom Outlet.
- Mechanical Extractor Fan.
- Luminaire Mechanical Extractor Fan & Light Distribution / Fuse Board.
- Door Bell Push.
- Door Bell Chime.
- Shaving Socket Light.
- Trade vent (2000mm2).

DATE: V

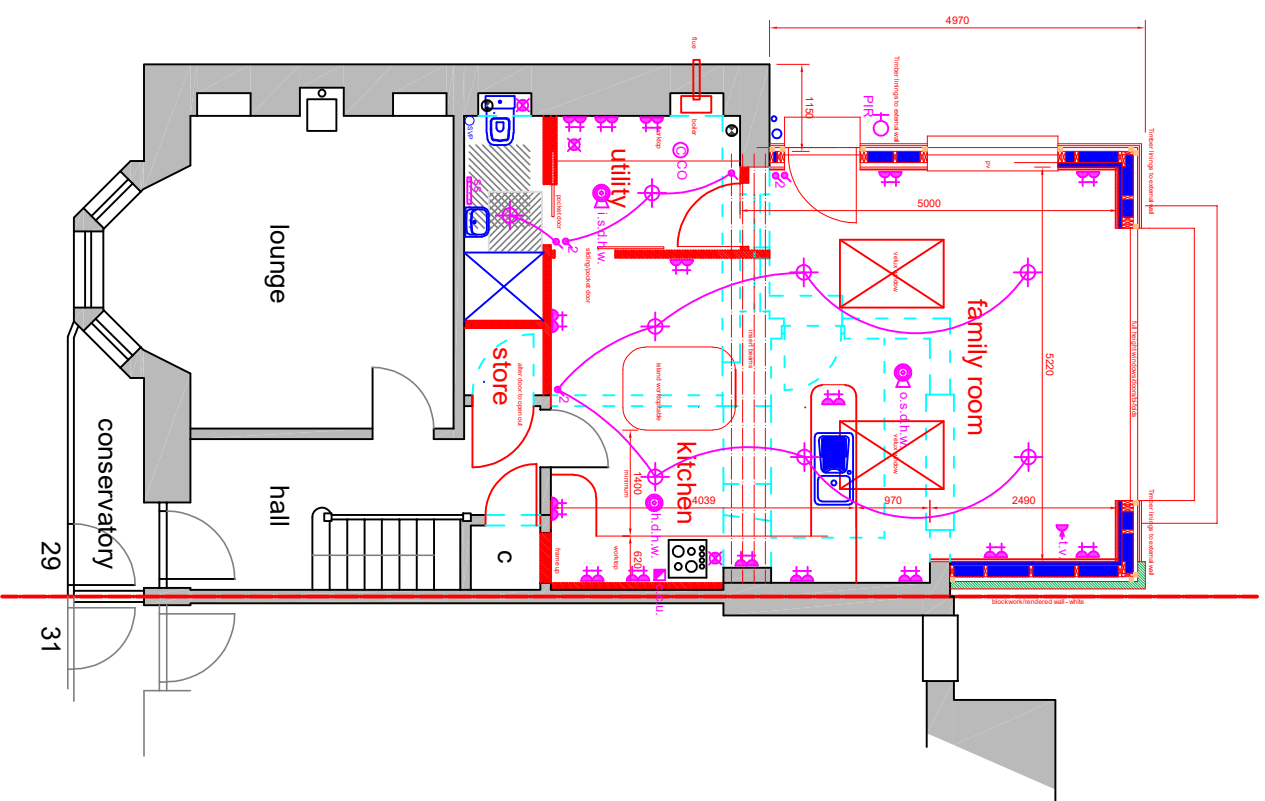

Plan as existing

Plan as proposed



Chartered Practitioner

Professional Registration

Professional Registration

 
Professional Registration

Professional Registration

Professional Registration

Professional Registration

Professional Registration



WJA MacDonnell Building Design Ltd (MCBAT)
 Building Design Consultants
 11 Macdonnell Park
 Knockhill, Inverness
 01463 914002
 07889 720405 (0900)
 www.wjamacdonnell.co.uk

Mr & Mrs D Ker
 Project:
**Erection of extension at
 Duneidin, 29 Leys Drive
 Inverness IV2 3JA**

**Plan3
 Existing & proposed**

DATE: 22.2.2024
 SCALE: 1:100
 DRAWN: WJA macdonnell
 CHECKED:
 0124.2549.301F