


No91-92
 Proposed
 Flood Gate
 1. Main Door

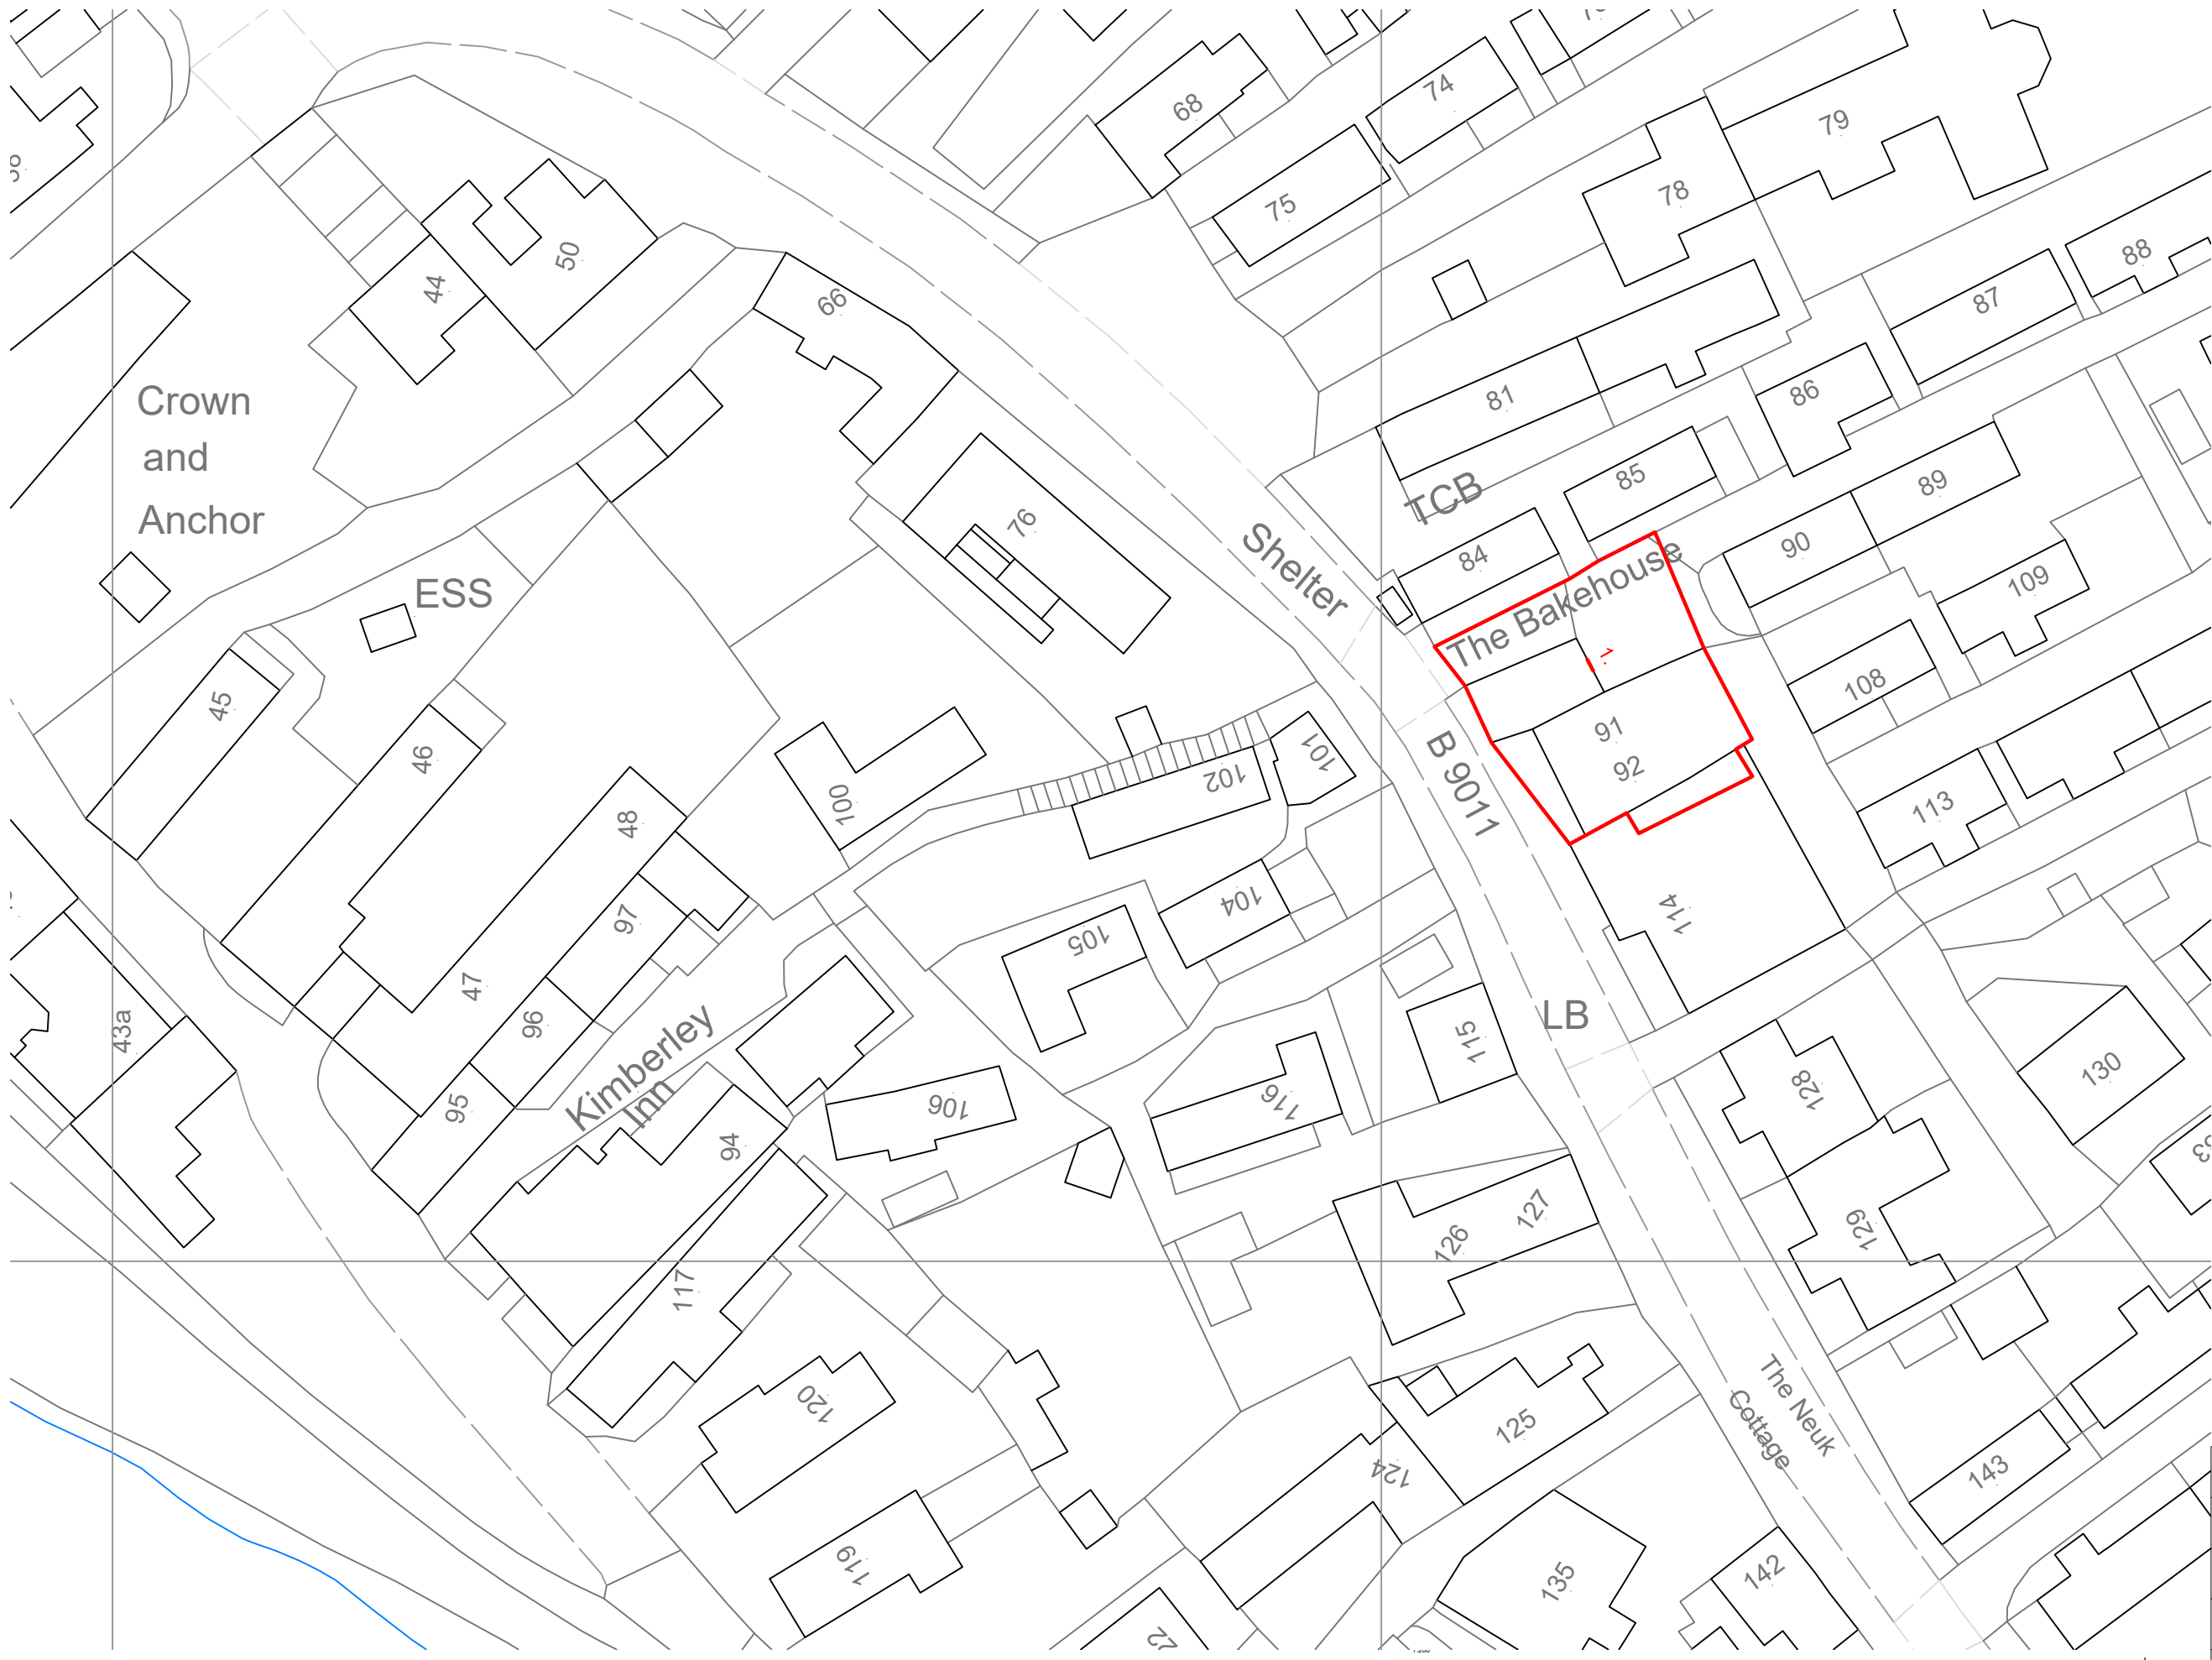

Revision P01 First Issue Date 00-00-00



Client Scottish Water- Colin Faulds			
Project Scottish Water Flood Mitigation			
Title Proposed Site Plan No91-92			
Branch Forfar		Telephone 01307 462516	
Drawn CCS	Date Dec'23	Drg Size A3	Checked CAN
Job No. SA844		Scale 1/500	
Drg No. L(PL)0003			Rev P01

