
 


OV - OPENING SMOKE VENT AND ROOF ACCESS HATCH
 PV - INDICATIVE LOCATION OF PHOTOVOLTAIC PANEL
 ASHP - INDICATIVE LOCATION OF AIR SOURCE HEAT PUMP

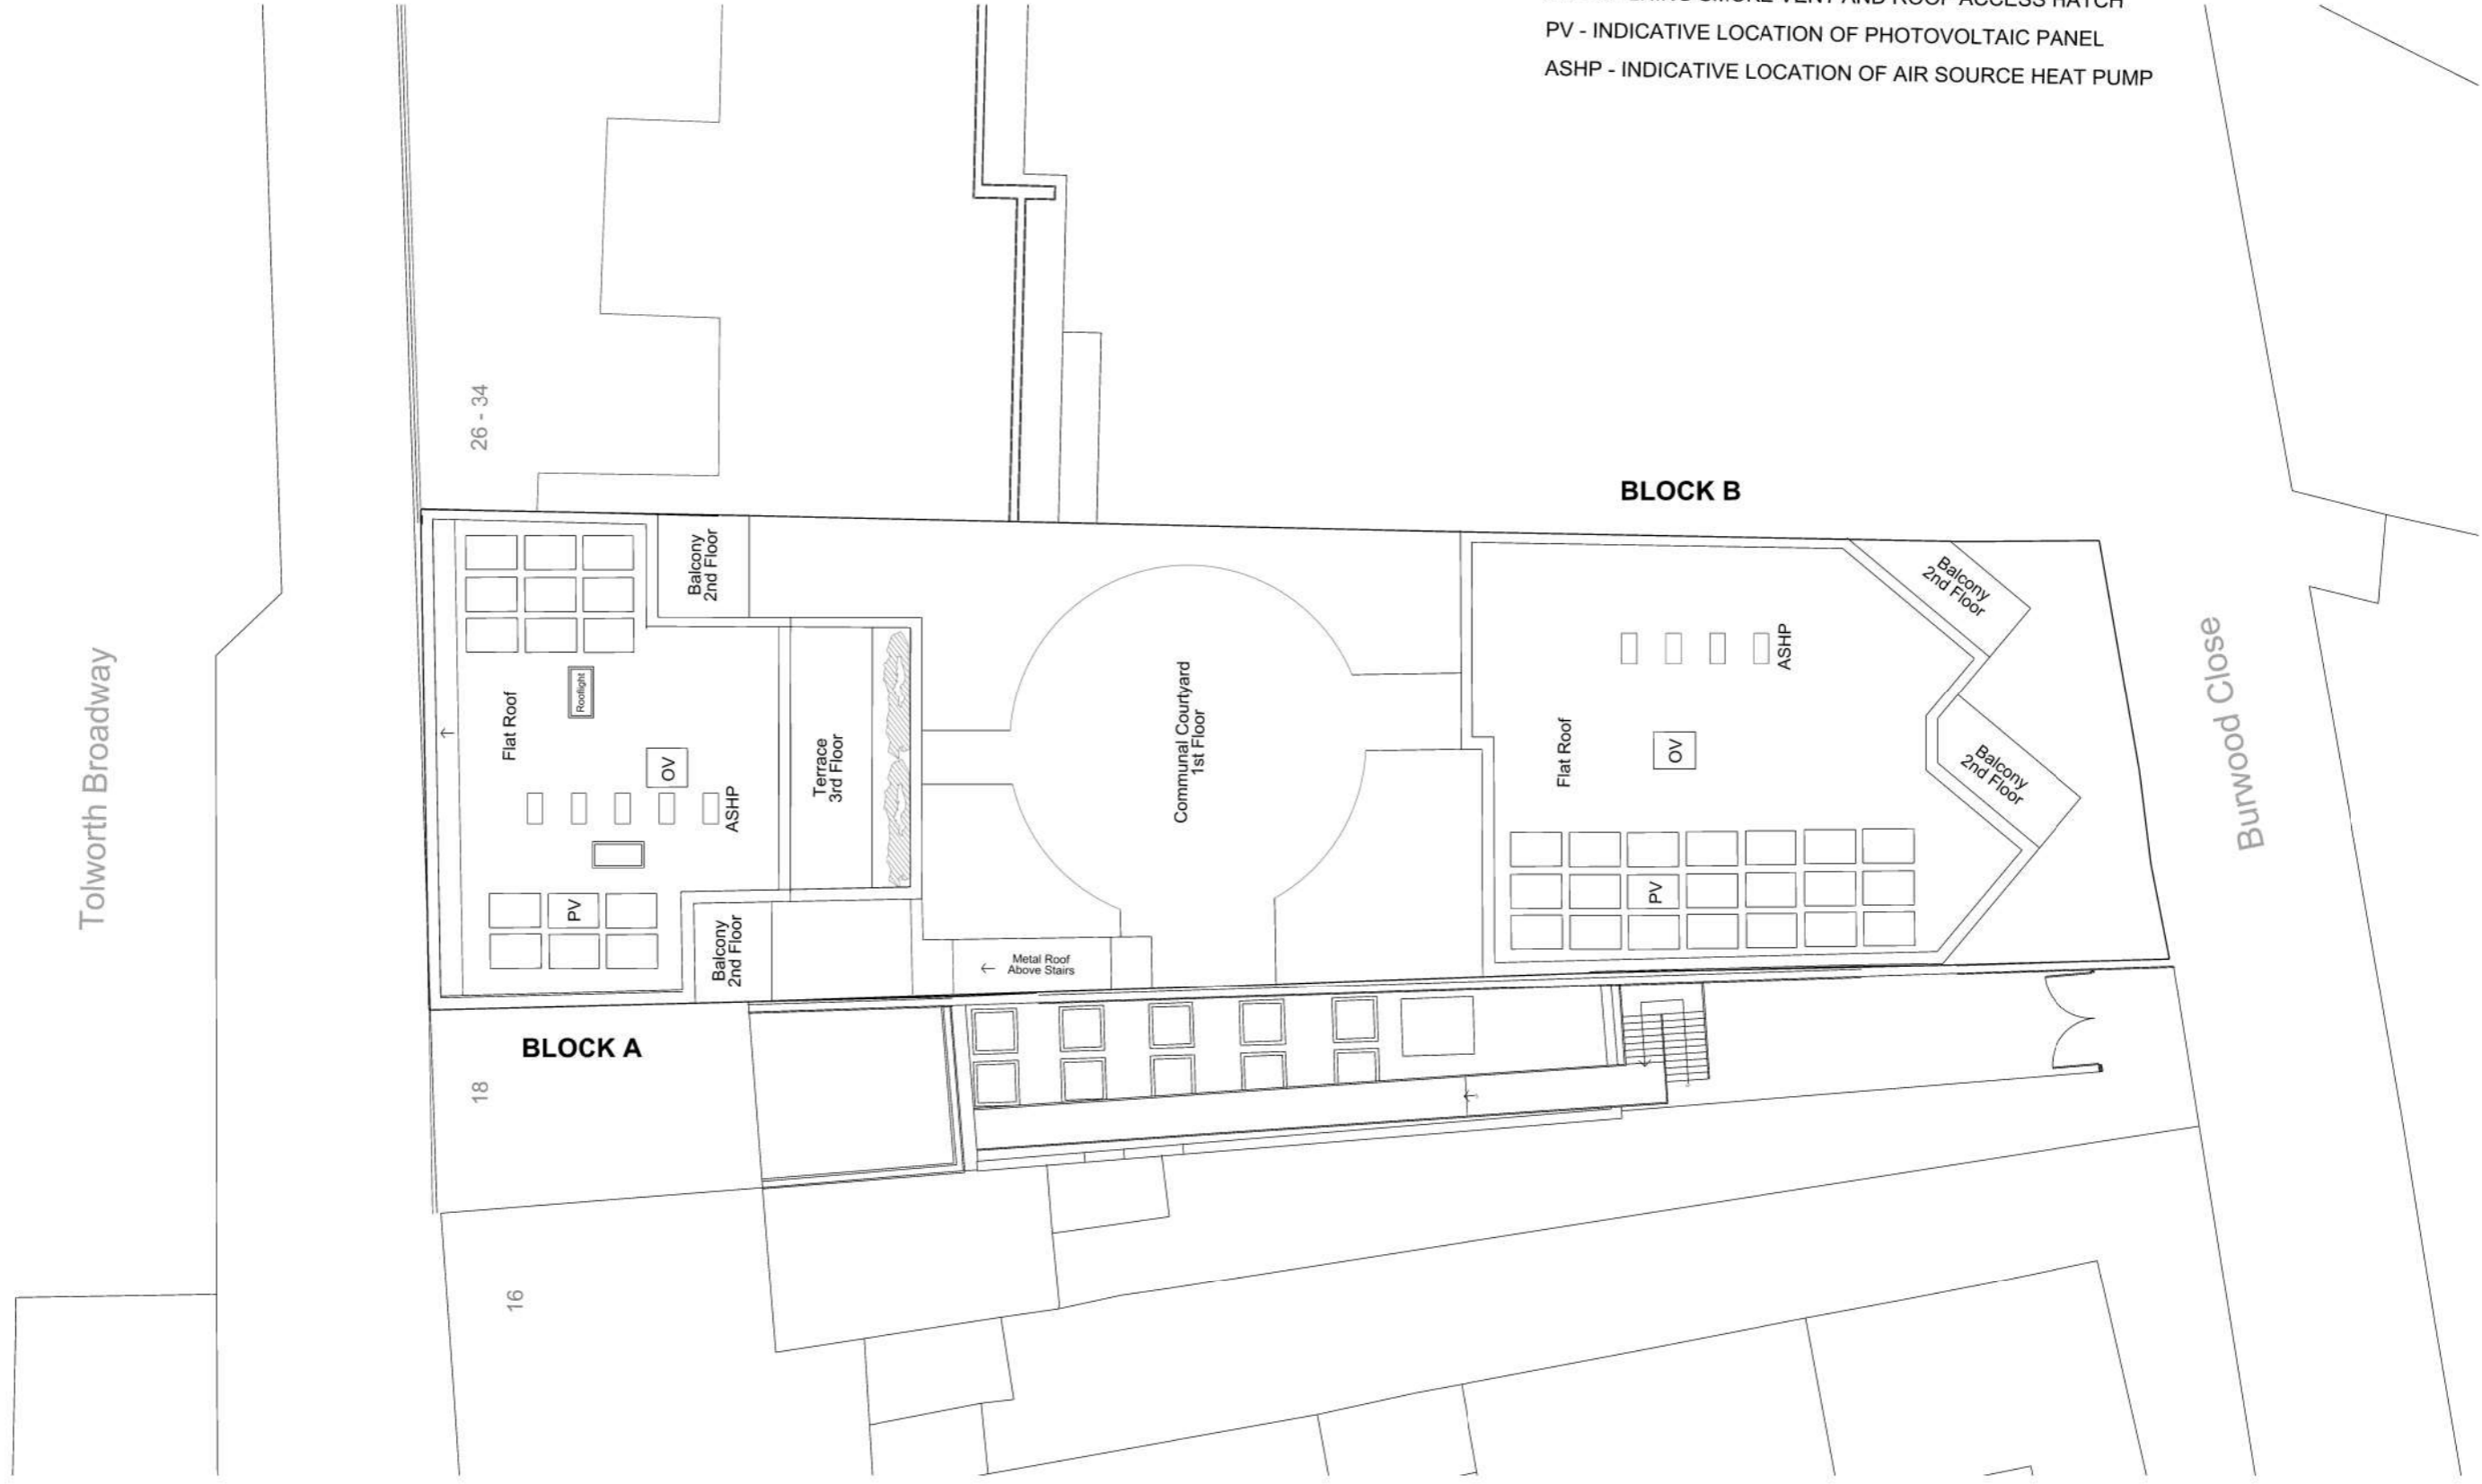

20-24 TOLWORTH BROADWAY KT6 7HL

Proposed Roof Plan



G M L Architects

UNIT 3,1-4 Christina Street, London, EC2A 4PA
 Tel: 020 7729 9595 Fax: 020 7729 1801 info@gmlarchitects.co.uk
 SCALE: 1:100@A1 1:200@A3
 ISSUED FOR: PLANNING
 FIRST ISSUED: 13/02/2024
 DRAWN BY: MG CHECK BY: NM

5062/PA/14