
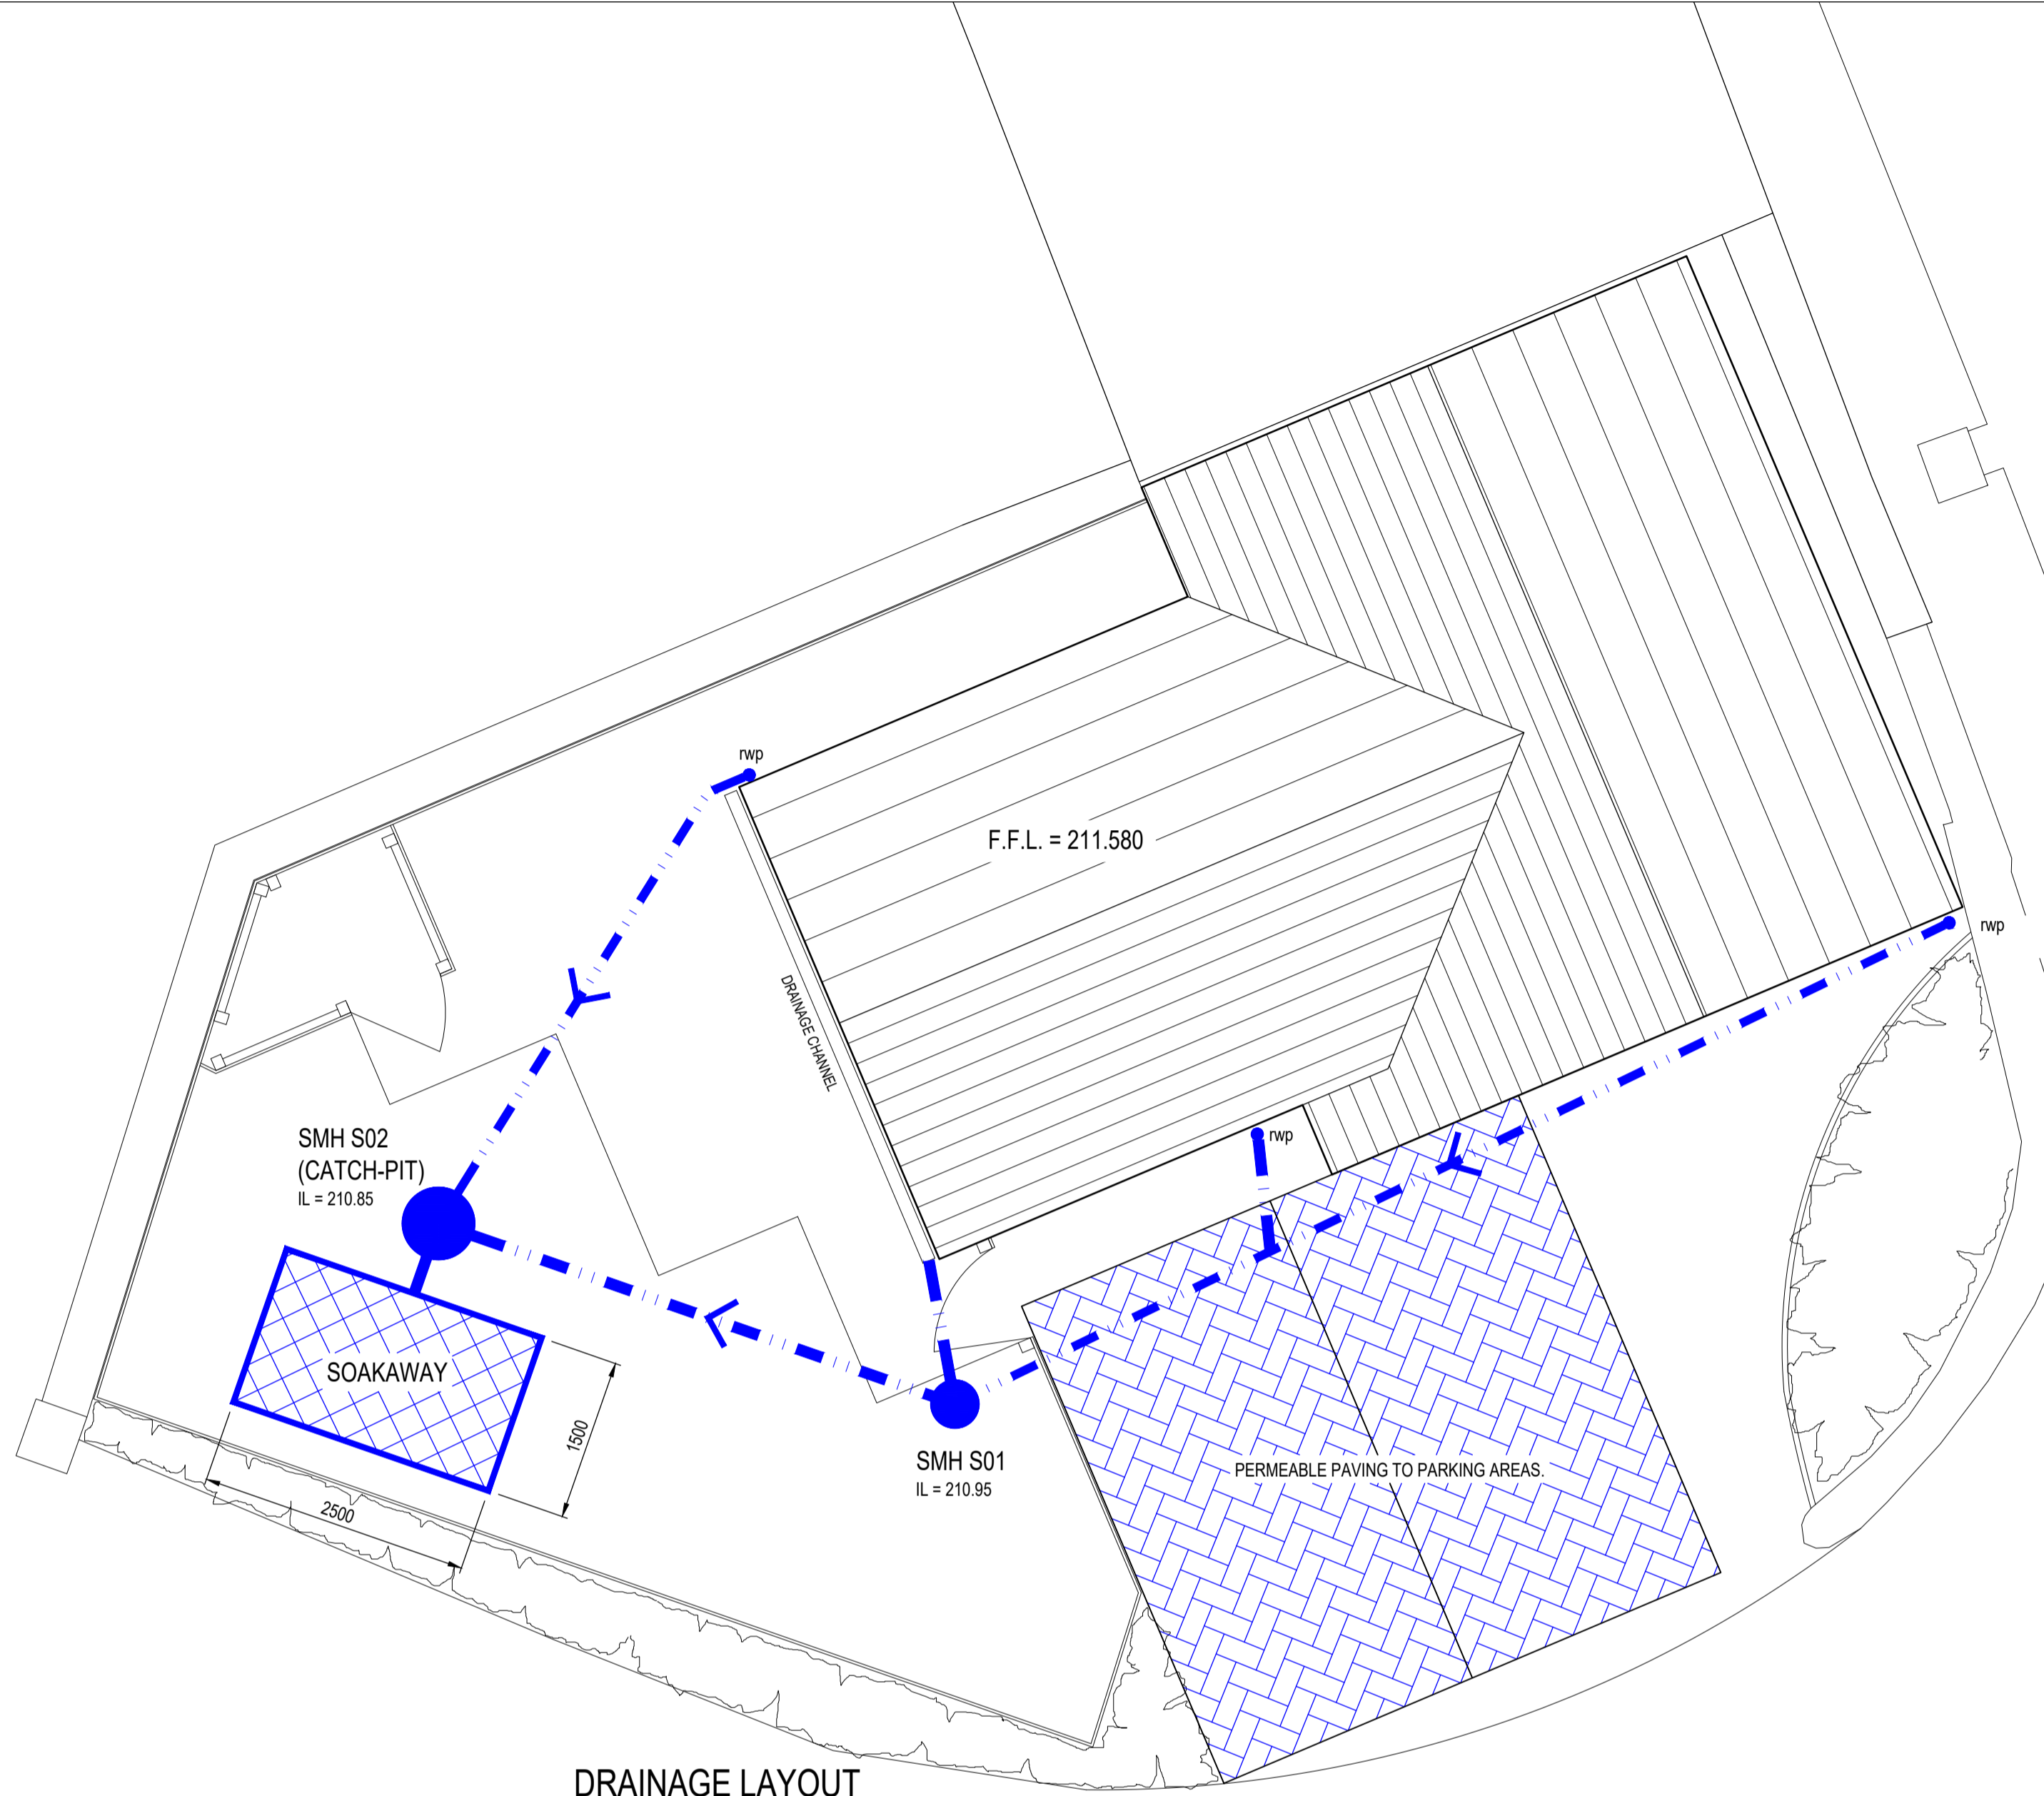


NOTE:
FOUL DRAINAGE CURRENTLY OMITTED
BUT WILL CONNECT TO THAMES
WATER SEWER IN HIGH STREET.


Notes:

- All dimensions are shown in millimetres unless noted otherwise.
- This drawing is to be read in conjunction with all architectural drawings and any other design information.
- All setting out is to be based on the architectural drawings. If there is any discrepancy between this drawing and the architectural drawings, it is to be reported Wellan Ltd.


DRAINAGE LEGEND:

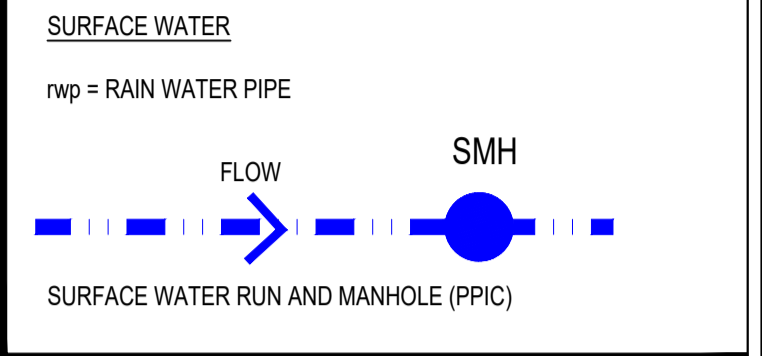

DRAINAGE LAYOUT
SCALE 1:50

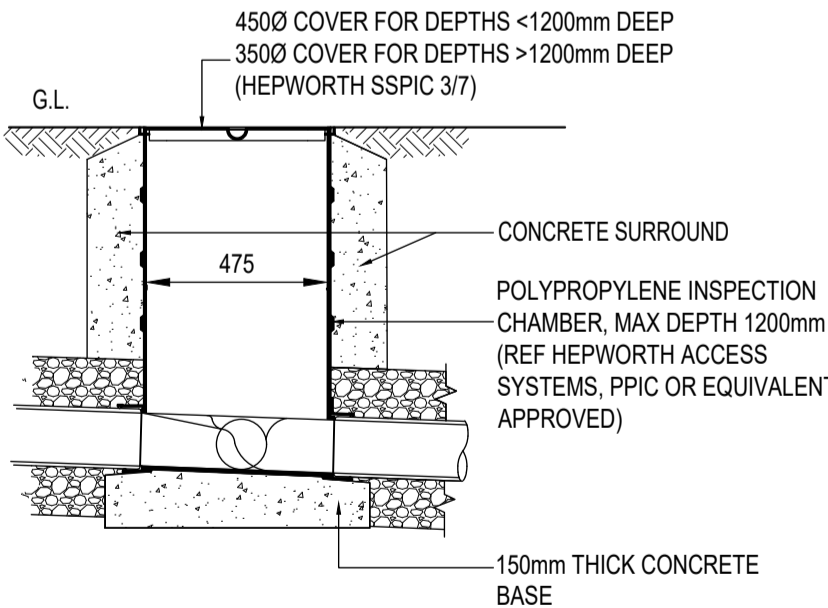

POLYPROPYLENE INSPECTION CHAMBER-PPIC

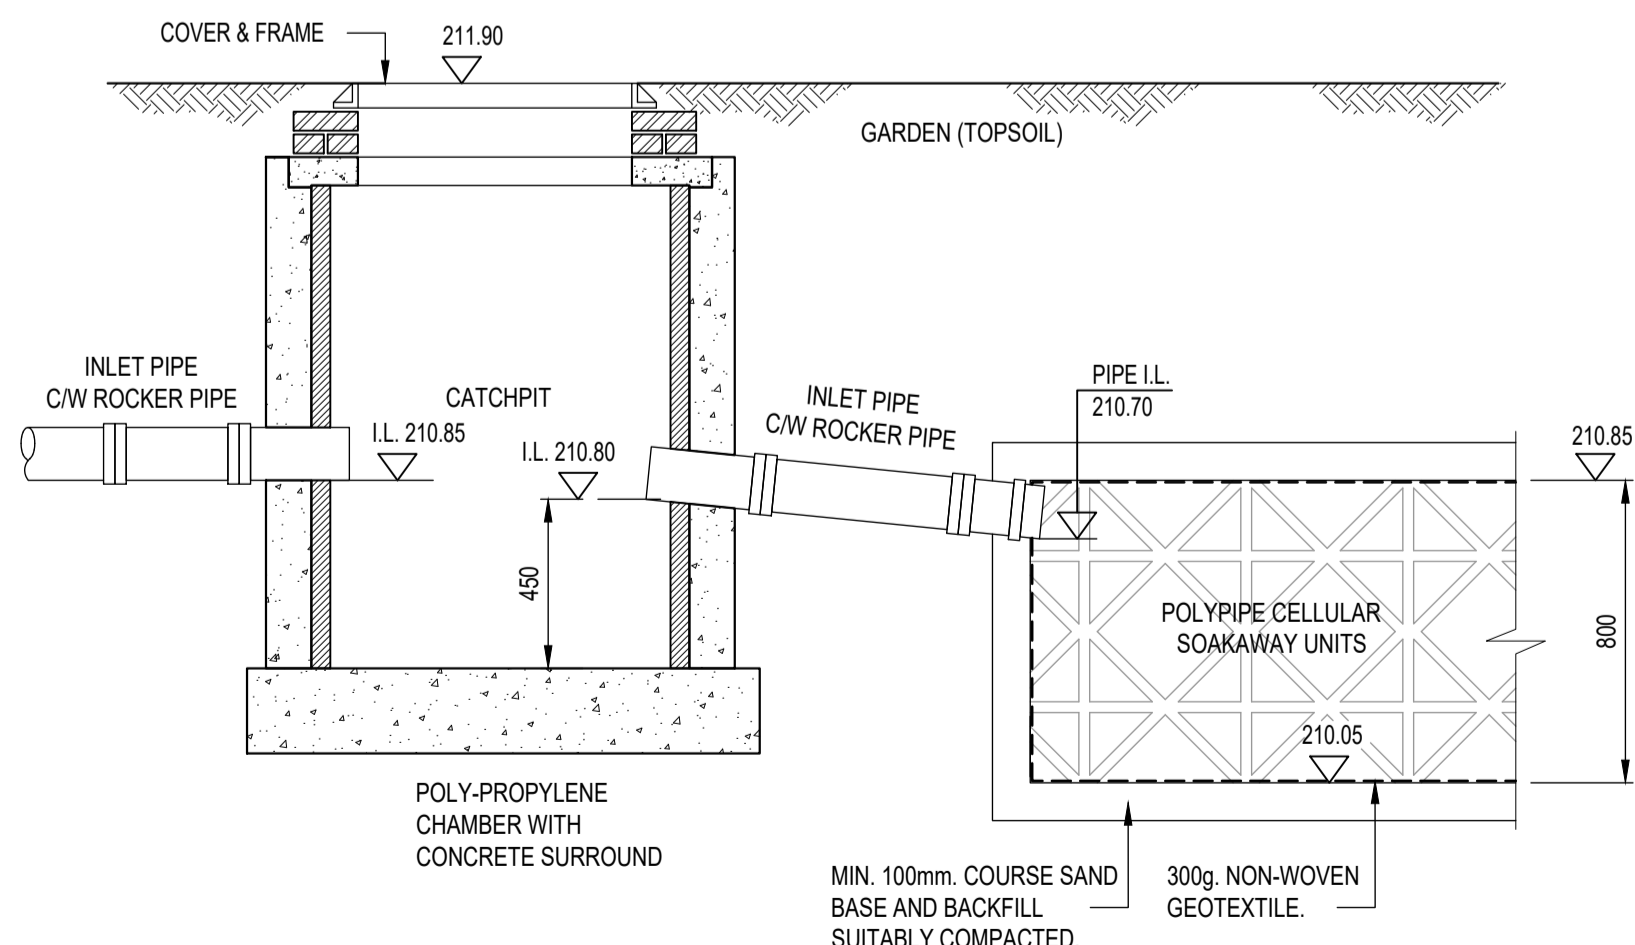

SECTION THRO' CATCH PIT & SOAKAWAY

REV	DATE	BY	DESCRIPTION	CHK	APD

PLANNING CONDITIONS

WELLAN Ltd
Wellan House,
Aylesmore, Shipston-on-Stour,
Warwickshire.
CV36 5EJ
Tel: 01608 685753
Email: mail@wellan.co.uk
Website: www.wellan.co.uk

CLIENT
MR. N. CARTER

PROJECT
NEW DWELLING AT LAND ADJ., TO HUNTS COTTAGE, GREAT ROLLRIGHT.

TITLE
DRAINAGE LAYOUT & DETAILS

SCALE	DATE	DESIGN/DRAWN	CHECKED	APPROVED	SHT	
1:50	1:20	15.03.24	MKW/SM	MKW	HW	A1

JOB No. **23-077**

DRAWING No. **02** REV. 'or'