



Existing Left Side Elevation

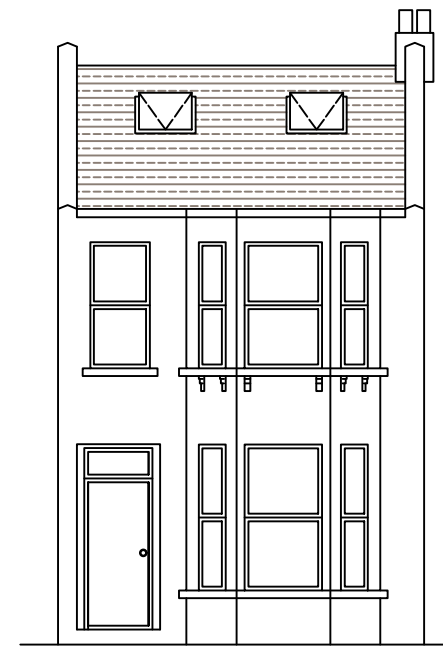

Existing Front Elevation

 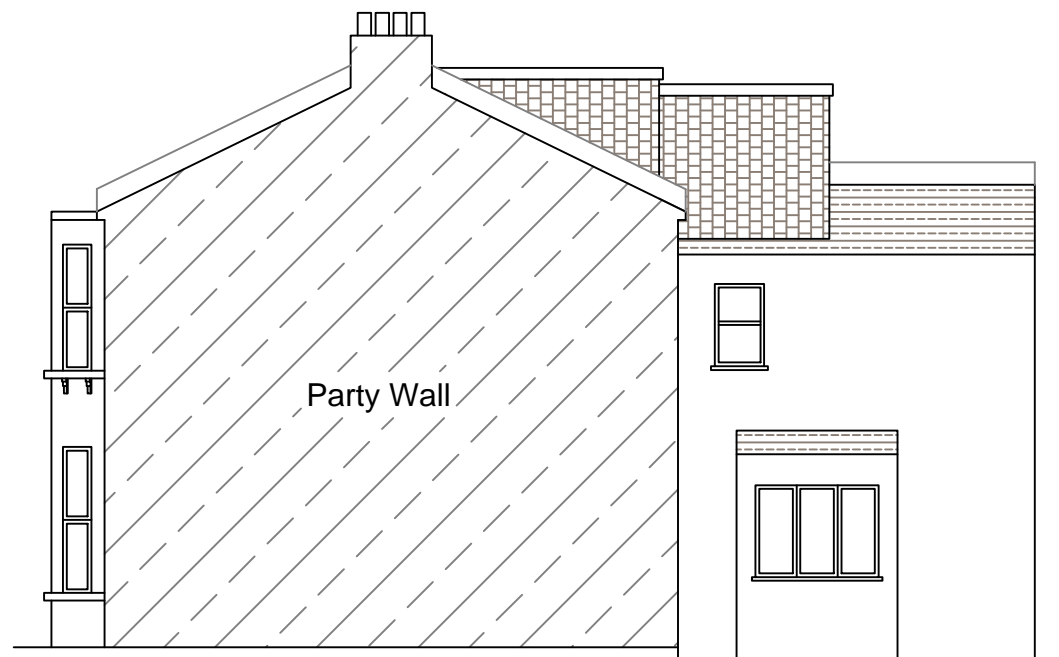


Existing Right Side elevation



Existing Rear Elevation

PURPOSE OF ISSUE:  
Planning



**DISCLAIMER**

All the written dimensions to be checked on site before work commences. Discrepancies, where identified, must be reported to the designer. This drawing must not be reproduced or used in conjunction with any unauthorized person either wholly or in part without valid consent.

Notes to Contractor

Contractor to check and Verify all levels, dimensions etc before construction commences.

Notes to Building Owner

Building owner is advised to ensure that the position of the boundary (line of junction) is confirmed /agreed with the adjoining owner/s before constructing any structure

Notes on Drainage

Existing drainage layout to be exposed and confirmed on site by the contractor before commencing any foundation work. Connect all new drainage to existing mains sewer, in accordance with Part H of Building Regulations, Thames water guidelines and to comply with BS 5572.

**PROJECT ADDRESS**

117 Kilchener Road, Forest Gate,  
E7 8JH

**PROJECT DESCRIPTION**

Rear Extension

**DRAWING TITLE**

Existing Elevations



DRAWN BY: AYR

CHECKED BY: MHK

SCALE: 1:100 @ A3

DRAWING NO: XLN02

DATE: 03/03/2024

REVISION NO: 0