



LOCATION PLAN 1:1250

 
 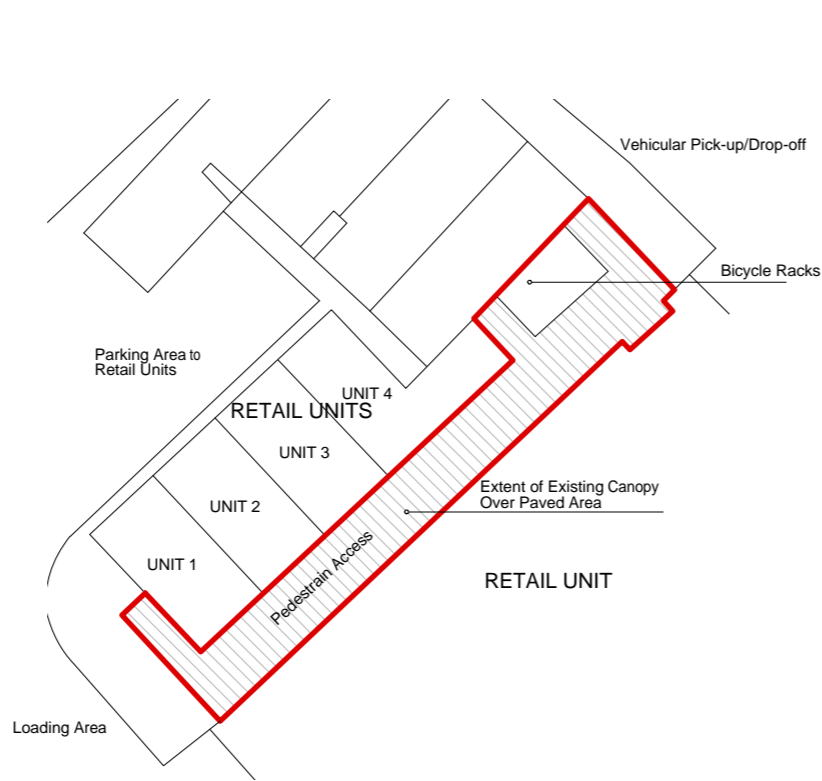



SITE PLAN (Existing) 1:500

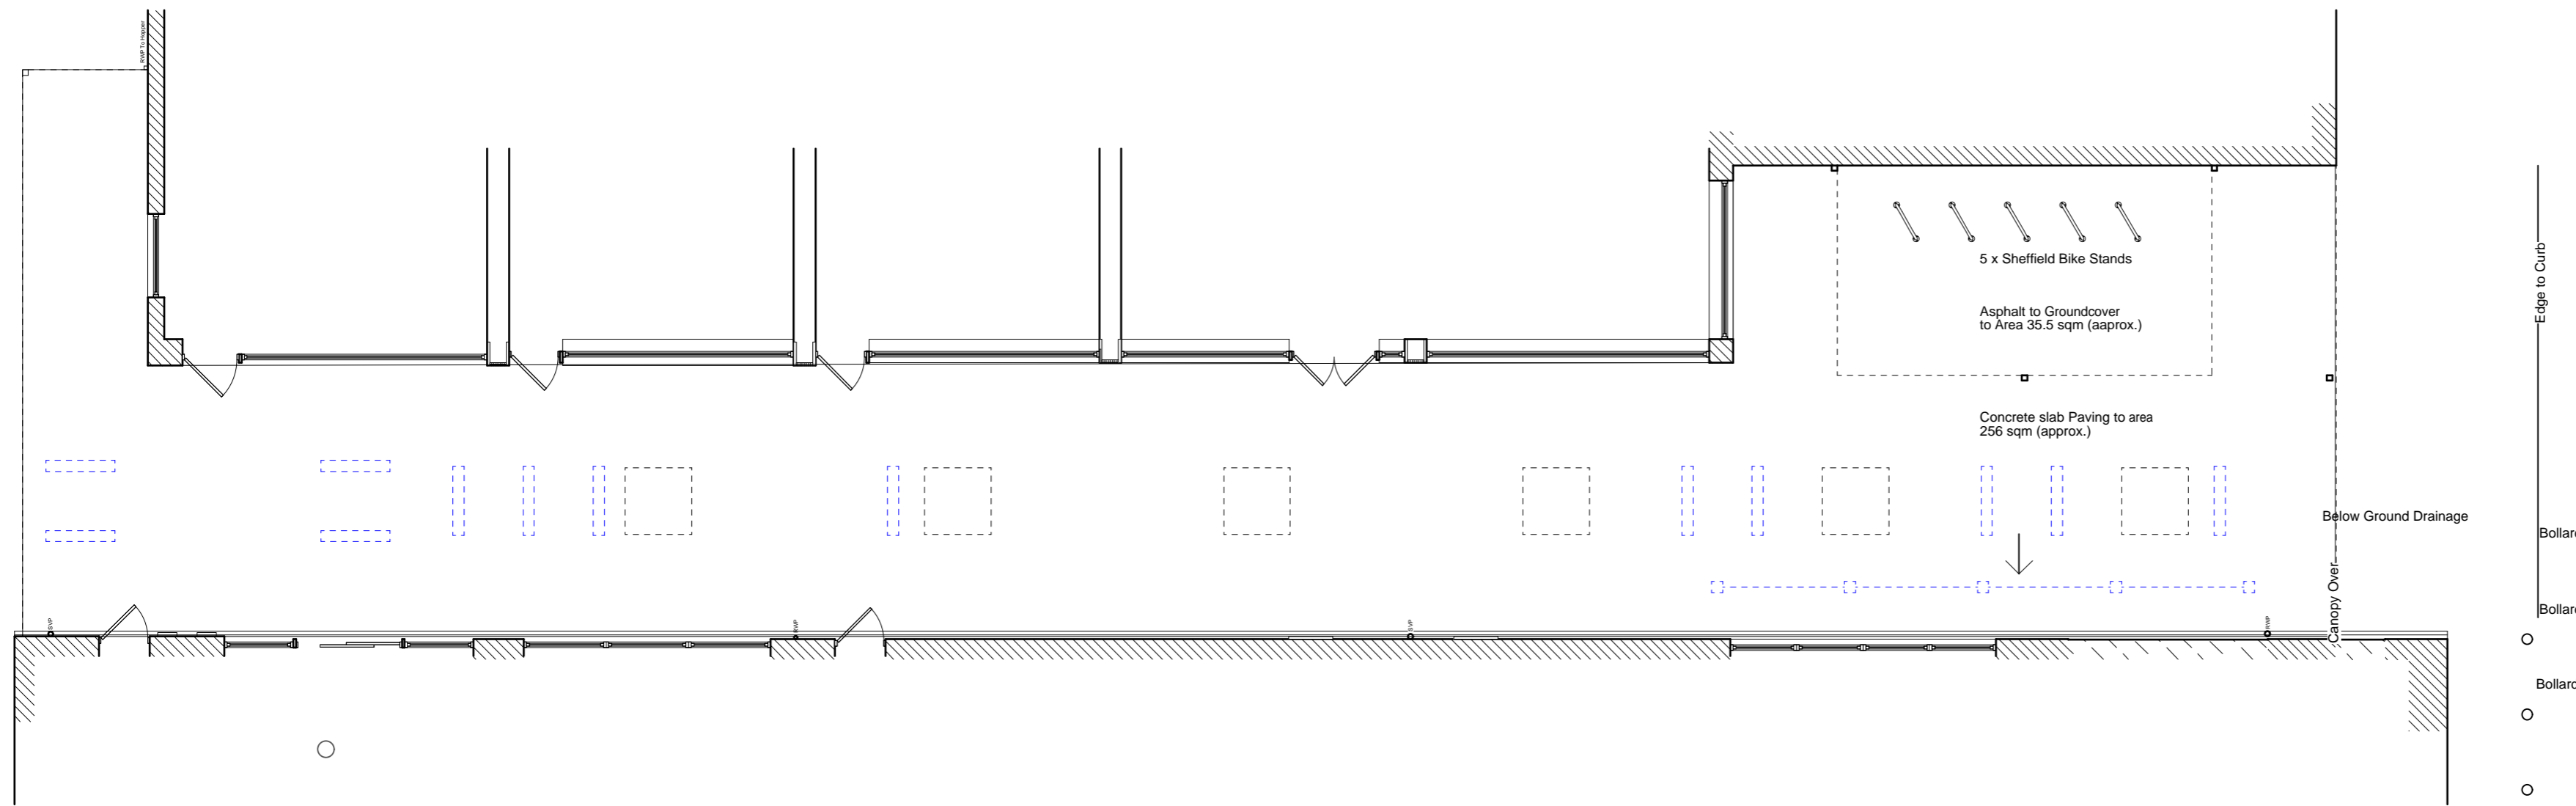

GROUND FLOOR/CANOPY PLAN (Existing) 1:100

KEY

-  Existing Glazed Skylight
-  Fluorescent Tube Lighting
-  Fluorescent Spot Lighting

Job Title: NHA BBC-SA-001
Address: Salisbury Rd Arcade, Salisbury Rd. Totton SO40

1. ALL DIMENSIONS IN MM. DO NOT SCALE FROM THIS DRAWING
2. ALL SPECIFIED ITEMS IN LINE WITH MANUFACTURERS RECOMMENDATIONS
3. ALL GIVEN LABELS & DIMENSIONS TO BE CHECKED & CONFIRMED ON SITE
4. THE CONTRACTOR, SUB CONTRACTOR OR SPECIALIST CONTRACTOR SHOULD INFORM THE ARCHITECT OF ANY DISCREPANCIES
5. ALL RIGHTS RESERVED

Scale: 1:100 & Various @ A2

Drg.No. NHA-002-P *
Planning Drawings
Existing Plans

Drawn by: NJH

Issued to: Local Authority/Client

Status: Approvals

Date: 26.02.2024