 



01 Proposed Site Plan @ 1:100 (1:200 @ A3)  
1002



1:100 @ A1 (1:200 @ A3)

- General Notes:**
1. Do not scale from drawing;
  2. All dimensions in millimeters unless noted otherwise;
  3. All drawings are to be read in colour;
  4. All dimensions and levels based on architect's survey information. All dimensions and levels to be validated at Contractor's Detailed design stage and prior to Construction;
  5. All setting out to be confirmed by Contractor for approval by WWP for co-ordination with specialist suppliers. The Contractor is to notify the WWP design team of any discrepancies.

**Keyplan:**

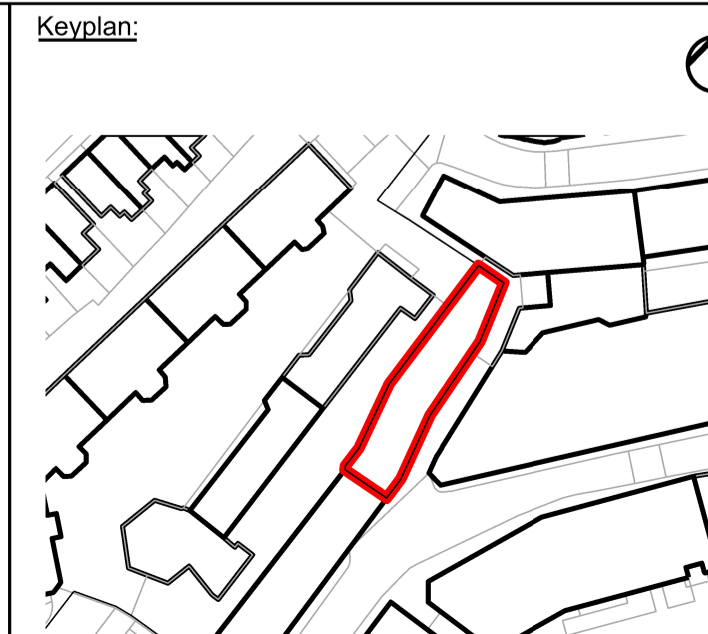

**Architect:**  
**WestonWilliamson+Partners**  
12 Valentine Place  
London  
SE1 8QH  
Tel +44(0) 20 7401 8877  
www.westonwilliamson.com

**Project:**  
**2 Pontypool Place  
New AC System Proposal**  
**Title:**  
**2 Pontypool Place  
Proposed Site Plan**

**Legend:**

Site Boundary	Level on plan
12 Valentine Place Boundary	Existing
2 Pontypool Place Boundary	Proposed Works

Scale: 1:50 @ A1	Date: 15/03/24	Drawn: SSIL	Checked: JB	Approved: GB
Status: Planning Submission				Suitability:
Drawing Number: <b>1027-WWP-2PP-00-PL-A-1002</b>				Revision: <b>B01</b>