


LEGEND


- GAS METERS
- ELECTRICAL METERS
- BOILER
- CONSUMER UNIT
- MEGAFLOW UNIT
- RADIATOR
- HEATED TOWEL RAIL
- DIRECTION OF ROOF FALL
- INSPECTION CHAMBER
- SOIL VENTILATION STACK
- STUB STACK
- RAINWATER PIPE
- GULLEY
- WATER FEED/DR TAPS
- PENDANT LIGHT FITTING
- WALL MOUNTED LIGHT FITTING
- SPOT/DOWN LIGHT FITTING
- UP LIGHT FITTING
- EXTERNAL LIGHT FITTING
- CEILING FAN
- 30MIN FIRE RATED DOOR
- SMOKE DETECTOR
- HEAT DETECTOR
- CARBON MONOXIDE DETECTOR
- TOUGHENED SAFETY GLASS
- OBSCURE GLAZING
- 30L/S MECHANICAL VENTILATION
- 60L/S MECHANICAL VENTILATION
- BESPOKE MECHANICAL VENTILATION
- KITCHEN VENTILATION FLUE
- BATHROOM VENTILATION FLUE
- UTILITY ROOM VENTILATION FLUE
- BOILER VENTILATION FLUE
- TUMBLE DRYER VENTILATION




EXISTING FRONT ELEVATION (E) 1:50 @ A1

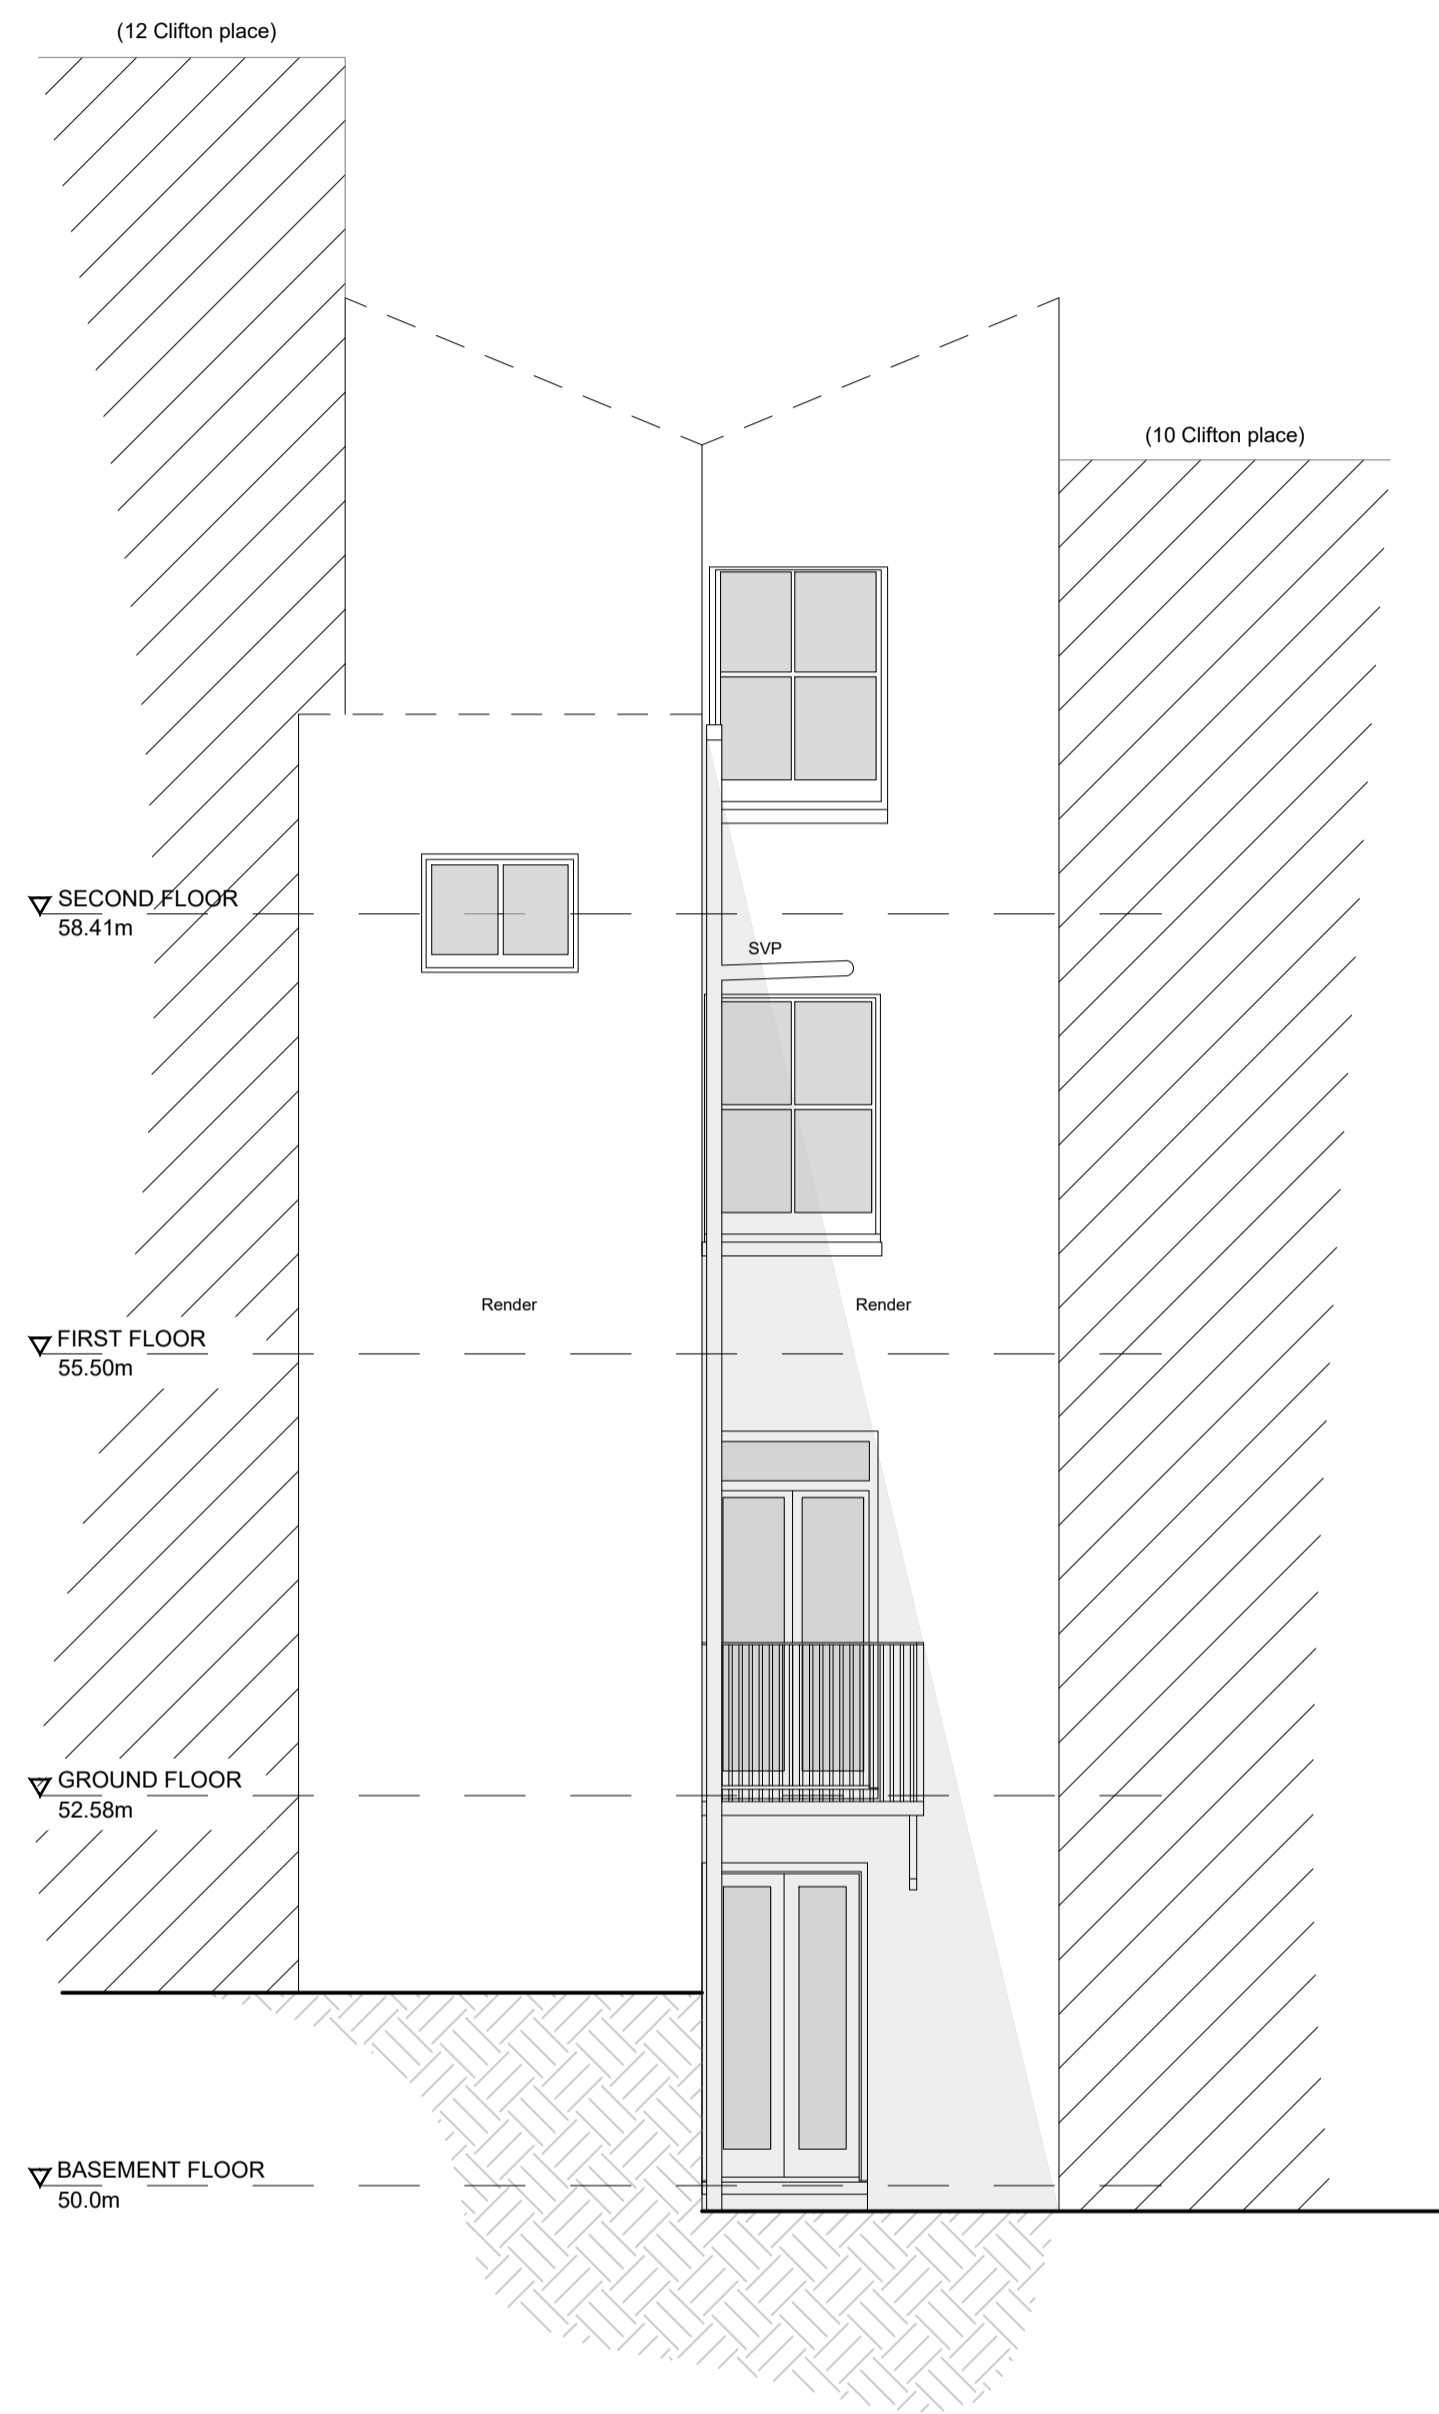

EXISTING REAR ELEVATION (W) 1:50 @ A1

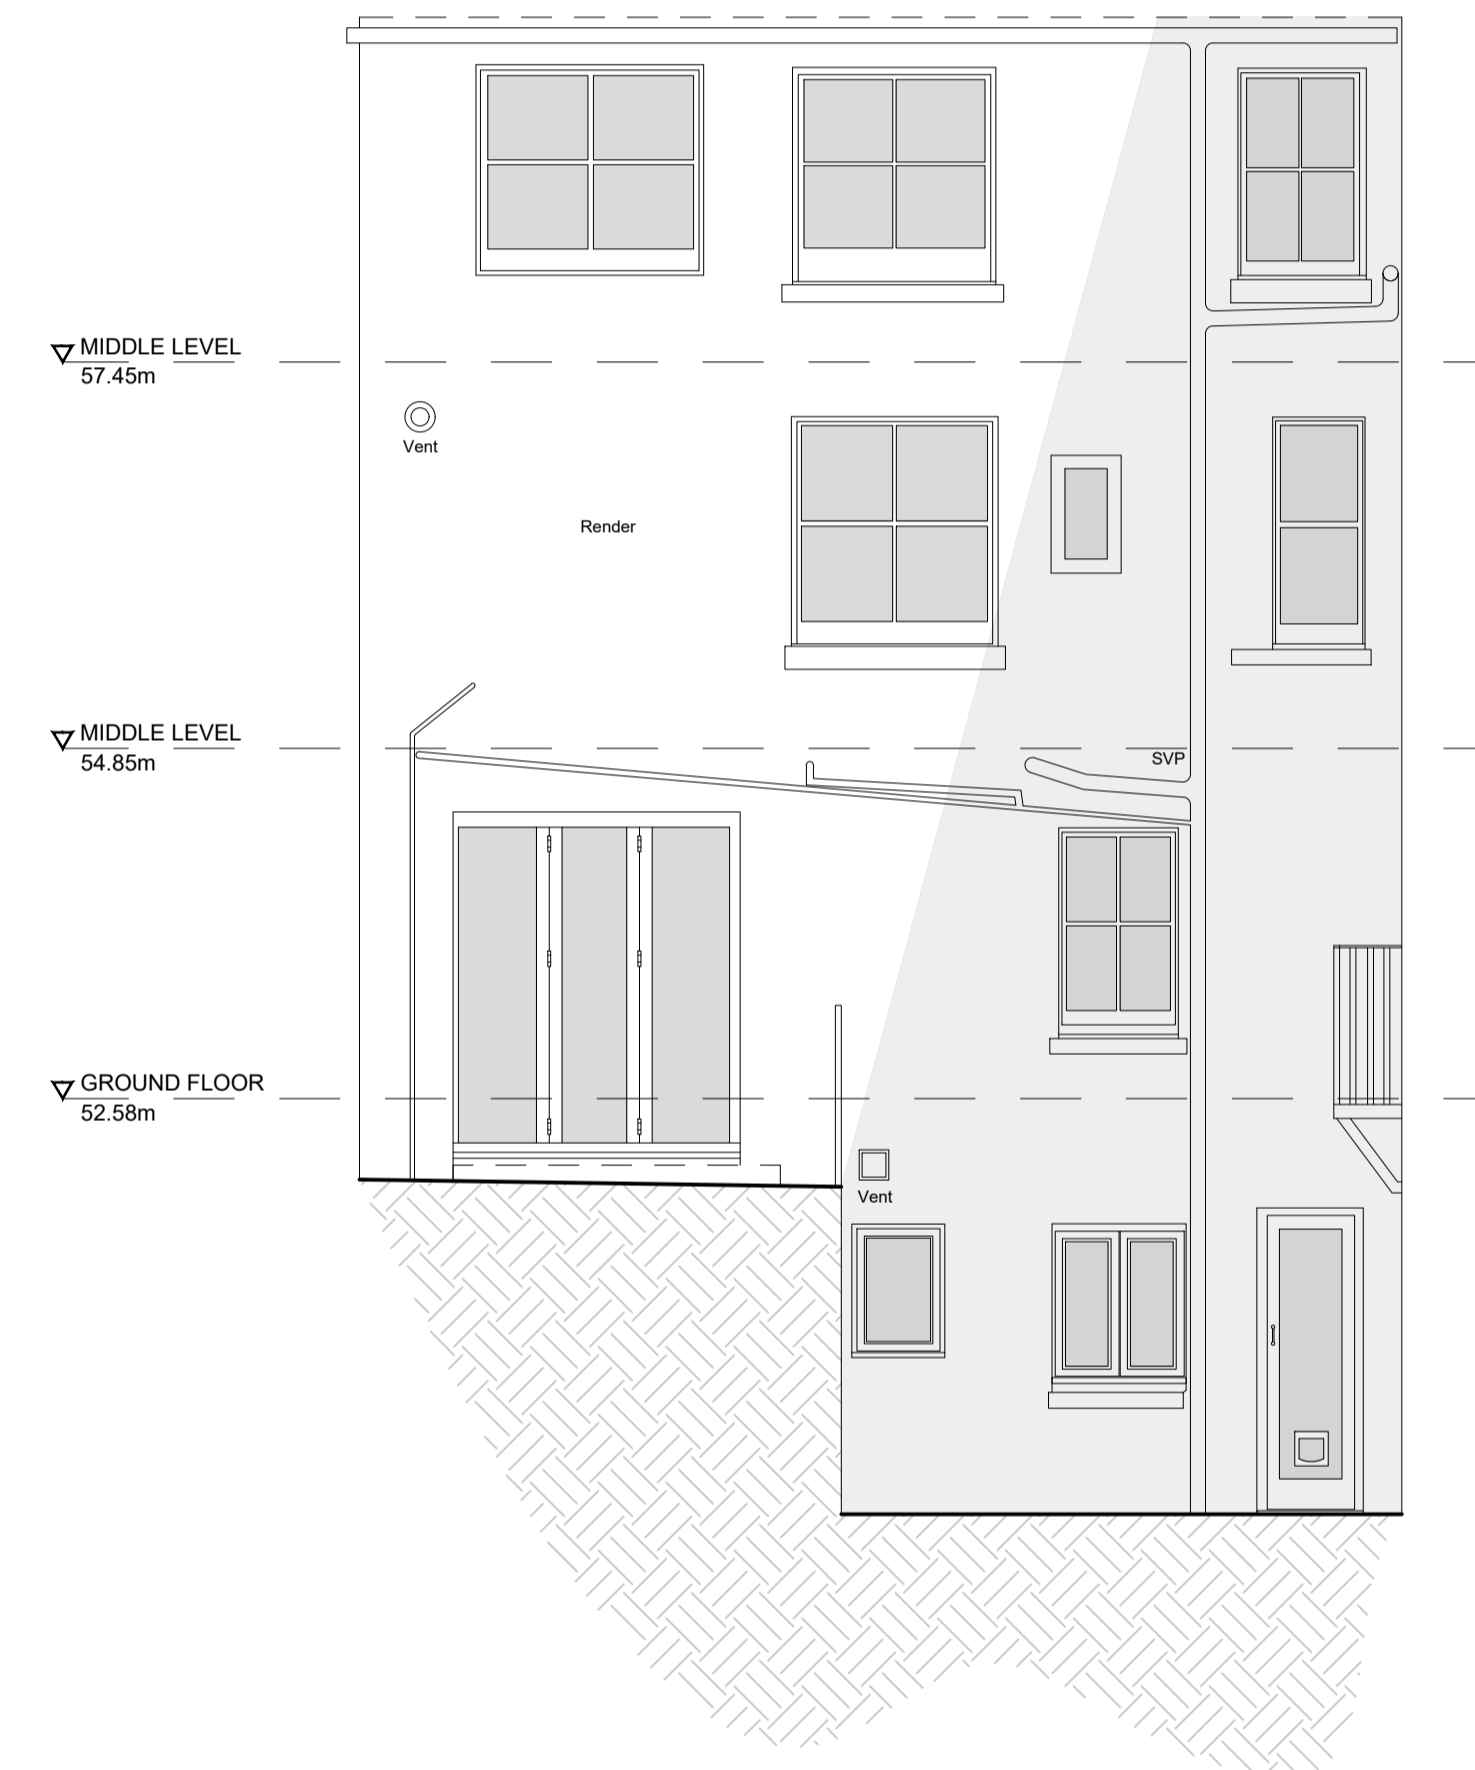

EXISTING SIDE ELEVATION (S) 1:50 @ A1

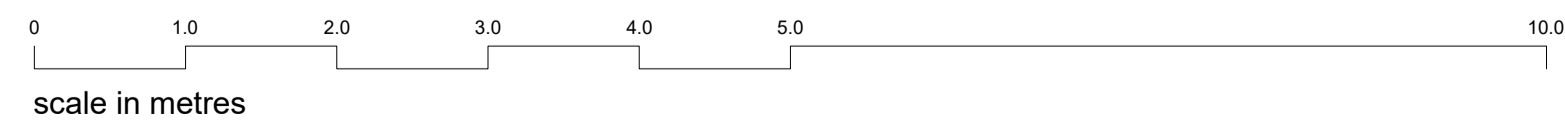

LIFE SIZE

01273 688 744
studio@lifesizearchitecture.co.uk
www.lifesizearchitecture.co.uk

title: _____ date: _____ revision: _____

EXISTING ELEVATIONS

project no: **22025CP** drawing no: **004**

drawing status: **PLANNING**

client: MR & MRS HASSELL-HART
project: 11 CLIFTON PLACE, BRIGHTON
PROPOSED MINOR EXTERNAL AMENDS

date: 05.12.23 scale: 1:50 @ A1 drawn: MB checked: MB